



| | | | | |
|-----------------------|-----------------|----------|------------------|-----------|
| F.A.I. RTE. | SECTION | COUNTY | TOTAL SHEETS | SHEET NO. |
| 90/94 | 2021-922PT.1-AC | COOK | 460 | 84 |
| STA. 103+00 | TO STA. 108+00 | | | |
| FED. ROAD DIST. NO. 1 | | ILLINOIS | FED. AID PROJECT | |
| 62693 | | | | |

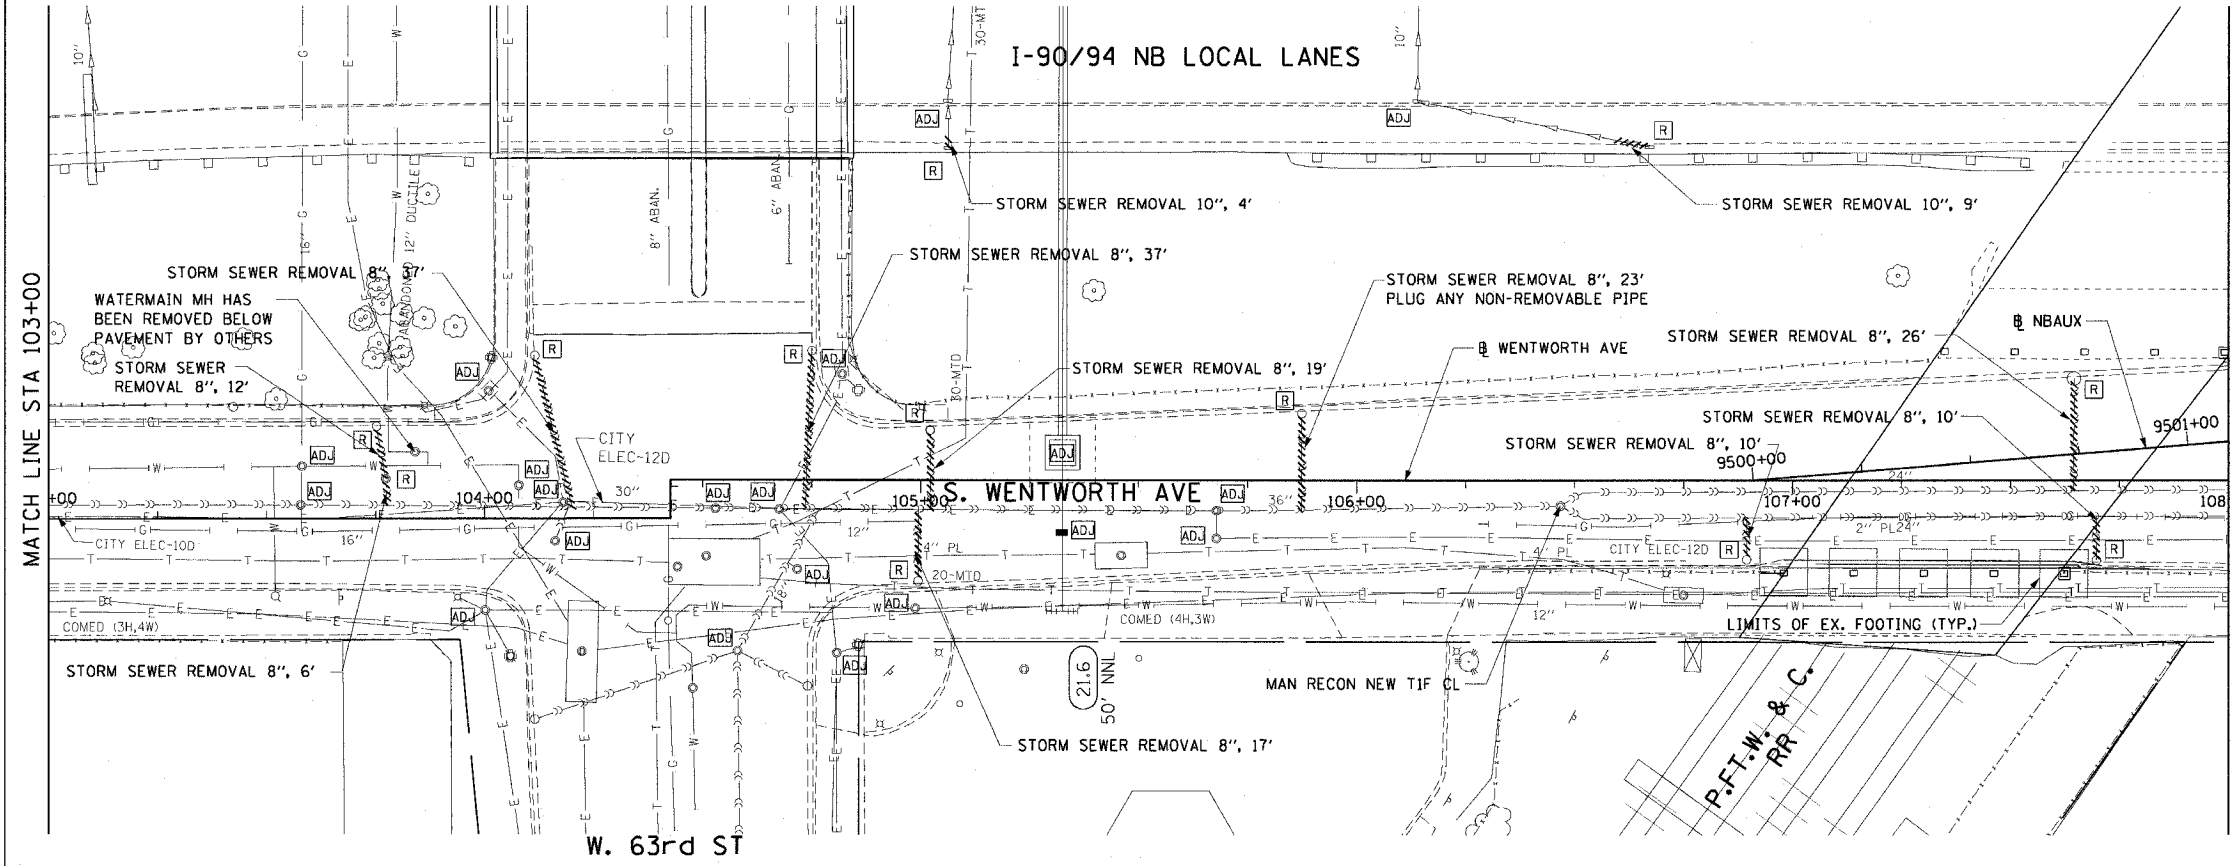

- LEGEND: EXISTING**
- INLET
 - CATCH BASIN
 - MANHOLE
 - STORM SEWER
 - COMBINED SEWER
 - PIPE UNDERDRAIN
 - [R] STRUCTURE TO BE REMOVED
 - [AD] STRUCTURE TO BE ADJUSTED
 - //// STORM SEWER REMOVAL OR ABANDON
 - //// COMBINED SEWER REMOVAL OR ABANDON

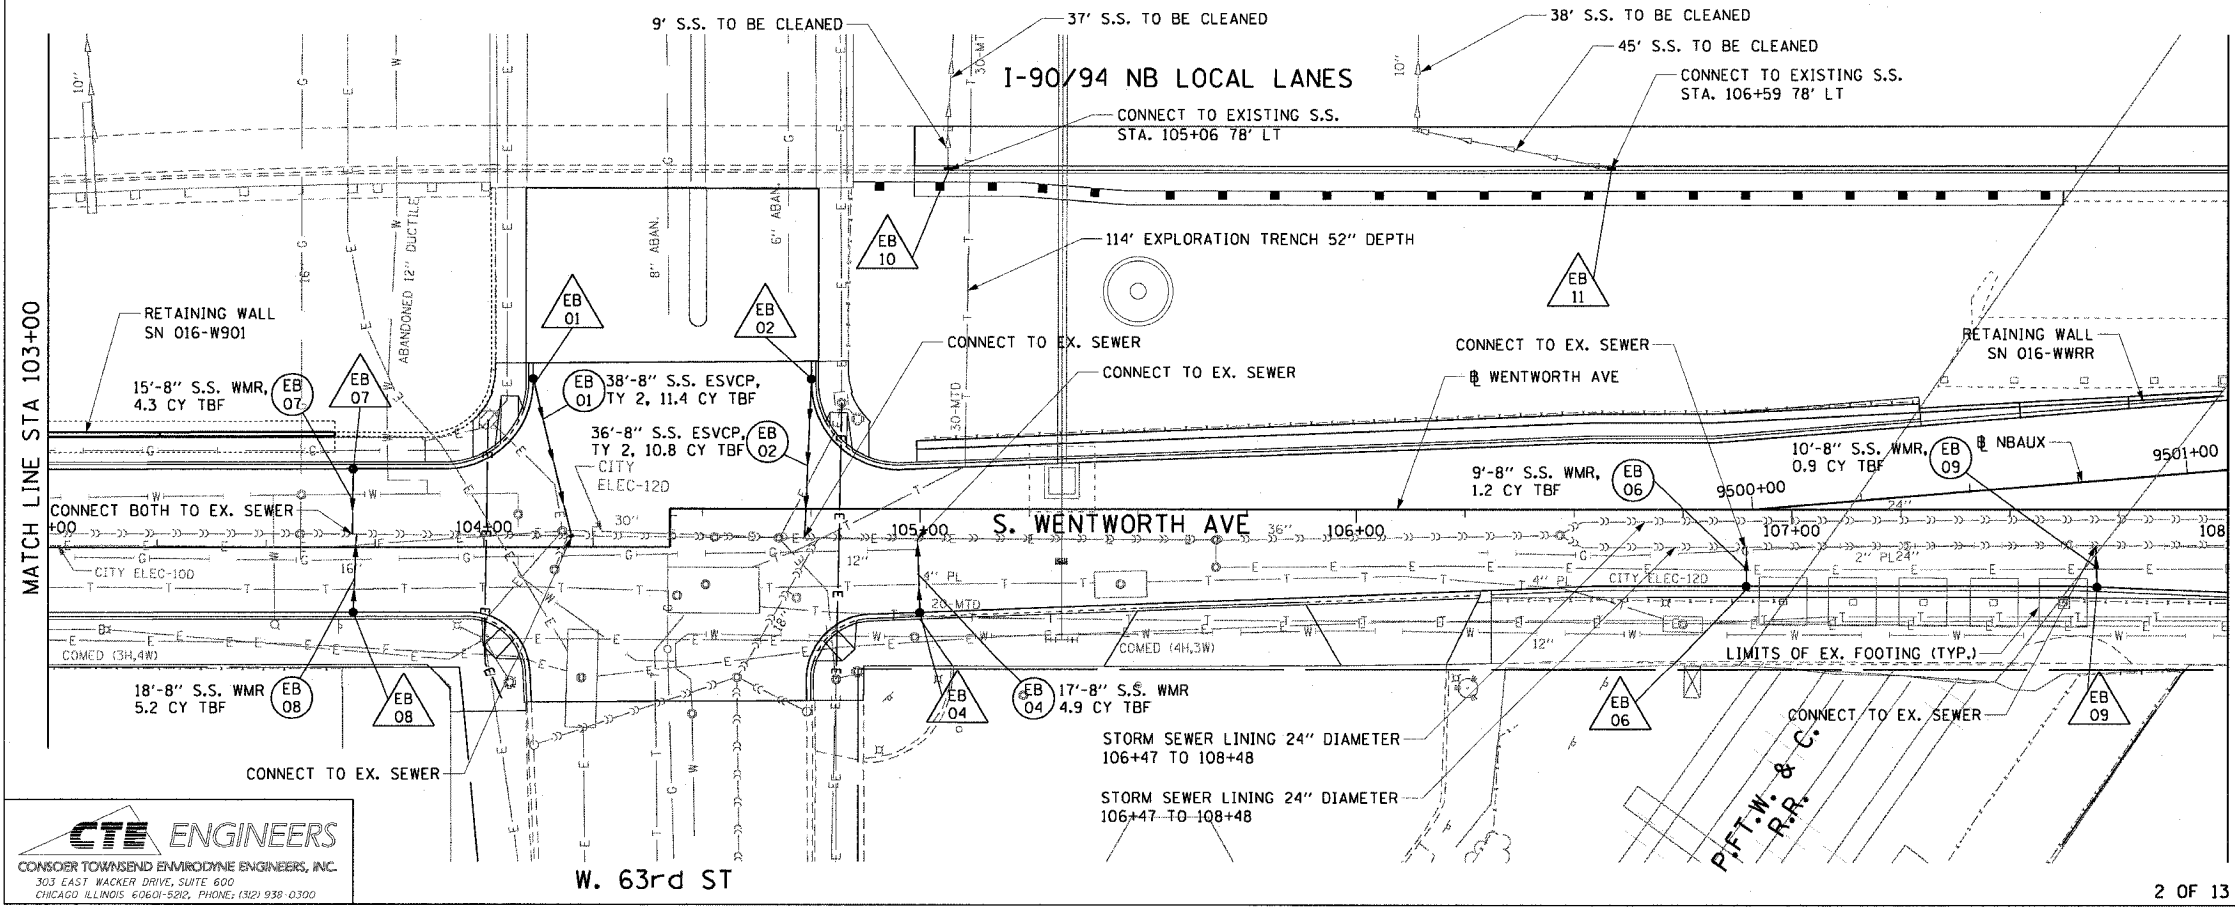

- LEGEND: PROPOSED**
- INLET
 - CATCH BASIN
 - MANHOLE
 - STORM SEWER
 - COMBINED SEWER
 - PIPE UNDERDRAIN
 - PROPOSED SWALE
 - (EA 01) PROPOSED STORM SEWER PIPE
 - △(EA 01) PROPOSED STRUCTURE
 - CITY ELECTRIC HANDHOLE

NOTES:
 1. SEE DRAINAGE SCHEDULES FOR STRUCTURE, PIPE AND UNDERDRAIN INFORMATION.

| REVISIONS | |
|-----------|------|
| NAME | DATE |
| | |
| | |
| | |
| | |

ILLINOIS DEPARTMENT OF TRANSPORTATION
 F.A.I. 90/94 (DAN RYAN EXPRESSWAY)
 63rd ST TO 59th ST (FRONTAGE ROAD & RAMPS)

**DRAINAGE AND UTILITY PLANS
 WENTWORTH AVENUE**

SCALE: 1"=20'
 DATE: October 29, 2004

DRAWN BY: JB
 CHECKED BY: EBY

CTE ENGINEERS
 CONSER TOWNSEND ENVIRONMENTAL ENGINEERS, INC.
 303 EAST WACKER DRIVE, SUITE 600
 CHICAGO, ILLINOIS 60601-5920, PHONE: (312) 938-0300

11/22/2004 03:30:50 PM \\P:\0466\CIVIL\466-Civil\90-94\Site\Drainage and Utility Plans\091022.dwg