


F.A.I. RTE.	SECTION	COUNTY	TOTAL SHEETS	SHEET NO.
90/94	2021-922PT.1-AC	COOK	460	88
STA. 123+00	TO STA. 128+00			
FED. ROAD DIST. NO. 1	ILLINOIS	FED. AID PROJECT		
62693				

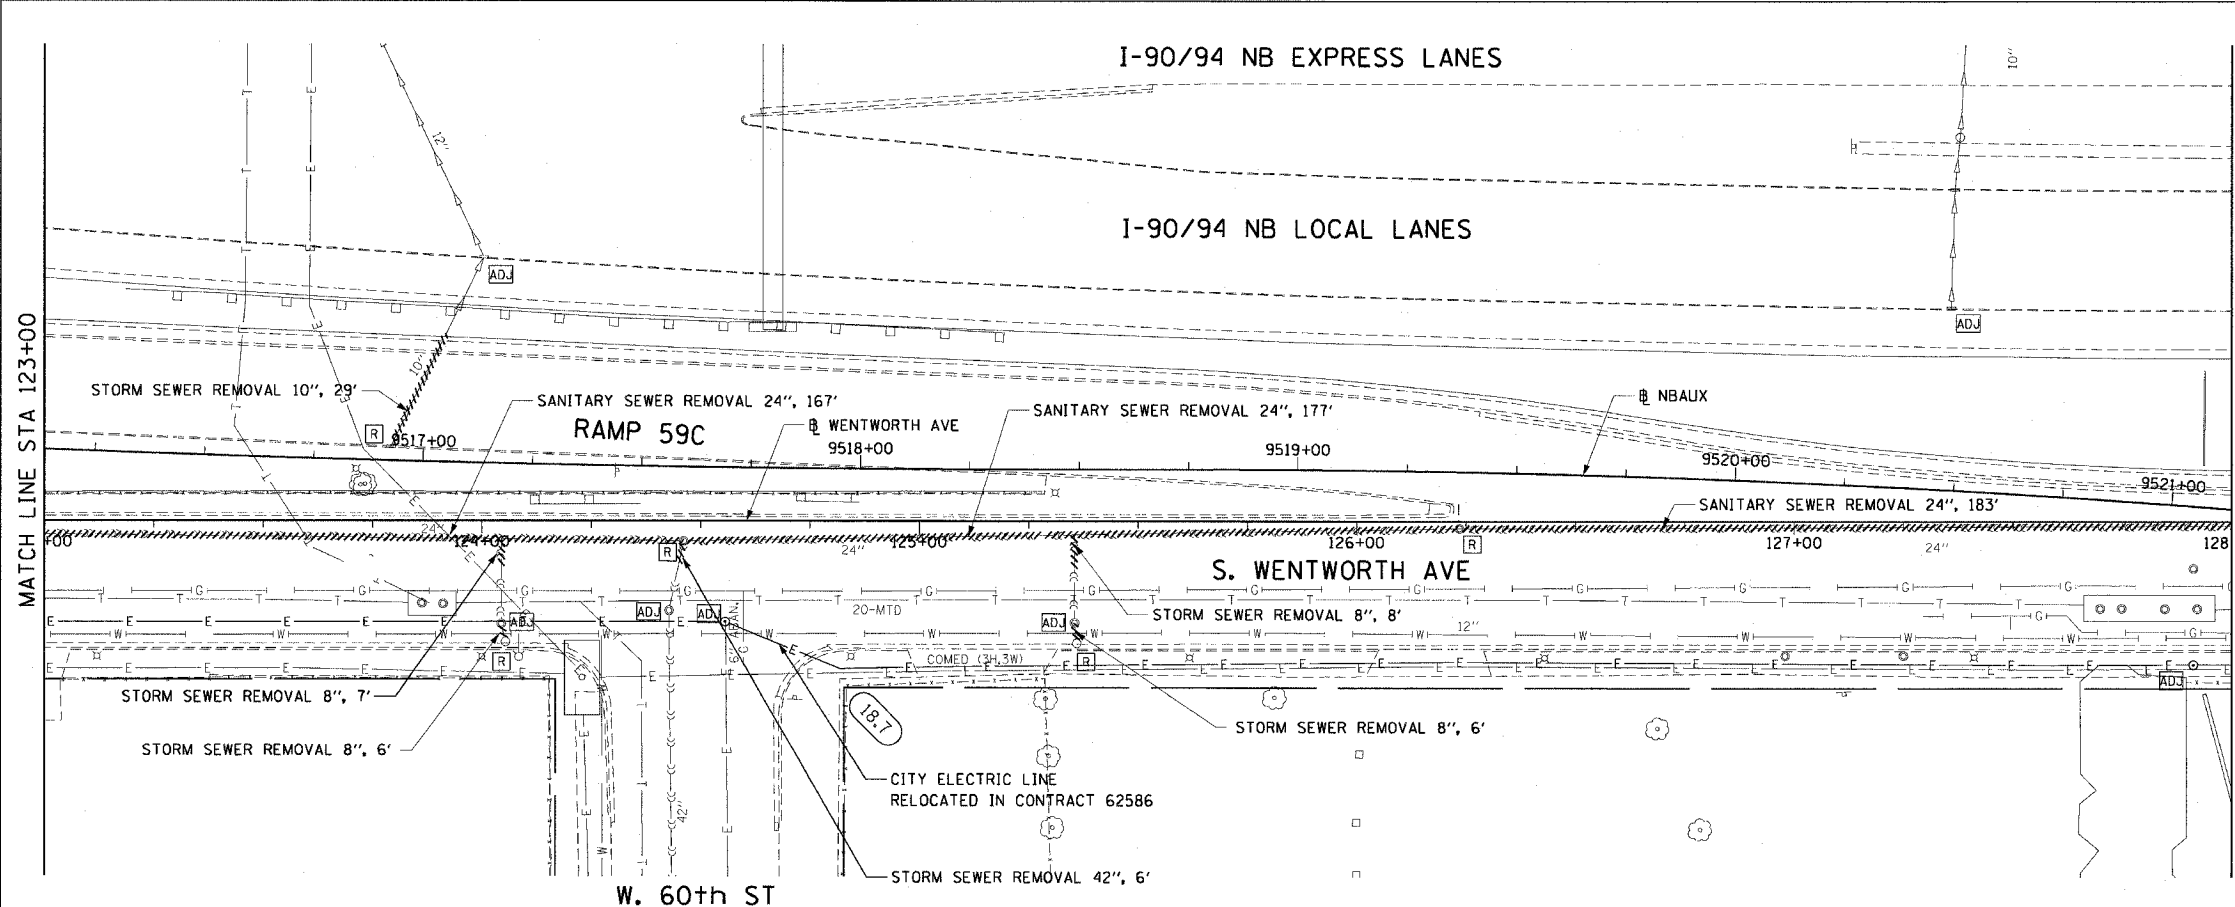

LEGEND: EXISTING

- INLET
- CATCH BASIN
- MANHOLE
- STORM SEWER
- COMBINED SEWER
- PIPE UNDERDRAIN
- [R] STRUCTURE TO BE REMOVED
- [ADJ] STRUCTURE TO BE ADJUSTED
- //// STORM SEWER REMOVAL OR ABANDON
- //// COMBINED SEWER REMOVAL OR ABANDON

EXISTING CONDITIONS AND REMOVAL


PROPOSED IMPROVEMENTS

LEGEND: PROPOSED

- INLET
- CATCH BASIN
- MANHOLE
- STORM SEWER
- COMBINED SEWER
- PIPE UNDERDRAIN
- PROPOSED SWALE
- (EA 01) PROPOSED STORM SEWER PIPE
- △(EA 01) PROPOSED STRUCTURE
- CITY ELECTRIC HANDHOLE

NOTES:

- SEE DRAINAGE SCHEDULES FOR STRUCTURE, PIPE AND UNDERDRAIN INFORMATION.

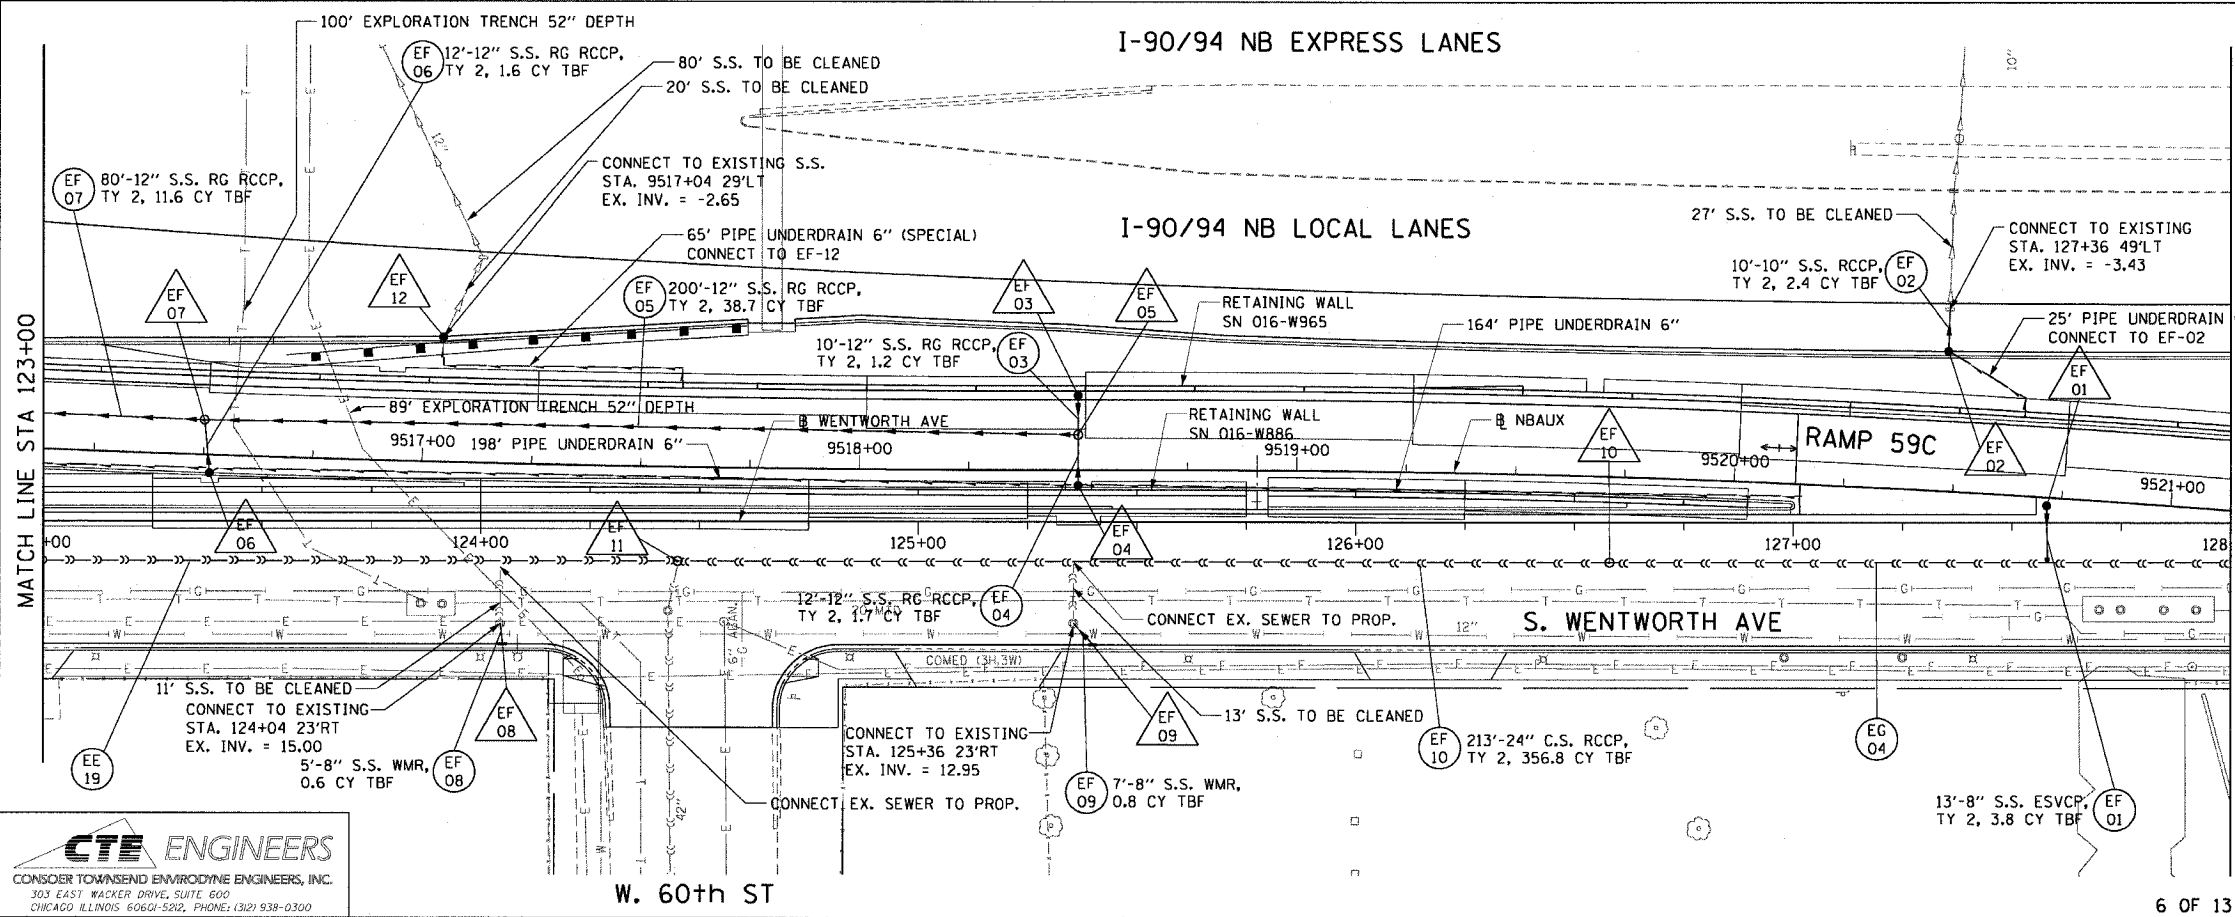

REVISIONS

NAME	DATE

ILLINOIS DEPARTMENT OF TRANSPORTATION
F.A.I. 90/94 (DAN RYAN EXPRESSWAY)
63rd ST TO 59th ST (FRONTAGE ROAD & RAMPS)

**DRAINAGE AND UTILITY PLANS
WENTWORTH AVENUE**

SCALE: 1"=20'
DATE: October 29, 2004

DRAWN BY: JB
CHECKED BY: EEY

CTE ENGINEERS
CONSIDER TOWNSEND ENVIRONMENTAL ENGINEERS, INC.
303 EAST WACKER DRIVE, SUITE 600
CHICAGO, ILLINOIS 60601-5202, PHONE: (312) 938-0300