
 
 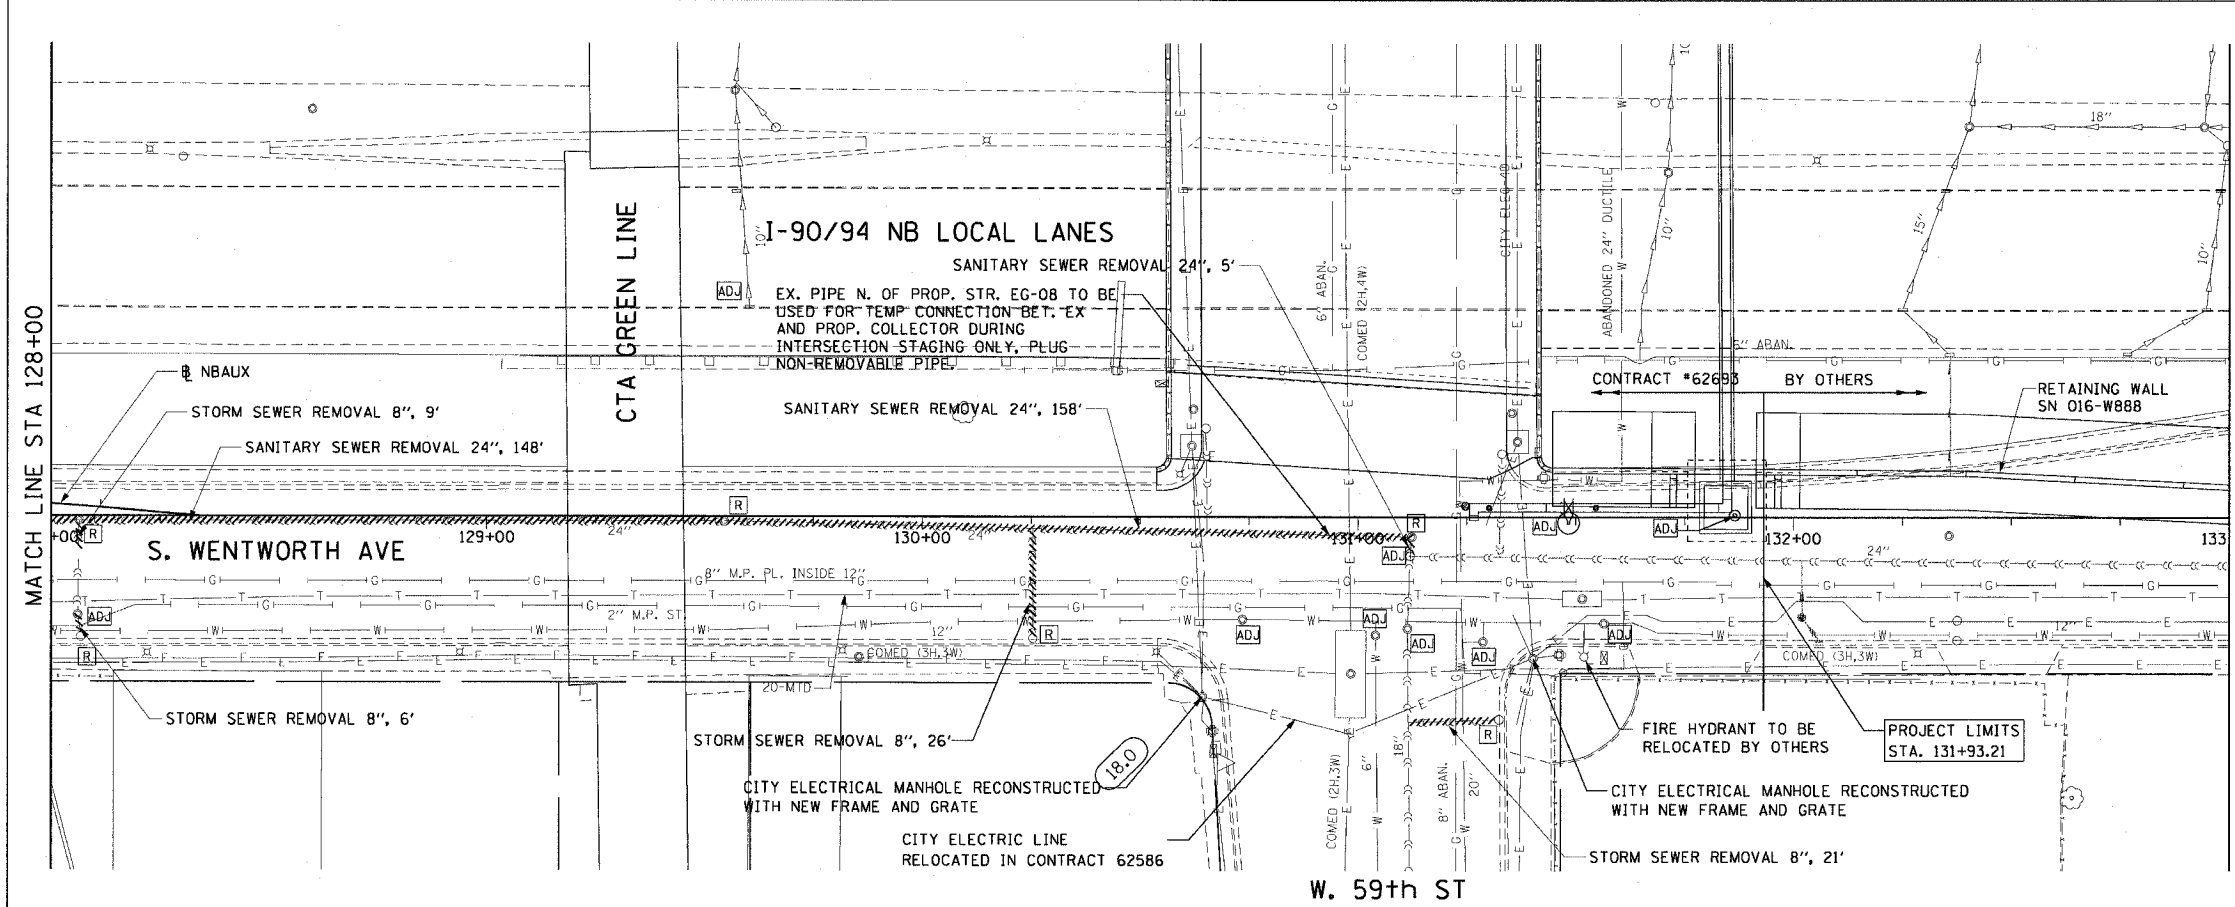



F.A.I. RTE.	SECTION	COUNTY	TOTAL SHEETS	SHEET NO.
90/94	2021-922PT.1-AC	COOK	460	89
STA. 128+00	TO STA. 133+00			
FED. ROAD DIST. NO. 1		ILLINOIS	FED. AID PROJECT	
62693				



- LEGEND: EXISTING**
- INLET
 - CATCH BASIN
 - MANHOLE
 - STORM SEWER
 - COMBINED SEWER
 - PIPE UNDERDRAIN
 - [R] STRUCTURE TO BE REMOVED
 - [AD] STRUCTURE TO BE ADJUSTED
 - //// STORM SEWER REMOVAL OR ABANDON
 - //// COMBINED SEWER REMOVAL OR ABANDON

EXISTING CONDITIONS AND REMOVAL
PROPOSED IMPROVEMENTS

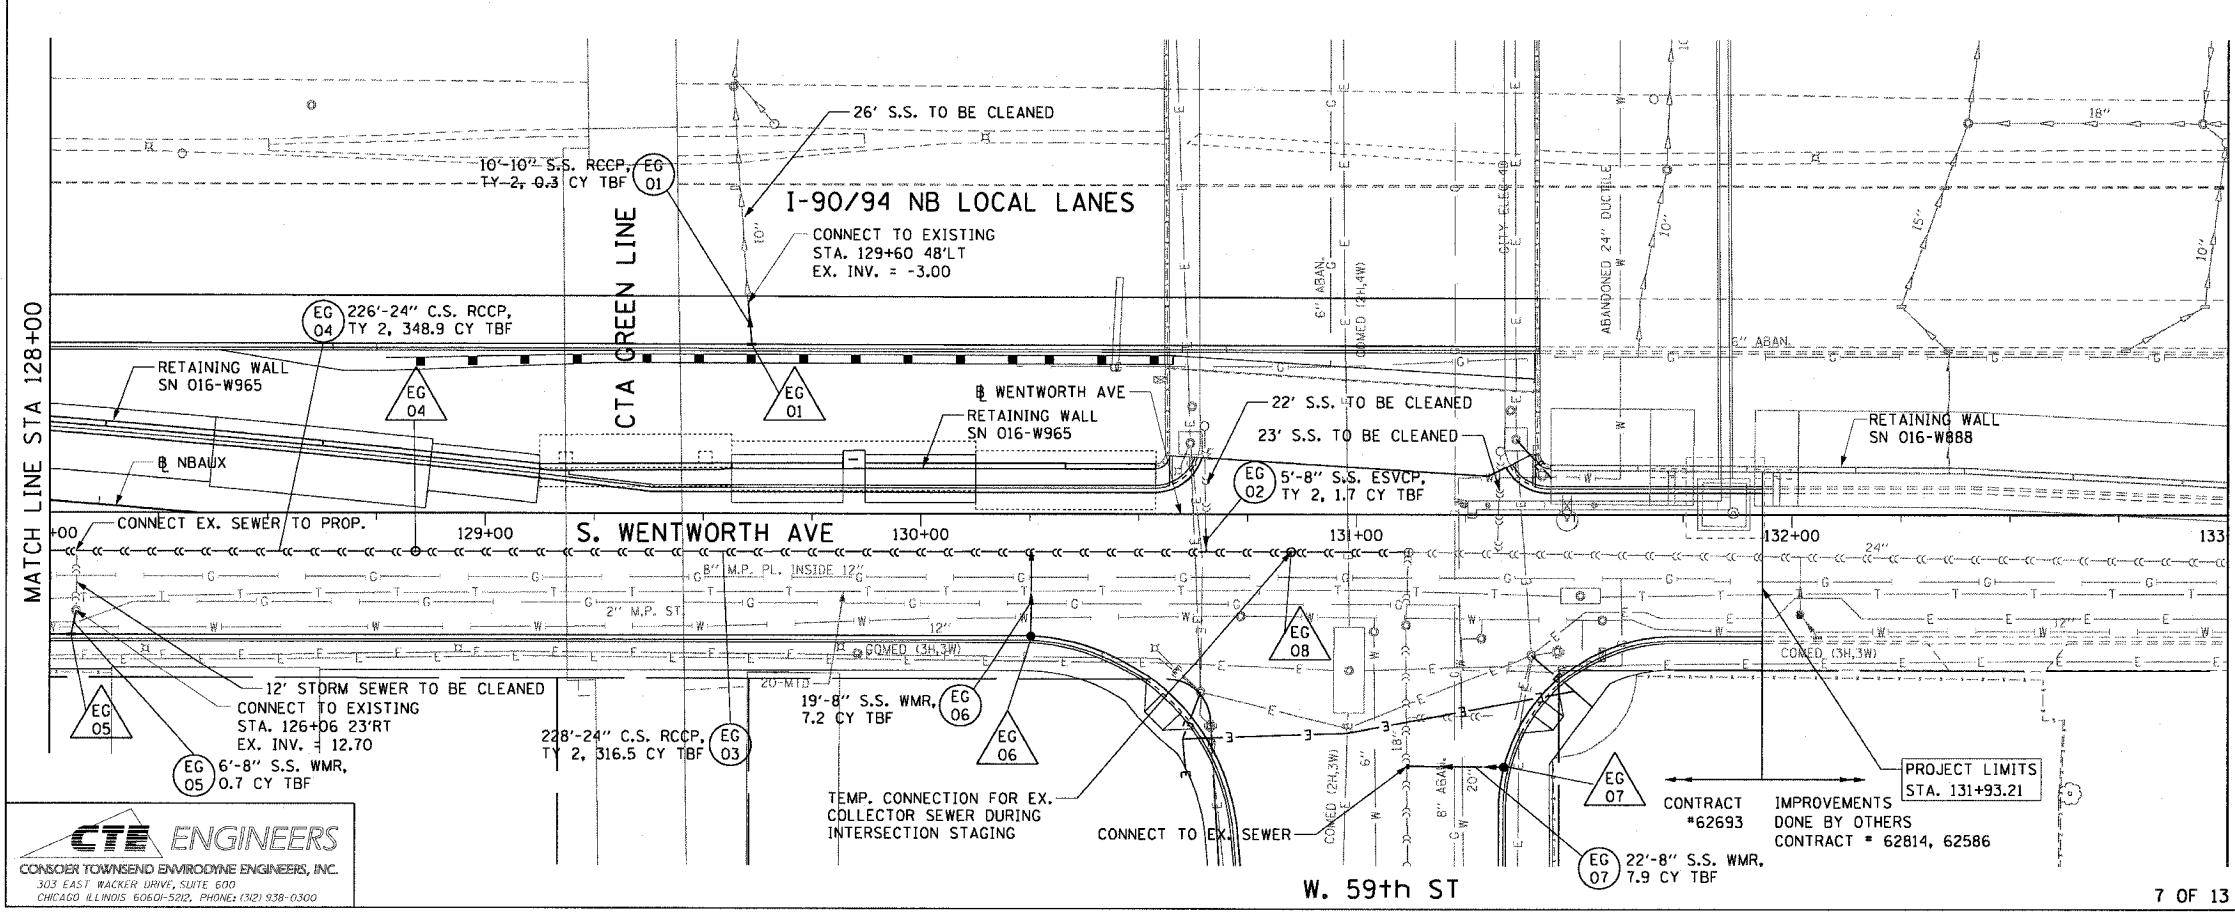

- LEGEND: PROPOSED**
- INLET
 - CATCH BASIN
 - MANHOLE
 - STORM SEWER
 - COMBINED SEWER
 - PIPE UNDERDRAIN
 - PROPOSED SWALE
 - EA 01 PROPOSED STORM SEWER PIPE
 - △ EA 01 PROPOSED STRUCTURE
 - CITY ELECTRIC HANDHOLE

NOTES:
1. SEE DRAINAGE SCHEDULES FOR STRUCTURE, PIPE AND UNDERDRAIN INFORMATION.

REVISIONS	
NAME	DATE

ILLINOIS DEPARTMENT OF TRANSPORTATION
F.A.I. 90/94 (DAN RYAN EXPRESSWAY)
63rd ST TO 59th ST (FRONTAGE ROAD & RAMPS)

DRAINAGE AND UTILITY PLANS
WENTWORTH AVENUE

SCALE: 1"=20'
DATE: October 29, 2004

DRAWN BY: JB
CHECKED BY: EBY

CTE ENGINEERS
CONSIDER TOWNSEND ENVIRONMENTAL ENGINEERS, INC.
303 EAST WACKER DRIVE, SUITE 600
CHICAGO, ILLINOIS 60601-5202, PHONE: (312) 938-0300

17/22/2004 02:57:59 PM