


- LEGEND: EXISTING**
- INLET
  - CATCH BASIN
  - MANHOLE
  - STORM SEWER
  - COMBINED SEWER
  - PIPE UNDERDRAIN
  - [R] STRUCTURE TO BE REMOVED
  - [AD] STRUCTURE TO BE ADJUSTED
  - //// STORM SEWER REMOVAL OR ABANDON
  - //// COMBINED SEWER REMOVAL OR ABANDON

**EXISTING CONDITIONS AND REMOVAL**  
**PROPOSED IMPROVEMENTS**

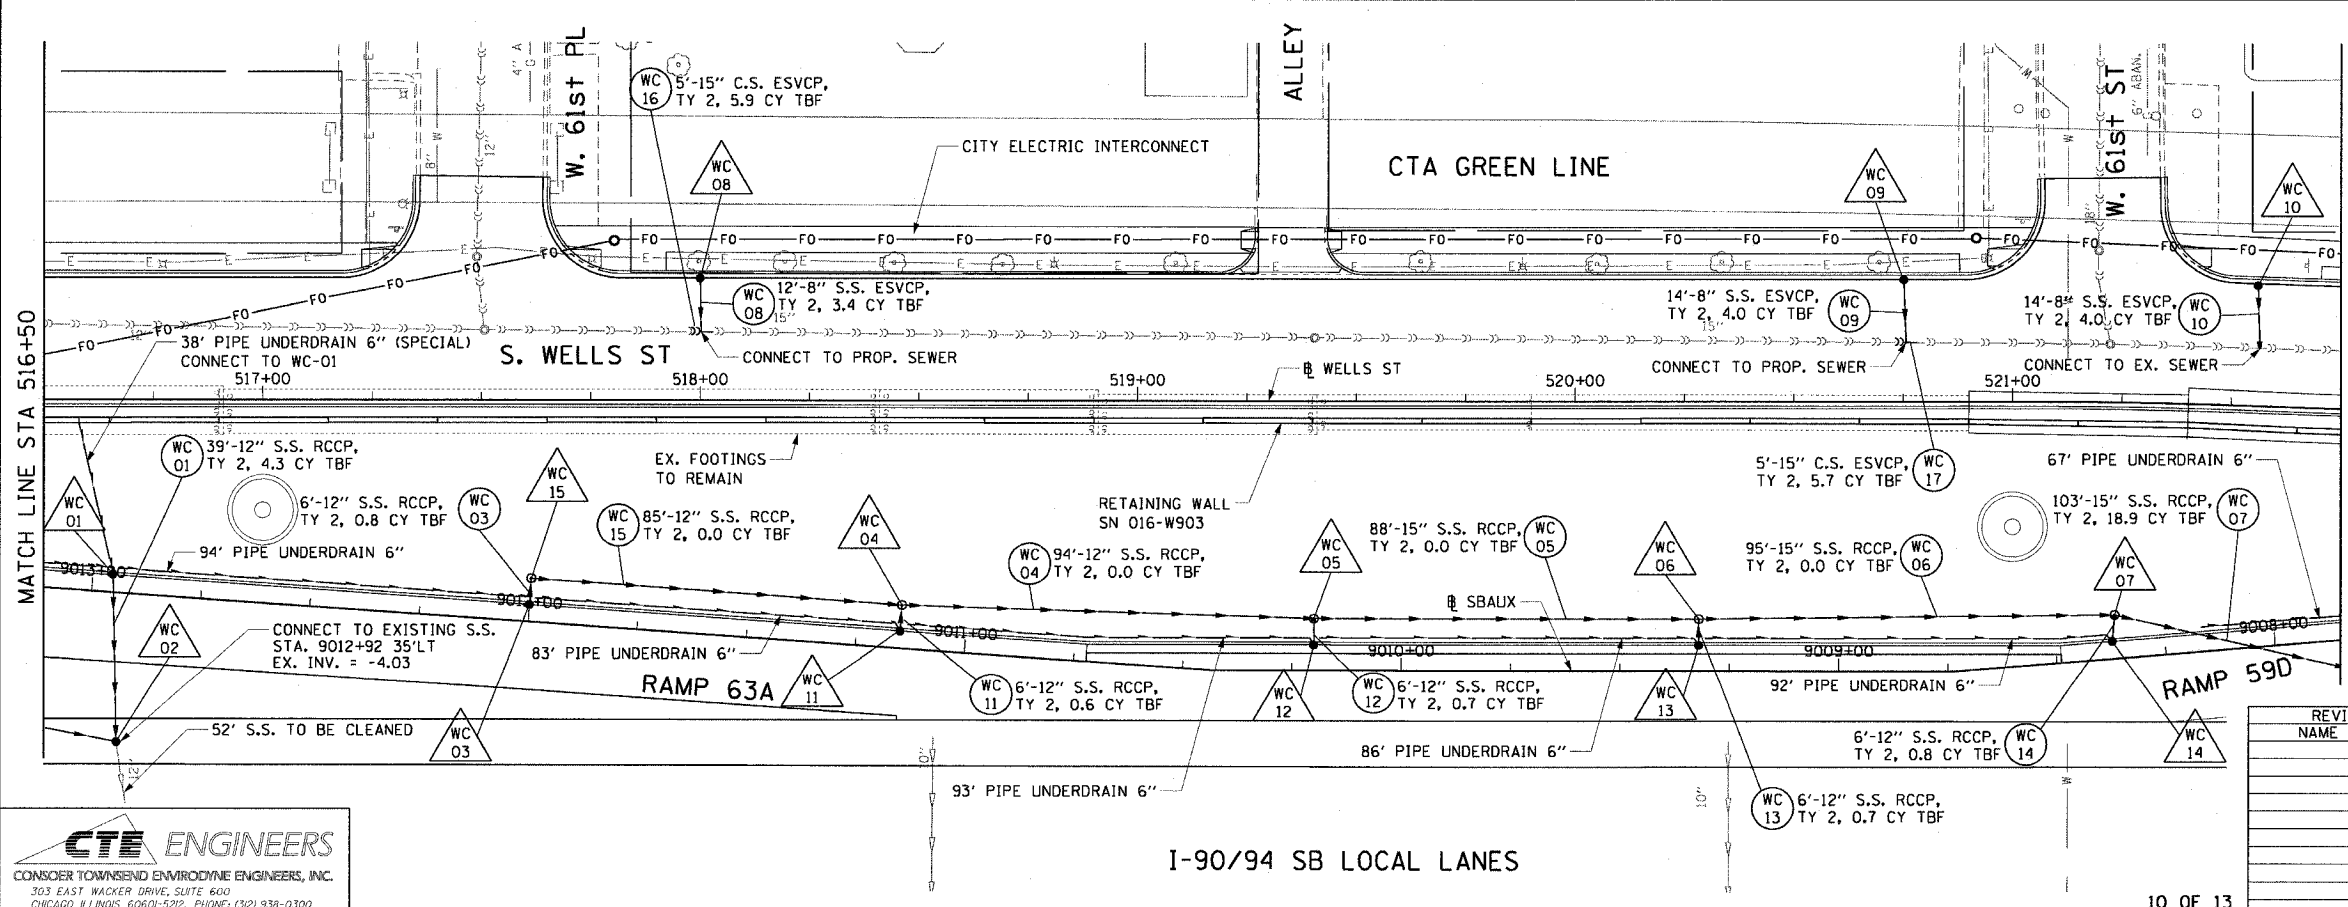

- LEGEND: PROPOSED**
- INLET
  - CATCH BASIN
  - MANHOLE
  - STORM SEWER
  - COMBINED SEWER
  - PIPE UNDERDRAIN
  - PROPOSED SWALE
  - (EA 01) PROPOSED STORM SEWER PIPE
  - △(EA 01) PROPOSED STRUCTURE
  - CITY ELECTRIC HANDHOLE

- NOTES:**
- SEE DRAINAGE SCHEDULES FOR STRUCTURE, PIPE AND UNDERDRAIN INFORMATION.
  - SEE INTERCONNECT CONDUIT PLANS FOR CITY ELECTRIC INTERCONNECT IMPROVEMENTS.

REVISIONS	
NAME	DATE

ILLINOIS DEPARTMENT OF TRANSPORTATION  
F.A.I. 90/94 (DAN RYAN EXPRESSWAY)  
63rd ST TO 59th ST (FRONTAGE ROAD & RAMPS)

**DRAINAGE AND UTILITY PLANS  
WELLS STREET**

SCALE: 1"=20'  
DATE: October 29, 2004

DRAWN BY: JB  
CHECKED BY: EY

11/22/2004 02:36:18 PM