


F.A.I. RTE.	SECTION	COUNTY	TOTAL SHEETS	SHEET NO.
90/94	2004-065TS	COOK	62	29
STA. -		TO STA. -		
FED. ROAD DIST. NO. 1 ILLINOIS FED. AID PROJECT				


62804

NOTES:

- SEE DRAWING E-1 AND E-2 FOR CDOT ELECTRICAL GENERAL NOTES, SYMBOLS AND ABBREVIATIONS.
- SEE TEMPORARY LIGHTING PLANS FOR LOCATIONS OF THE TEMPORARY LIGHTING UNITS AND ROUTING OF THE TEMPORARY AERIAL CABLES.
- TEMPORARY LUMINAIRE WILL BE INCLUDED FOR PAYMENT UNDER THE "LUMINAIRE, SODIUM VAPOR, HORIZONTAL MOUNT, TYPE MC III, 400 WATT" PAY ITEM.
- TEMPORARY MAST ARM WILL BE INCLUDED FOR PAYMENT UNDER THE "MAST ARM, STEEL, 12 FT." PAY ITEM. SEE DRAWING BOE-24 FOR BOE LIGHTING MAST ARM DETAILS.
- ALL HARDWARE REQUIRED TO MOUNT THE TEMPORARY MAST ARM TO THE WOOD POLE WILL BE INCLUDED FOR PAYMENT UNDER THE "MAST ARM, STEEL, 12 FT." PAY ITEM.
- ALL HARDWARE REQUIRED TO MOUNT THE TEMPORARY AERIAL CABLES TO THE WOOD POLE WILL BE INCLUDED FOR PAYMENT UNDER THE "AERIAL CABLE WITH MESSENGER WIRE, 2-1/2 NO.4" PAY ITEM.
- ALL HARDWARE REQUIRED TO PROVIDE POWER TO THE TEMPORARY LUMINAIRE FROM THE TEMPORARY LIGHTING CIRCUIT AERIAL CABLES WILL BE INCLUDED FOR PAYMENT UNDER THE "LUMINAIRE, SODIUM VAPOR, HORIZONTAL MOUNT, TYPE MC III, 400 WATT" PAY ITEM.

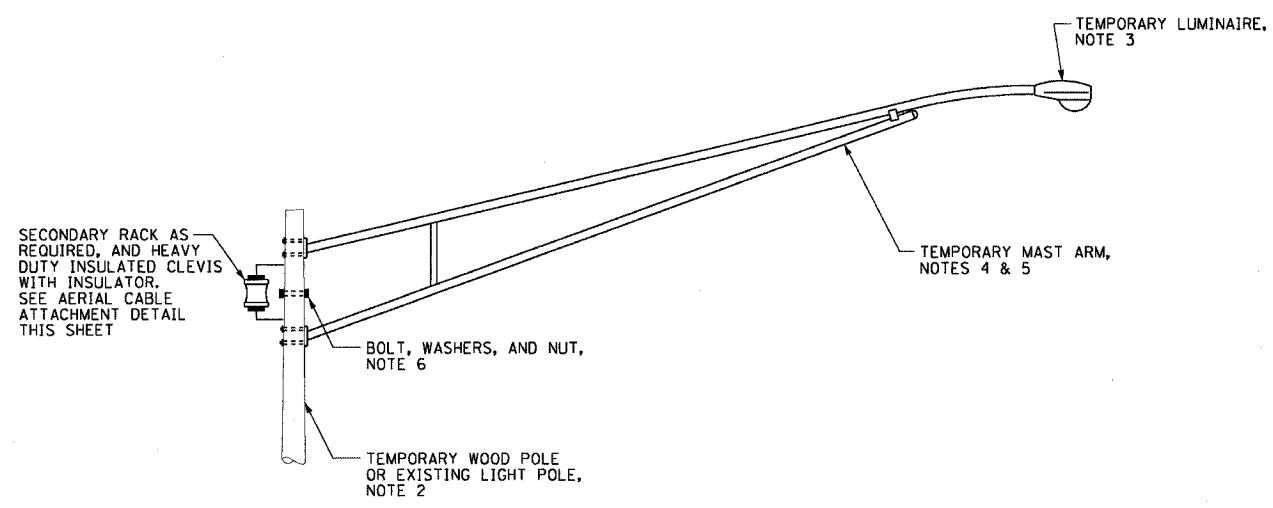


AERIAL CABLE TO TEMPORARY LIGHTING UNIT INSTALLATION DETAIL
NOT TO SCALE

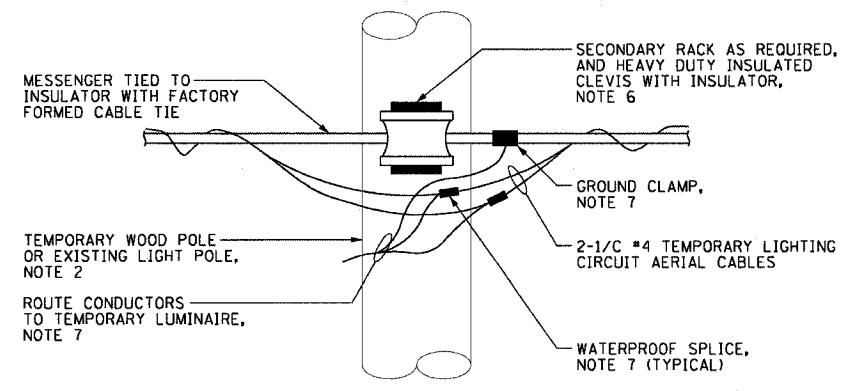

AERIAL CABLE ATTACHMENT DETAIL
NOT TO SCALE

DRAWING PROVIDED FOR INFORMATION ONLY

 E-14



REVISIONS	
NAME	DATE

ILLINOIS DEPARTMENT OF TRANSPORTATION
F.A.I. 90/94 (DAN RYAN EXPRESSWAY)
TRAFFIC SIGNALS AT 47TH STREET WITH
WENTWORTH AVENUE - LASALLE STREET AND
WELLS STREET - WENTWORTH AVENUE
TEMPORARY LIGHTING DETAILS

SCALE: AS SHOWN DRAWN BY: HAR
DATE: October 29, 2004 CHECKED BY: WDS

10/27/2004 08:55:36 AM