



F.A.I. RTE.	SECTION	COUNTY	TOTAL SHEETS	SHEET NO.
90/94	2004-098TS	COOK	63	30
STA. -	TO STA. -			
FED. ROAD DIST. NO. 1	ILLINOIS	FED. AID PROJECT		
62839				

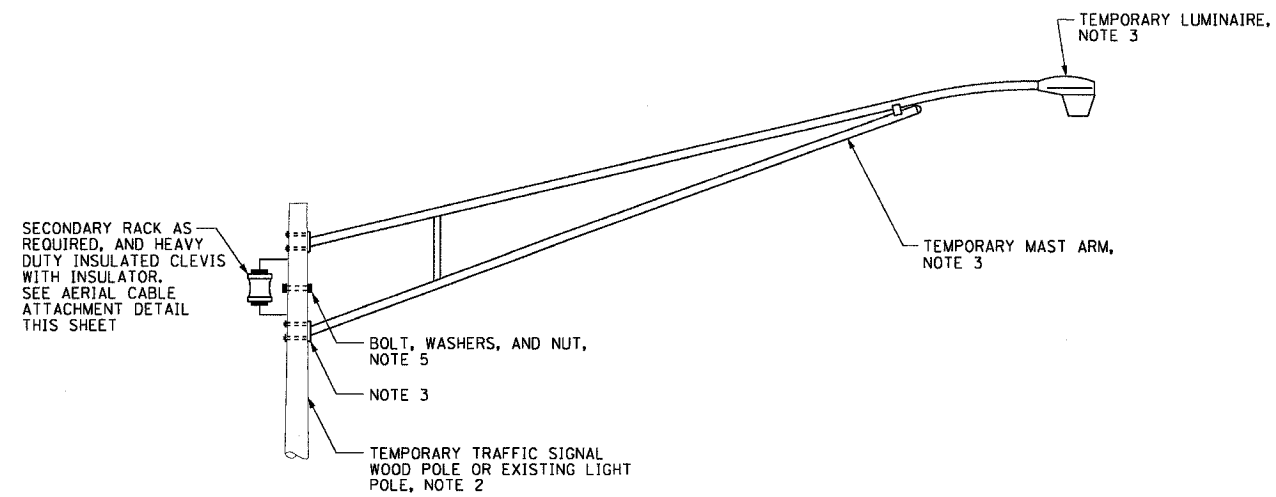

**AERIAL CABLE TO TEMPORARY LIGHTING UNIT INSTALLATION DETAIL**  
NOT TO SCALE

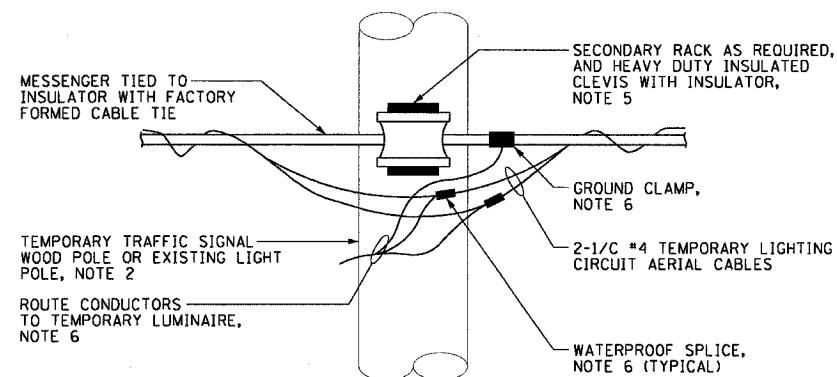

**AERIAL CABLE ATTACHMENT DETAIL**  
NOT TO SCALE

**NOTES:**

- SEE DRAWING E-1 AND E-2 FOR CDOT ELECTRICAL GENERAL NOTES, SYMBOLS AND ABBREVIATIONS.
- SEE TEMPORARY LIGHTING PLANS FOR LOCATIONS OF THE TEMPORARY LIGHTING UNITS AND ROUTING OF THE TEMPORARY AERIAL CABLES.
- TEMPORARY MAST ARM, LUMINAIRE, AND ALL HARDWARE REQUIRED TO MOUNT THE TEMPORARY MAST ARM TO THE POLE WILL BE INCLUDED FOR PAYMENT UNDER THE "TEMPORARY LIGHTING UNIT" PAY ITEM.
- SEE DRAWING BOE-24 FOR BOE LIGHTING MAST ARM DETAILS.
- ALL HARDWARE REQUIRED TO MOUNT THE TEMPORARY AERIAL CABLES TO THE WOOD POLE WILL BE INCLUDED FOR PAYMENT UNDER THE "AERIAL CABLE WITH MESSENGER WIRE, 2-1/2 NO.4" PAY ITEM.
- ALL HARDWARE REQUIRED TO PROVIDE POWER TO THE TEMPORARY LUMINAIRE FROM THE TEMPORARY LIGHTING CIRCUIT AERIAL CABLES WILL BE INCLUDED FOR PAYMENT UNDER THE "TEMPORARY LIGHTING UNIT" PAY ITEM.

E-14

REVISIONS	
NAME	DATE

ILLINOIS DEPARTMENT OF TRANSPORTATION  
F.A.I. 90/94 (DAN RYAN EXPRESSWAY)  
TRAFFIC SIGNALS AT 59TH STREET AND  
WENTWORTH AVENUE / WELLS STREET  
**TEMPORARY LIGHTING DETAILS**

SCALE: AS SHOWN  
DATE: November 12, 2004

DRAWN BY: HAR  
CHECKED BY: WDS