



• PARK ROADS
 ** OAK RIDGE CEMETERY INTERNAL ROADS 2003
 CONTRACT NO. 72774

LIGHTING FIXTURE SCHEDULE

TAG	DESCRIPTION	LAMPS
F1	MODEL #IGCOMLGT03 (AS MANUFACTURED BY EAGLE MOUNTAIN)-120 V IN-GROUND COMMERCIAL LIGHTING FIXTURE / LAMP WITH BALLAST (6 EACH) OR EQUIVALENT.	175 WATT METAL HALIDE

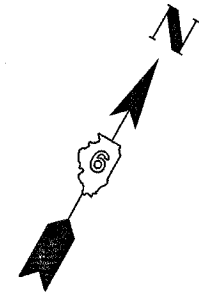

LINCOLN MEMORIAL DRIVE

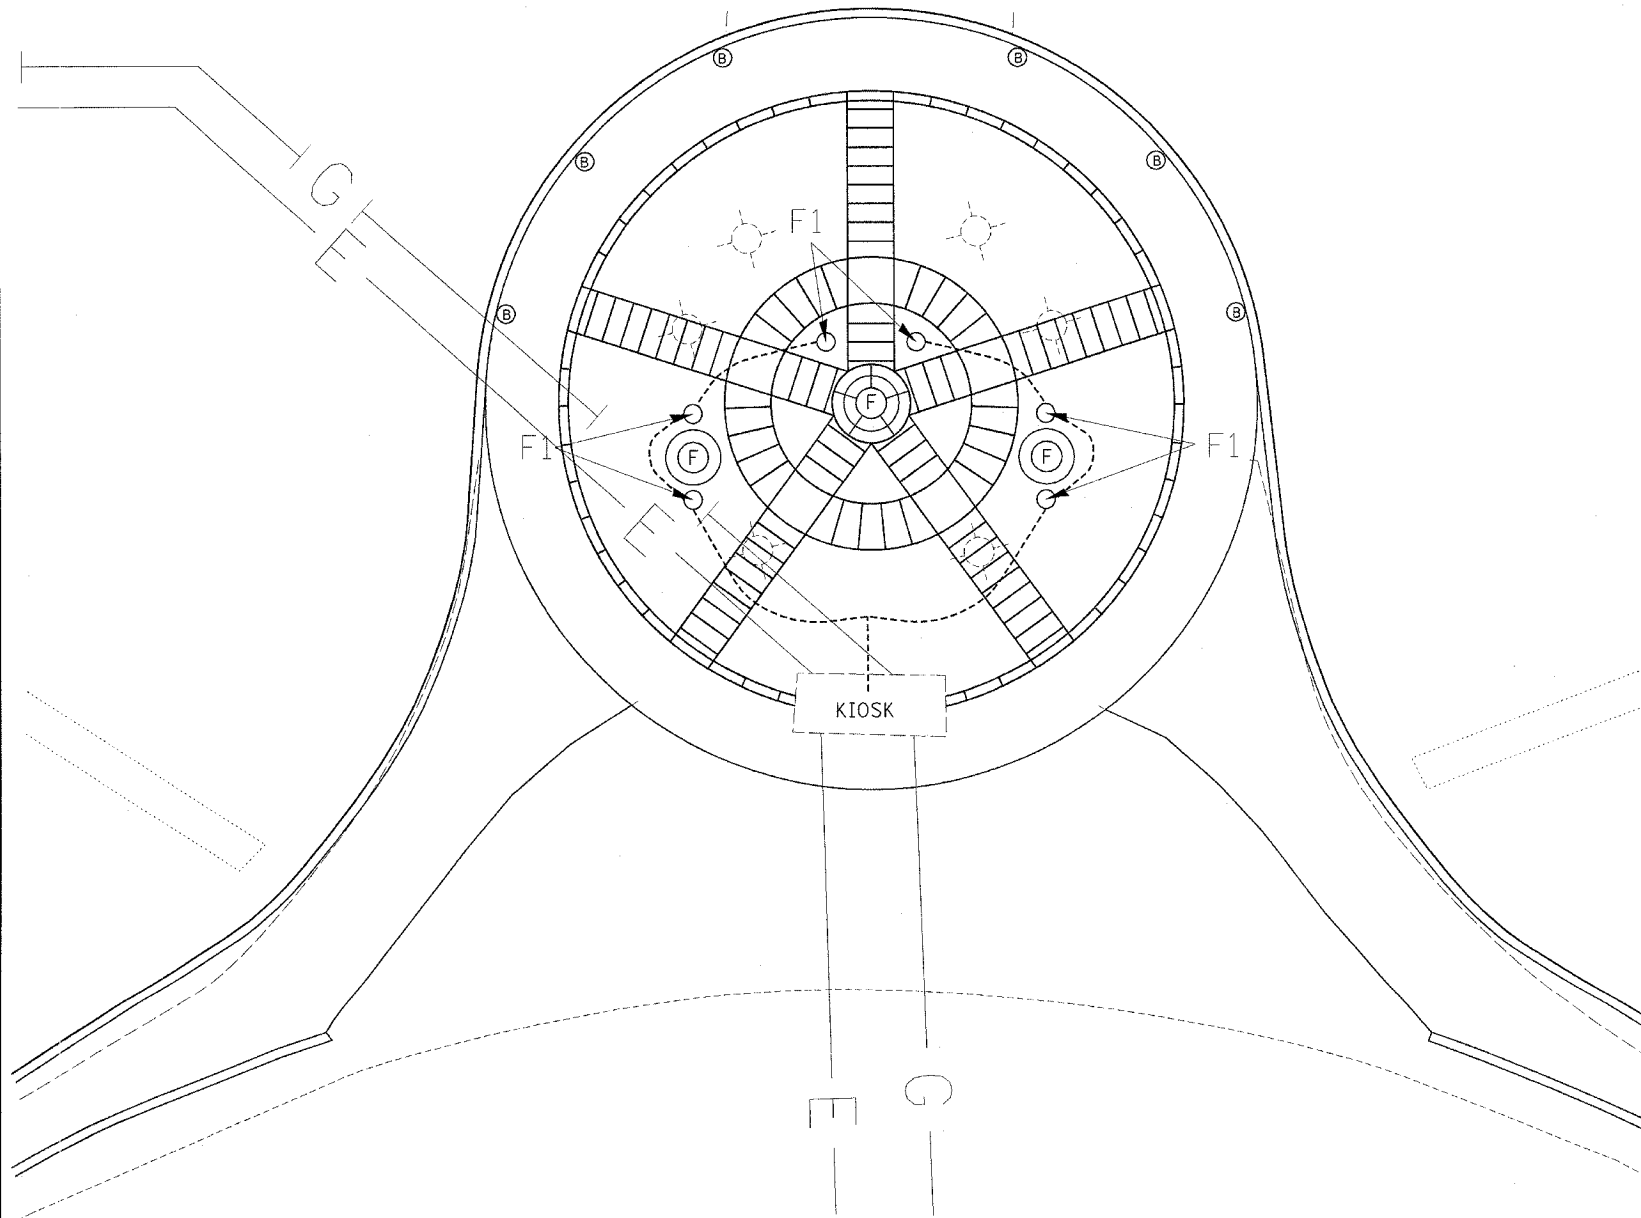

ELECTRICAL SYMBOL LIST

- MODEL #IGCOMLGT03 -120 V IN-GROUND COMMERCIAL LIGHTING FIXTURE / LAMP WITH BALLAST. 175 WATT METAL HALIDE (6 EACH) OR EQUIVALENT.
- ☼ EXISTING LIGHTING FIXTURE TO BE REMOVED AND SALVAGED. (6 EACH)
- CONDUIT CONCEALED UNDERGROUND.
- E- ELECTRIC SERVICE UNDERGROUND CONCEALED IN 2" PVC CONDUIT.
- (B) PROPOSED BOLLARD
- (F) FLAGPOLE (TO REMAIN IN PLACE)

NOTES: THE ELECTRICAL CONTRACTOR SHALL PROVIDE THE MAINTENANCE PERSONNEL AT OAK RIDGE CEMETERY WITH TWO ADDITIONAL LAMPS PER FIXTURE WITH COMPLETE INSTRUCTIONS ON REPLACING LAMPS FOR EACH FIXTURE TYPE.

REVISIONS	
NAME	DATE

ILLINOIS DEPARTMENT OF TRANSPORTATION
LIGHTING DETAIL
 VIETNAM VETERANS MEM.
 FLAGPOLE AREA

SCALE: VERT. _____
 HORIZ. _____
 DATE _____
 DRAWN BY _____
 CHECKED BY _____