


RT.	SECTION	COUNTY	TOTAL SHEETS	SHEET NO.
FAI 80	(50-2)HBR	LA SALLE	460	103
STA. 653+75		TO STA. 663+50		
FED. ROAD DIST. NO.		ILLINOIS FED. AID PROJECT		

CONTRACT NO. 86603

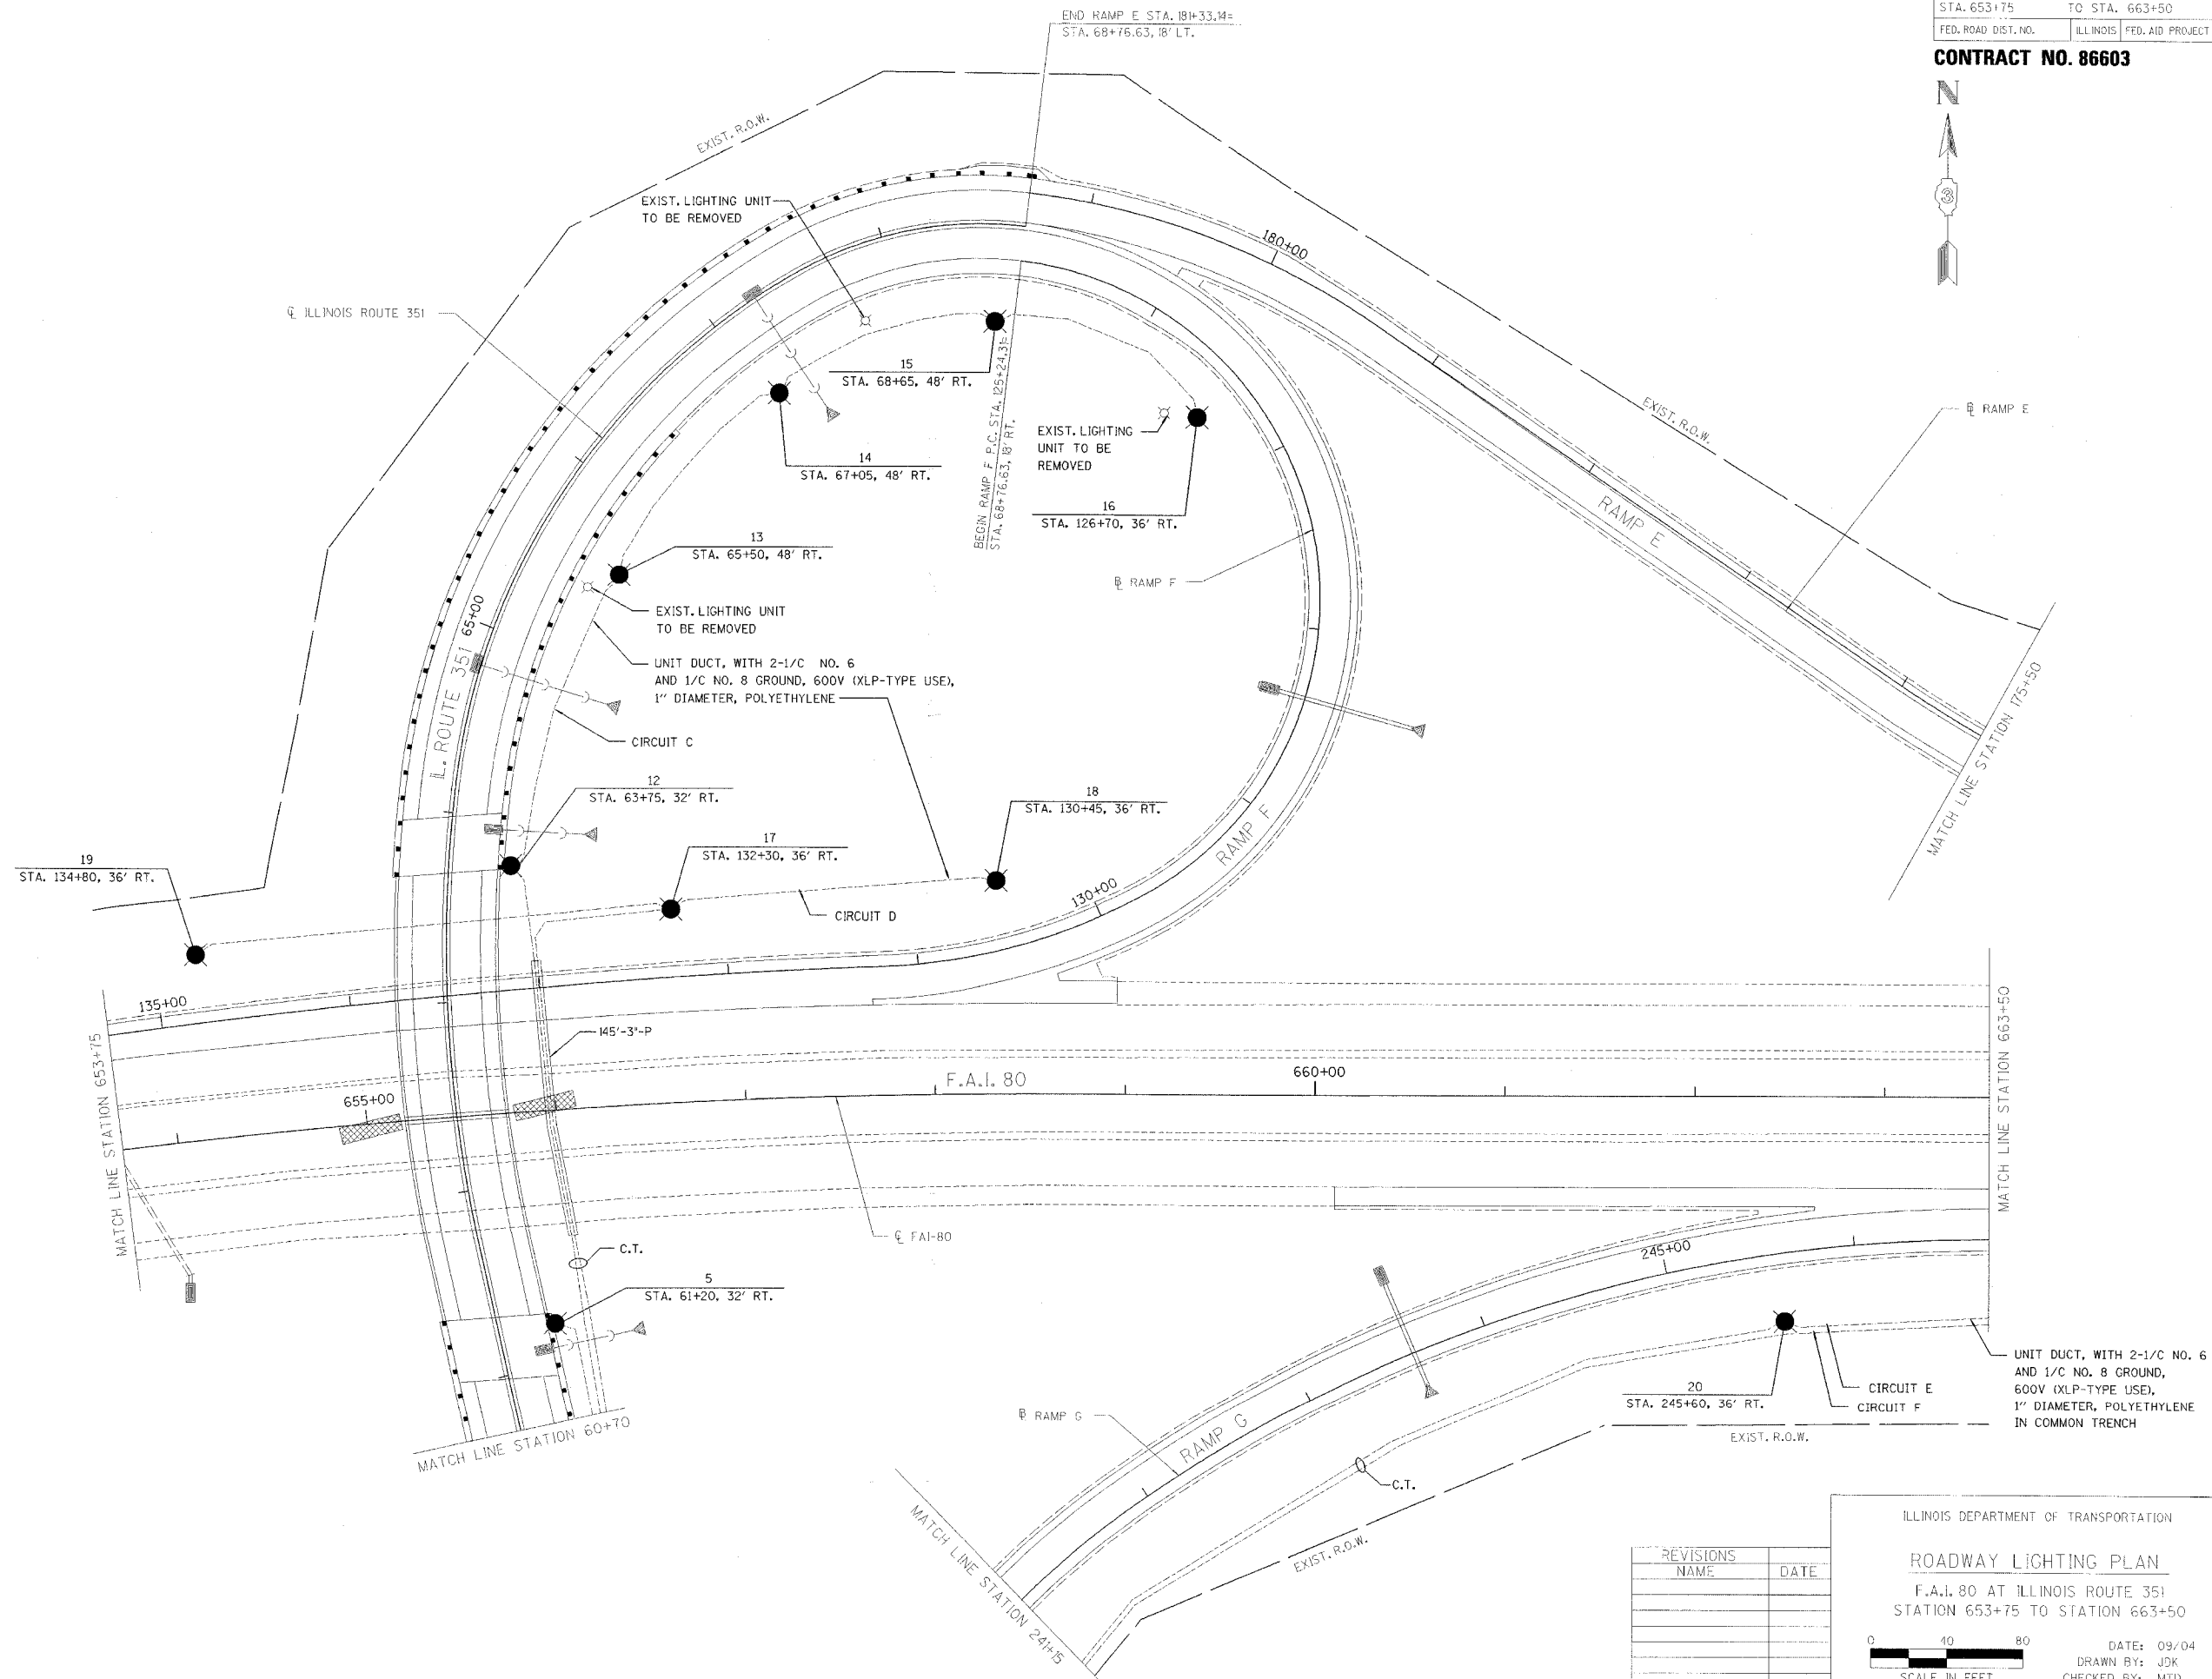

REVISIONS	NAME	DATE

ILLINOIS DEPARTMENT OF TRANSPORTATION
ROADWAY LIGHTING PLAN
 F.A.I. 80 AT ILLINOIS ROUTE 351
 STATION 653+75 TO STATION 663+50

DATE: 09/04
 DRAWN BY: JDK
 CHECKED BY: MTD

0 10 20
 SCALE IN FEET