


|                     |           |               |                  |           |
|---------------------|-----------|---------------|------------------|-----------|
| RT.                 | SECTION   | COUNTY        | TOTAL SHEETS     | SHEET NO. |
| FAI 80              | (50-2)HBR | LA SALLE      | 460              | 105       |
| STA. 260+50         |           | TO STA. 60+70 |                  |           |
| FED. ROAD DIST. NO. |           | ILLINOIS      | FED. AID PROJECT |           |

**CONTRACT NO. 86603**

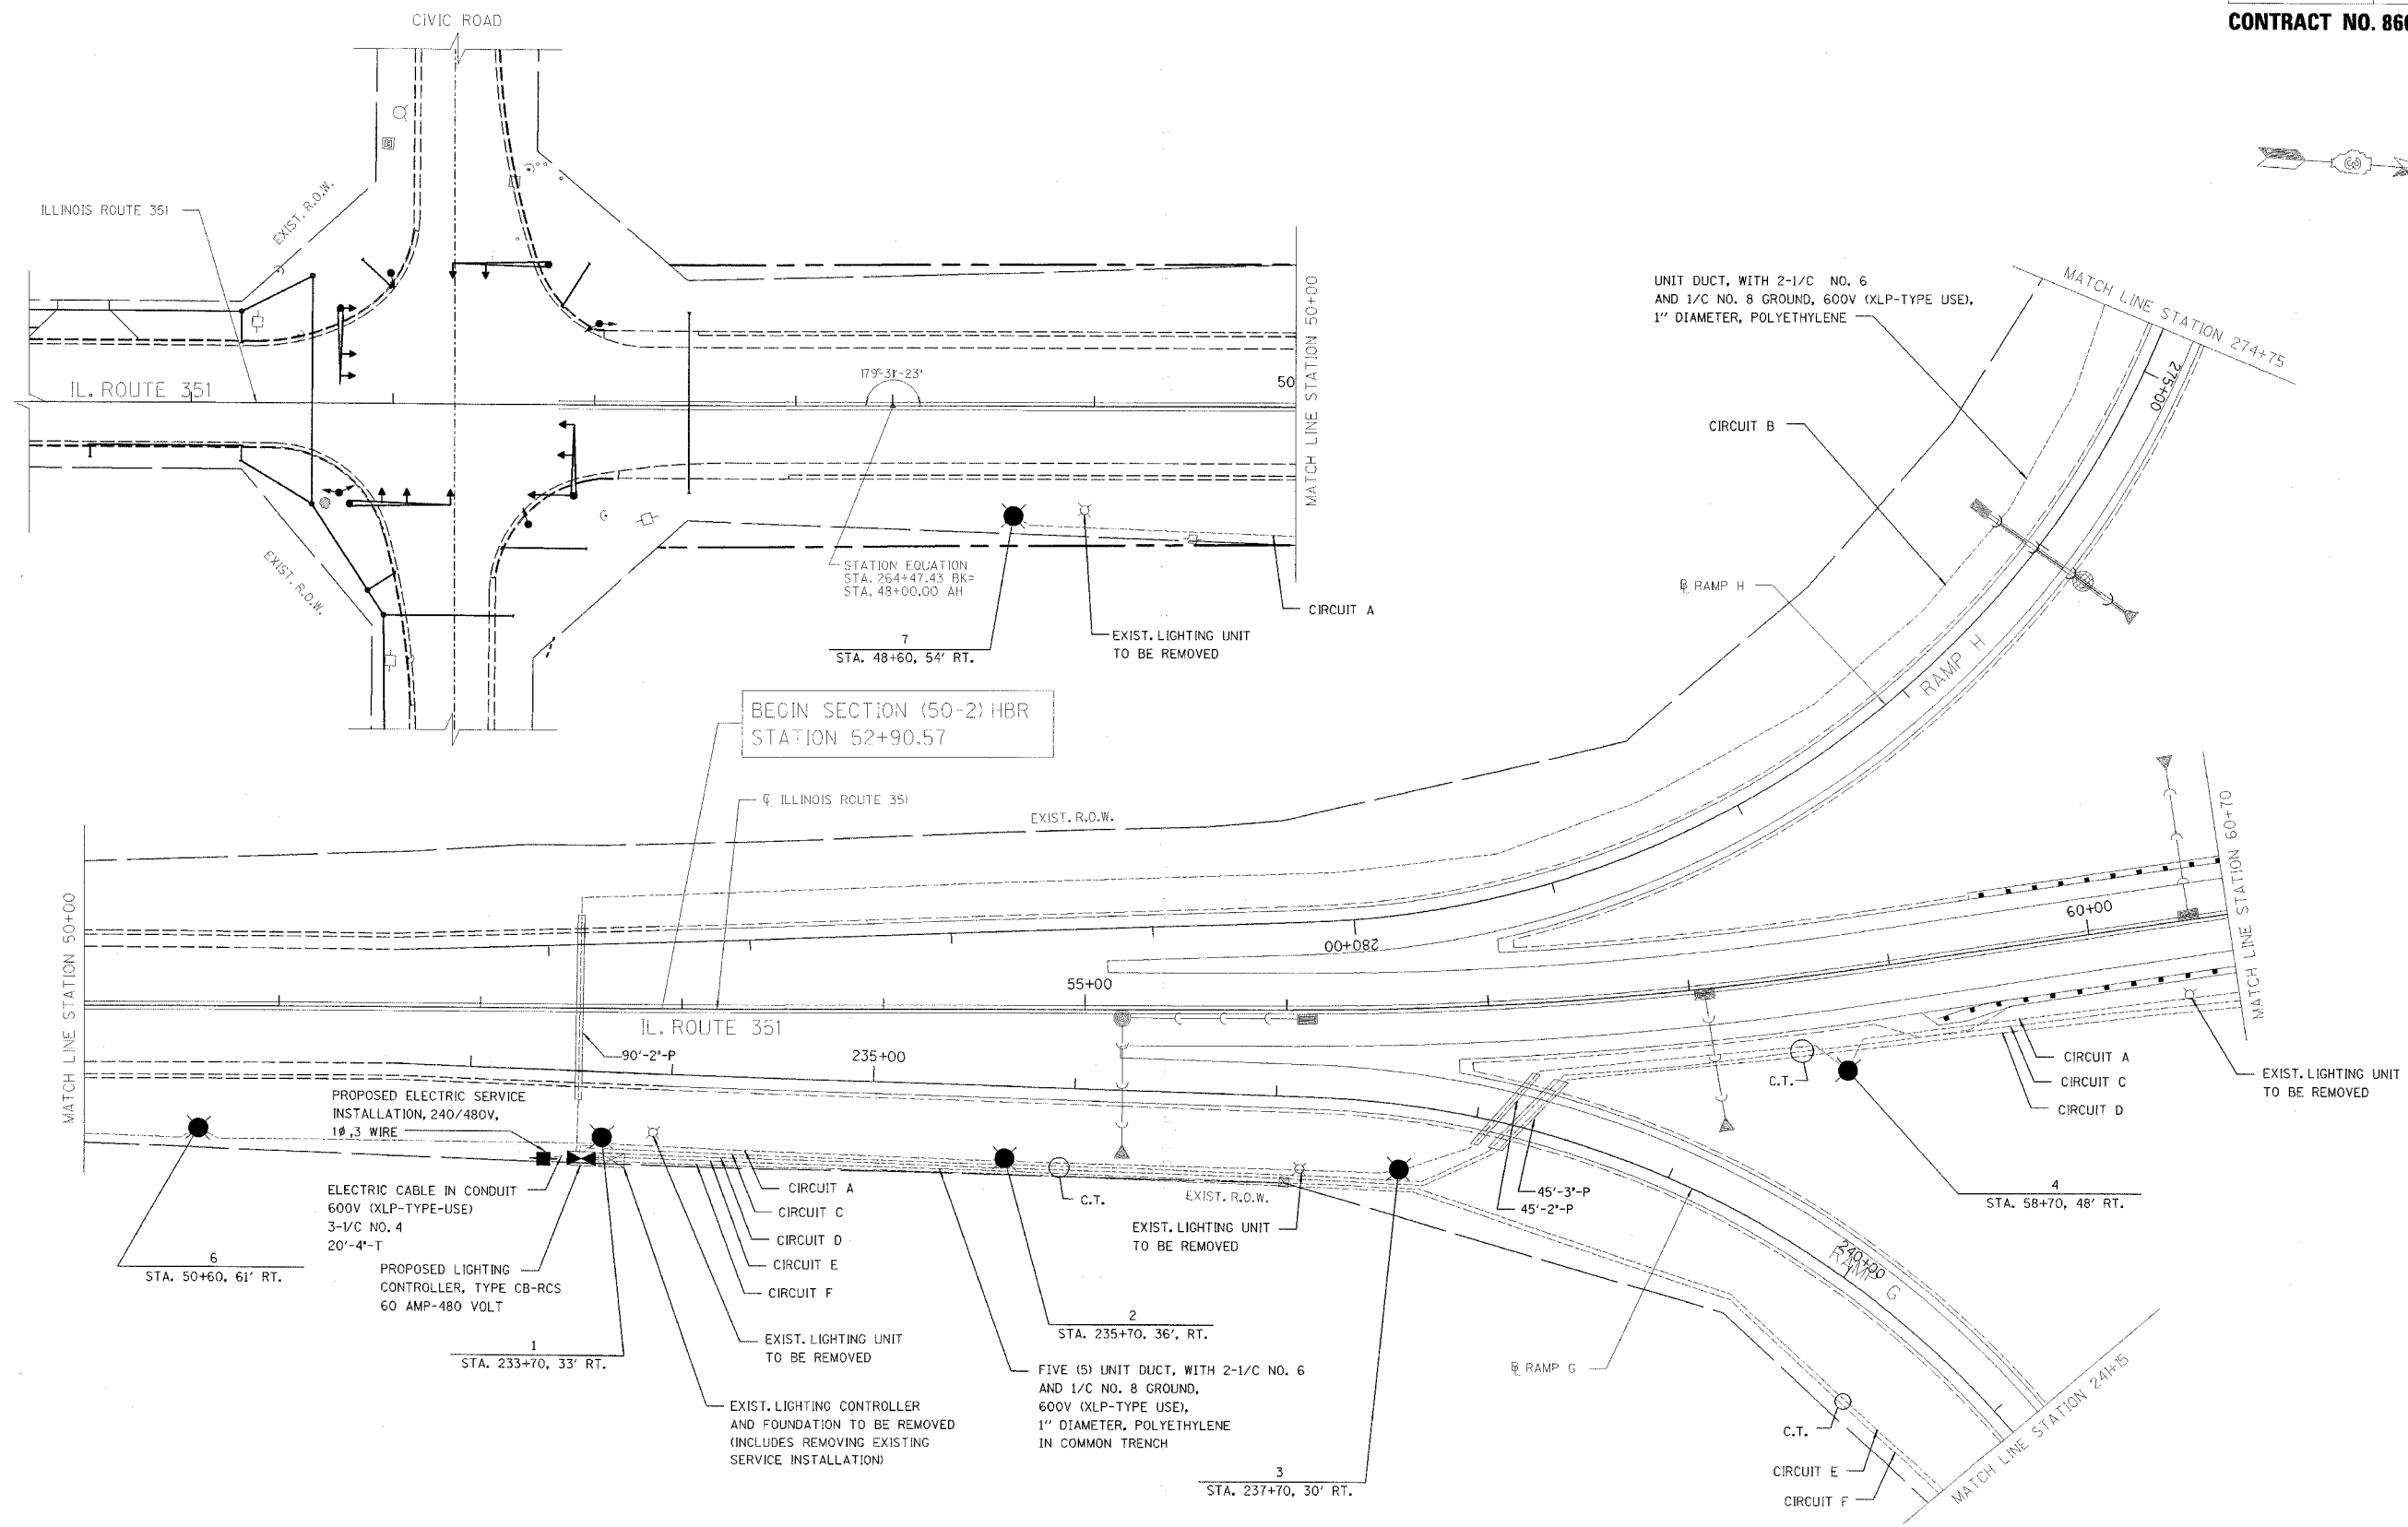

| REVISIONS | NAME | DATE |
|-----------|------|------|
|           |      |      |
|           |      |      |
|           |      |      |
|           |      |      |
|           |      |      |

ILLINOIS DEPARTMENT OF TRANSPORTATION

**ROADWAY LIGHTING PLAN**

F.A.I. 80 AT ILLINOIS ROUTE 351  
STATION 260+50 TO STATION 60+70

DATE: 09/04  
DRAWN BY: JJK  
CHECKED BY: MTD

0 40 80  
SCALE IN FEET