
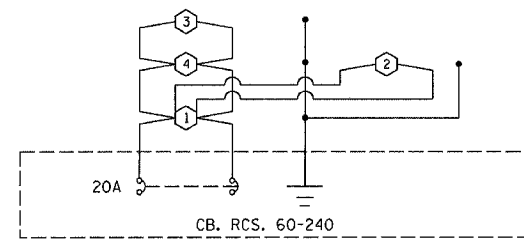



F.A.P. RTE.	SECTION	COUNTY	TOTAL SHEETS	SHEET NO.
774	*	EFFINGHAM	344	113
FED. ROAD DIST. NO. 7 ILLINOIS		FED. AID PROJECT		
*107WRS-1, 107BY, 107BY-1 & 107B-2		CONTRACT NO. 94827		

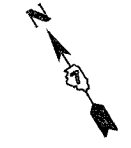

**CONTROL ONE LINE**

**LEGEND:**

- CONDUIT w/GROUND
- CONTROLLER
- LIGHT UNIT-1
- SERVICE POLE

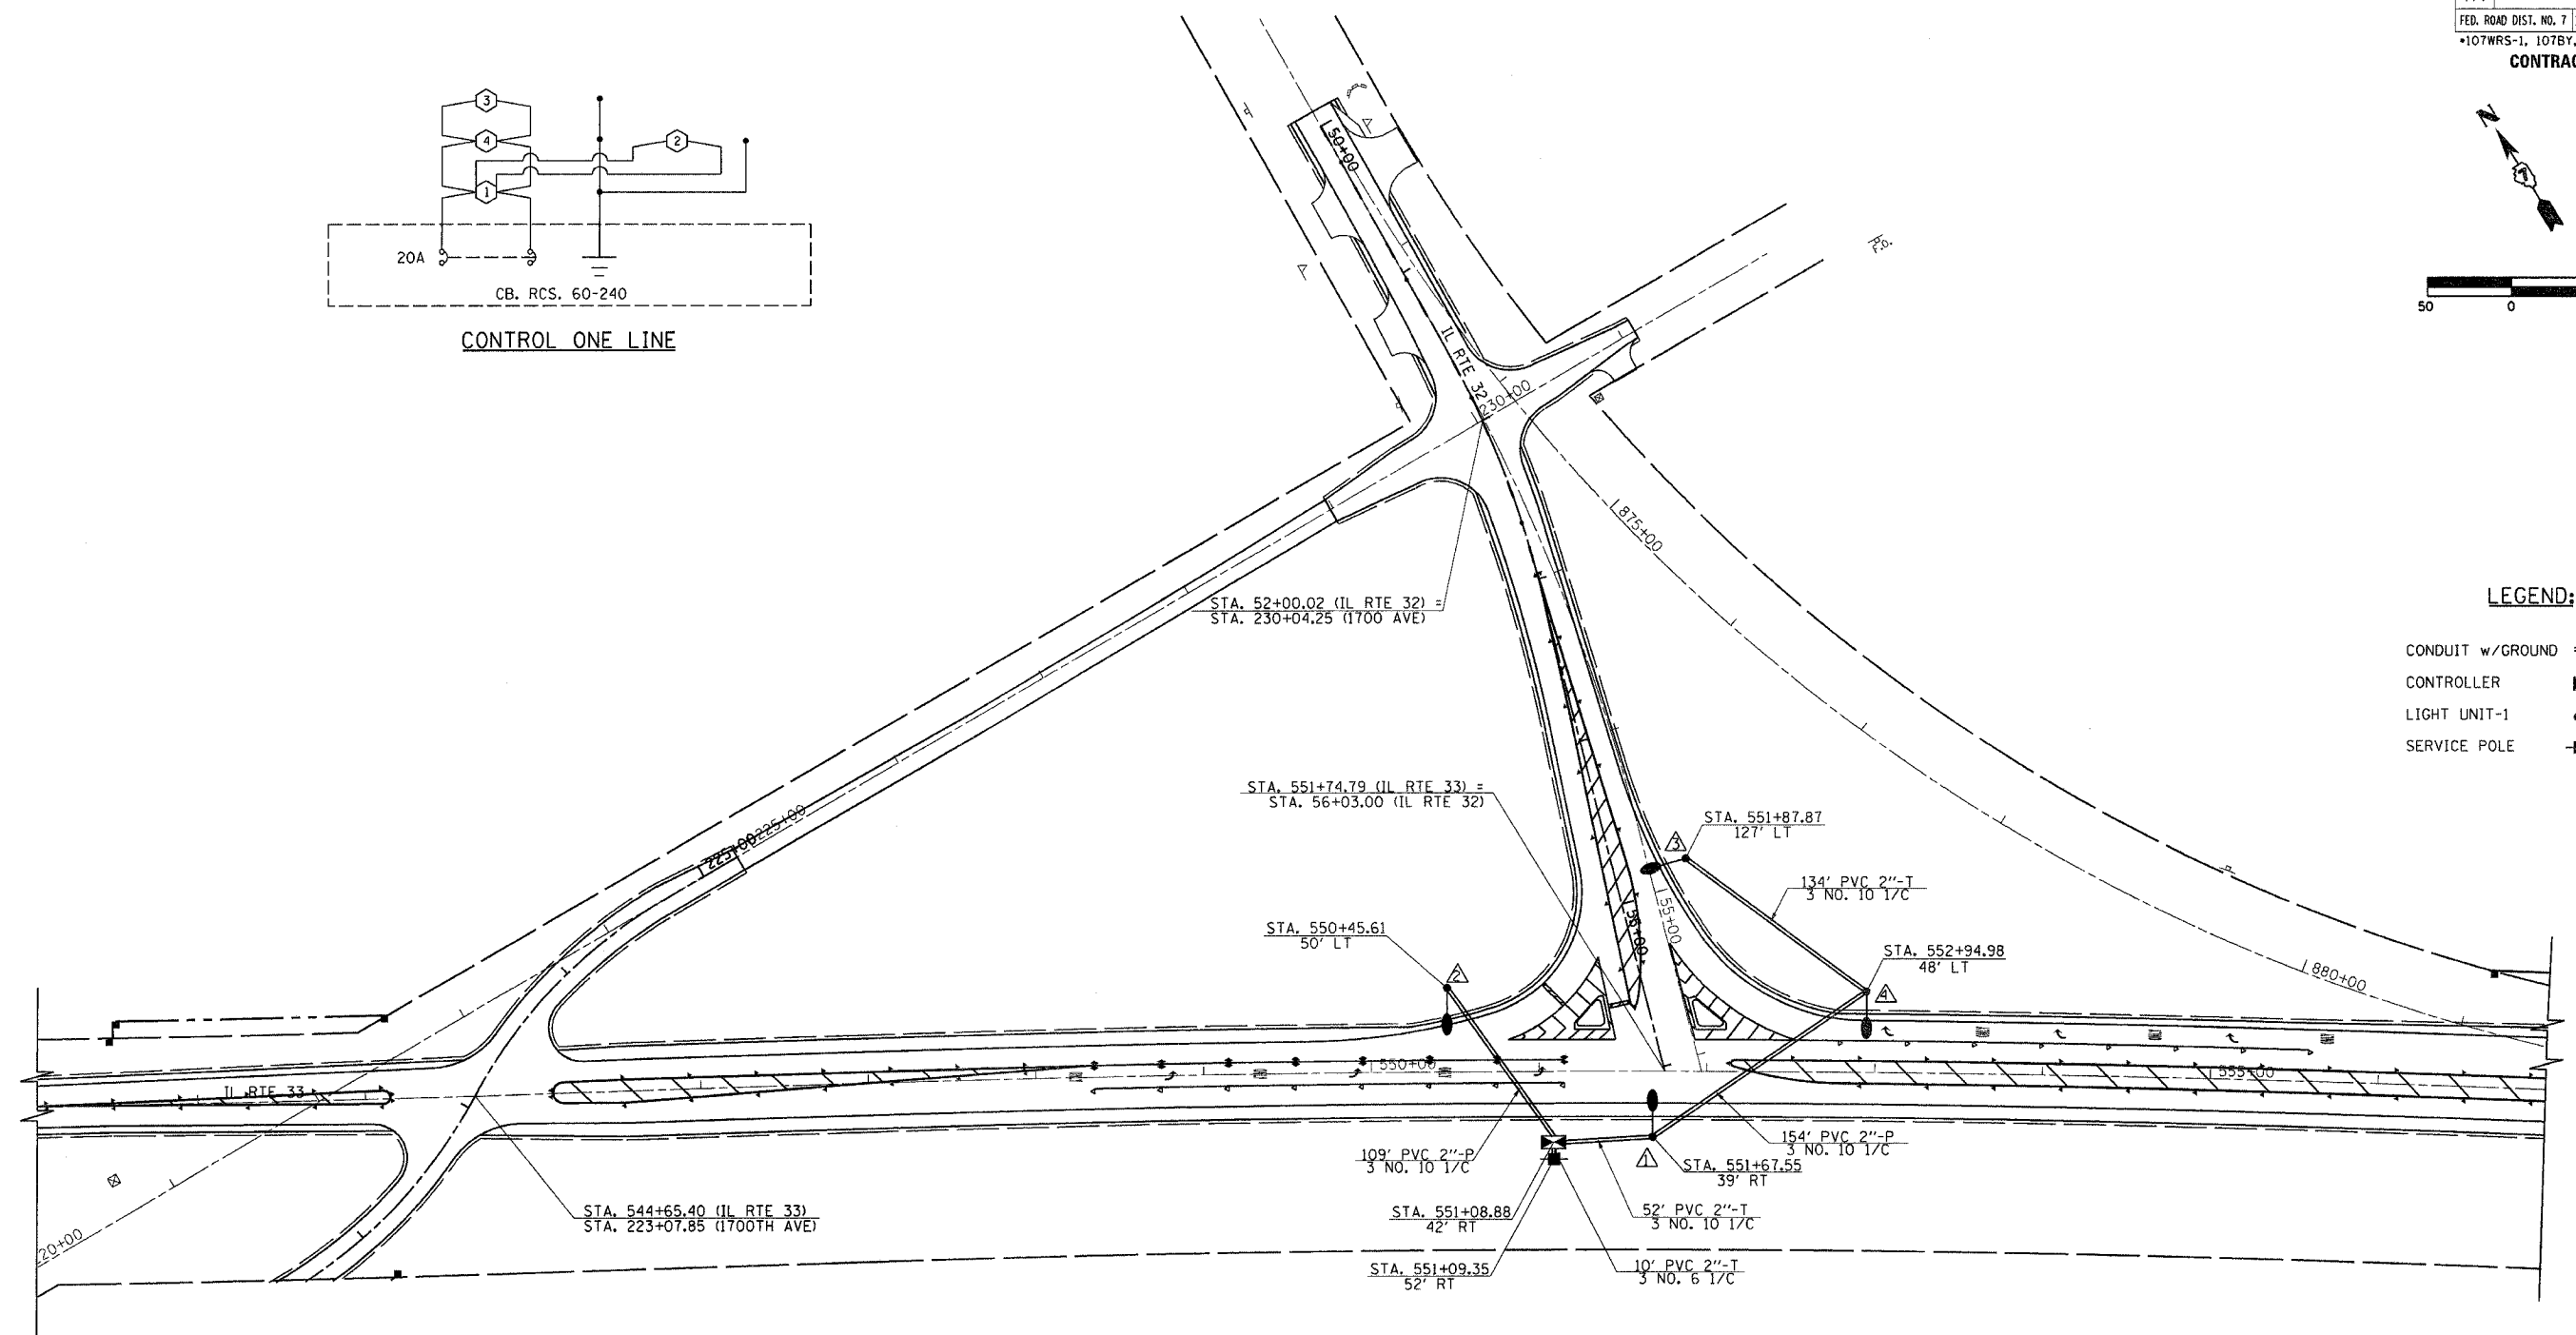

**LIGHT/CABLE LAYOUT**

REVISIONS	
NAME	DATE

ILLINOIS DEPARTMENT OF TRANSPORTATION

IL RTE 32/33 WYE  
LIGHTING PLANS  
SHEET 1 OF 8

DATE 8/02

DRAWN BY ASB  
CHECKED BY BWD