

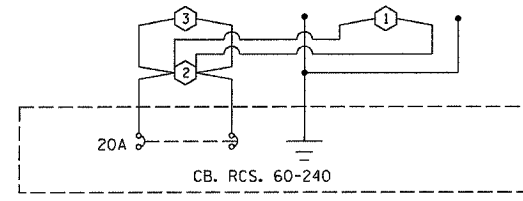


F.A.P. RTE.	SECTION	COUNTY	TOTAL SHEETS	SHEET NO.
774		EFFINGHAM	344	115
FED. ROAD DIST. NO. 7		ILLINOIS	FED. AID PROJECT	
		107WRS-1, 107BY, 107BY-1 & 107B-2		
CONTRACT NO. 94827				

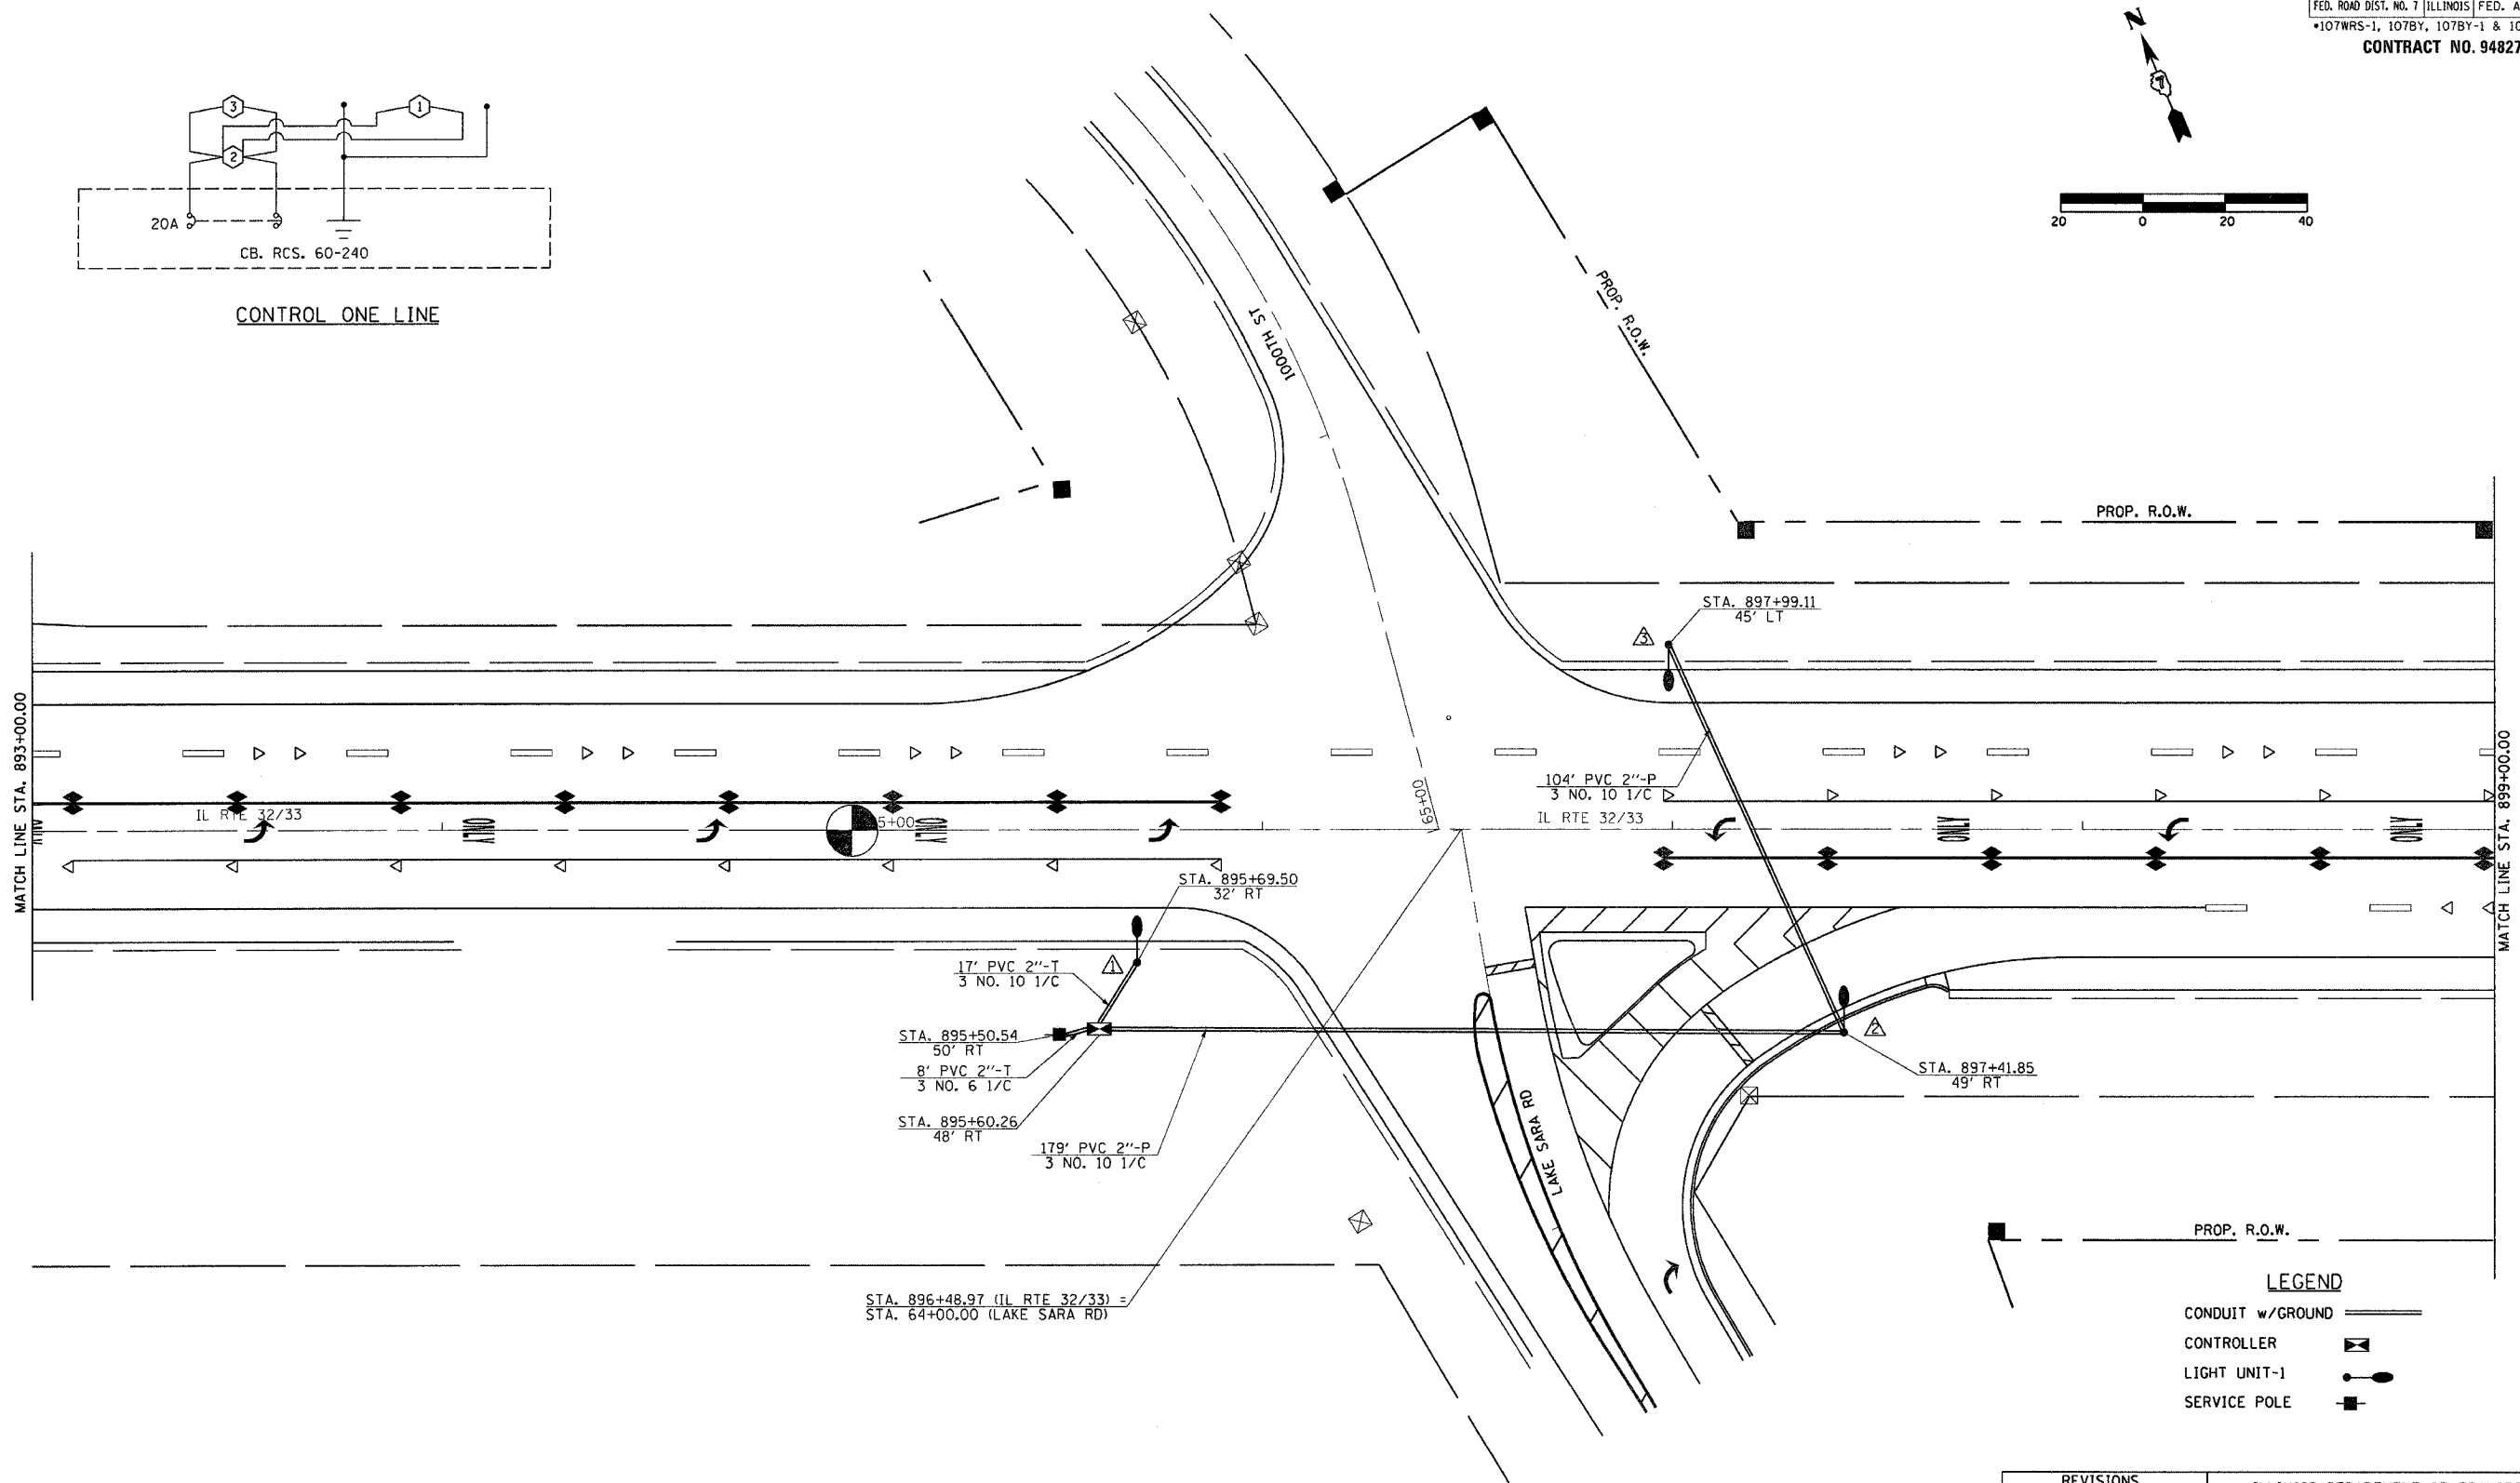

CONTROL ONE LINE

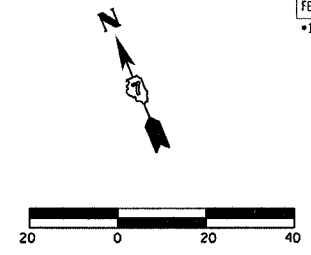

LIGHT/CABLE LAYOUT

LEGEND

- CONDUIT w/GROUND
- CONTROLLER
- LIGHT UNIT-1
- SERVICE POLE

REVISIONS	
NAME	DATE

ILLINOIS DEPARTMENT OF TRANSPORTATION

LAKE SARA ROAD
LIGHTING PLANS
SHEET 3 OF 8

DATE 8/02
DRAWN BY ASB
CHECKED BY BWD