

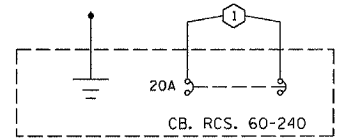


F.A.P. RTE.	SECTION	COUNTY	TOTAL SHEETS	SHEET NO.
774	*	EFFINGHAM	344	117
FED. ROAD DIST. NO. 7 ILLINOIS			FED. AID PROJECT	
*107WRS-1, 107BY, 107BY-1 & 107B-2				
<b>CONTRACT NO. 94827</b>				

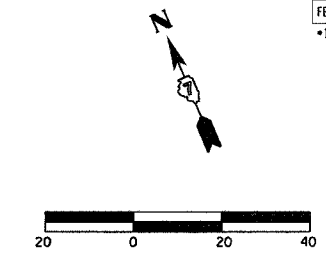

**CONTROL ONE LINE**

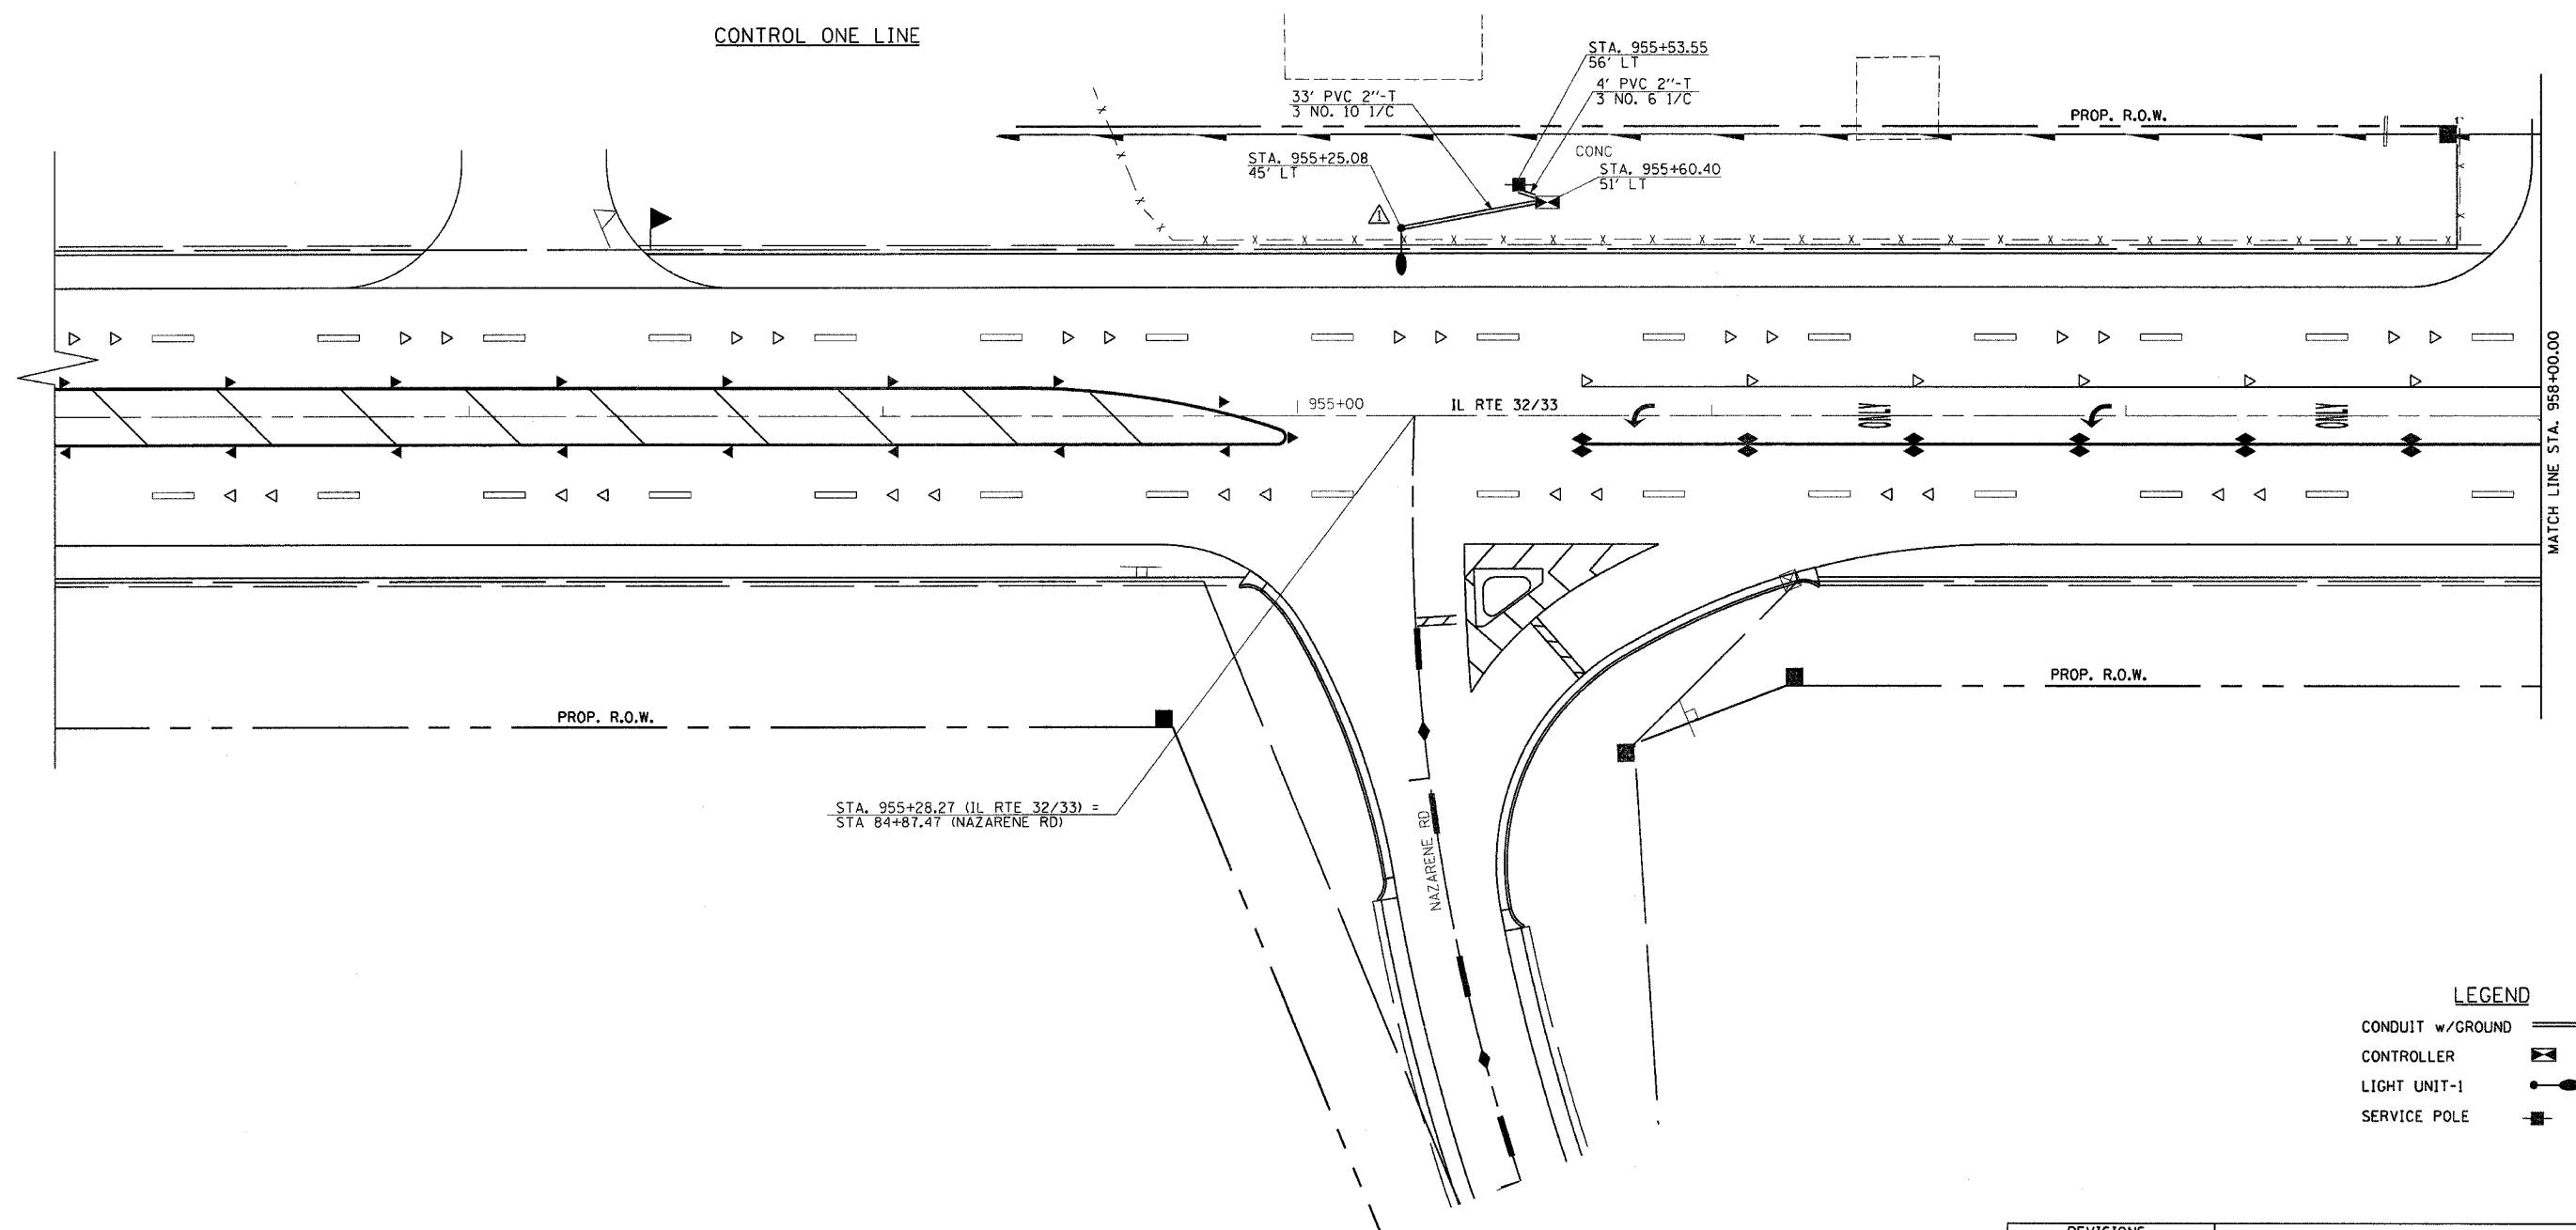

STA. 955+28.27 (IL RTE 32/33) =  
STA. 84+87.47 (NAZARENE RD)

**LEGEND**

CONDUIT w/GROUND	
CONTROLLER	
LIGHT UNIT-1	
SERVICE POLE	

REVISIONS	
NAME	DATE

ILLINOIS DEPARTMENT OF TRANSPORTATION

NAZARENE ROAD  
LIGHTING PLANS  
SHEET 5 OF 8

DATE 8/02

DRAWN BY ASB  
CHECKED BY BWD

**LIGHT/CABLE LAYOUT**