
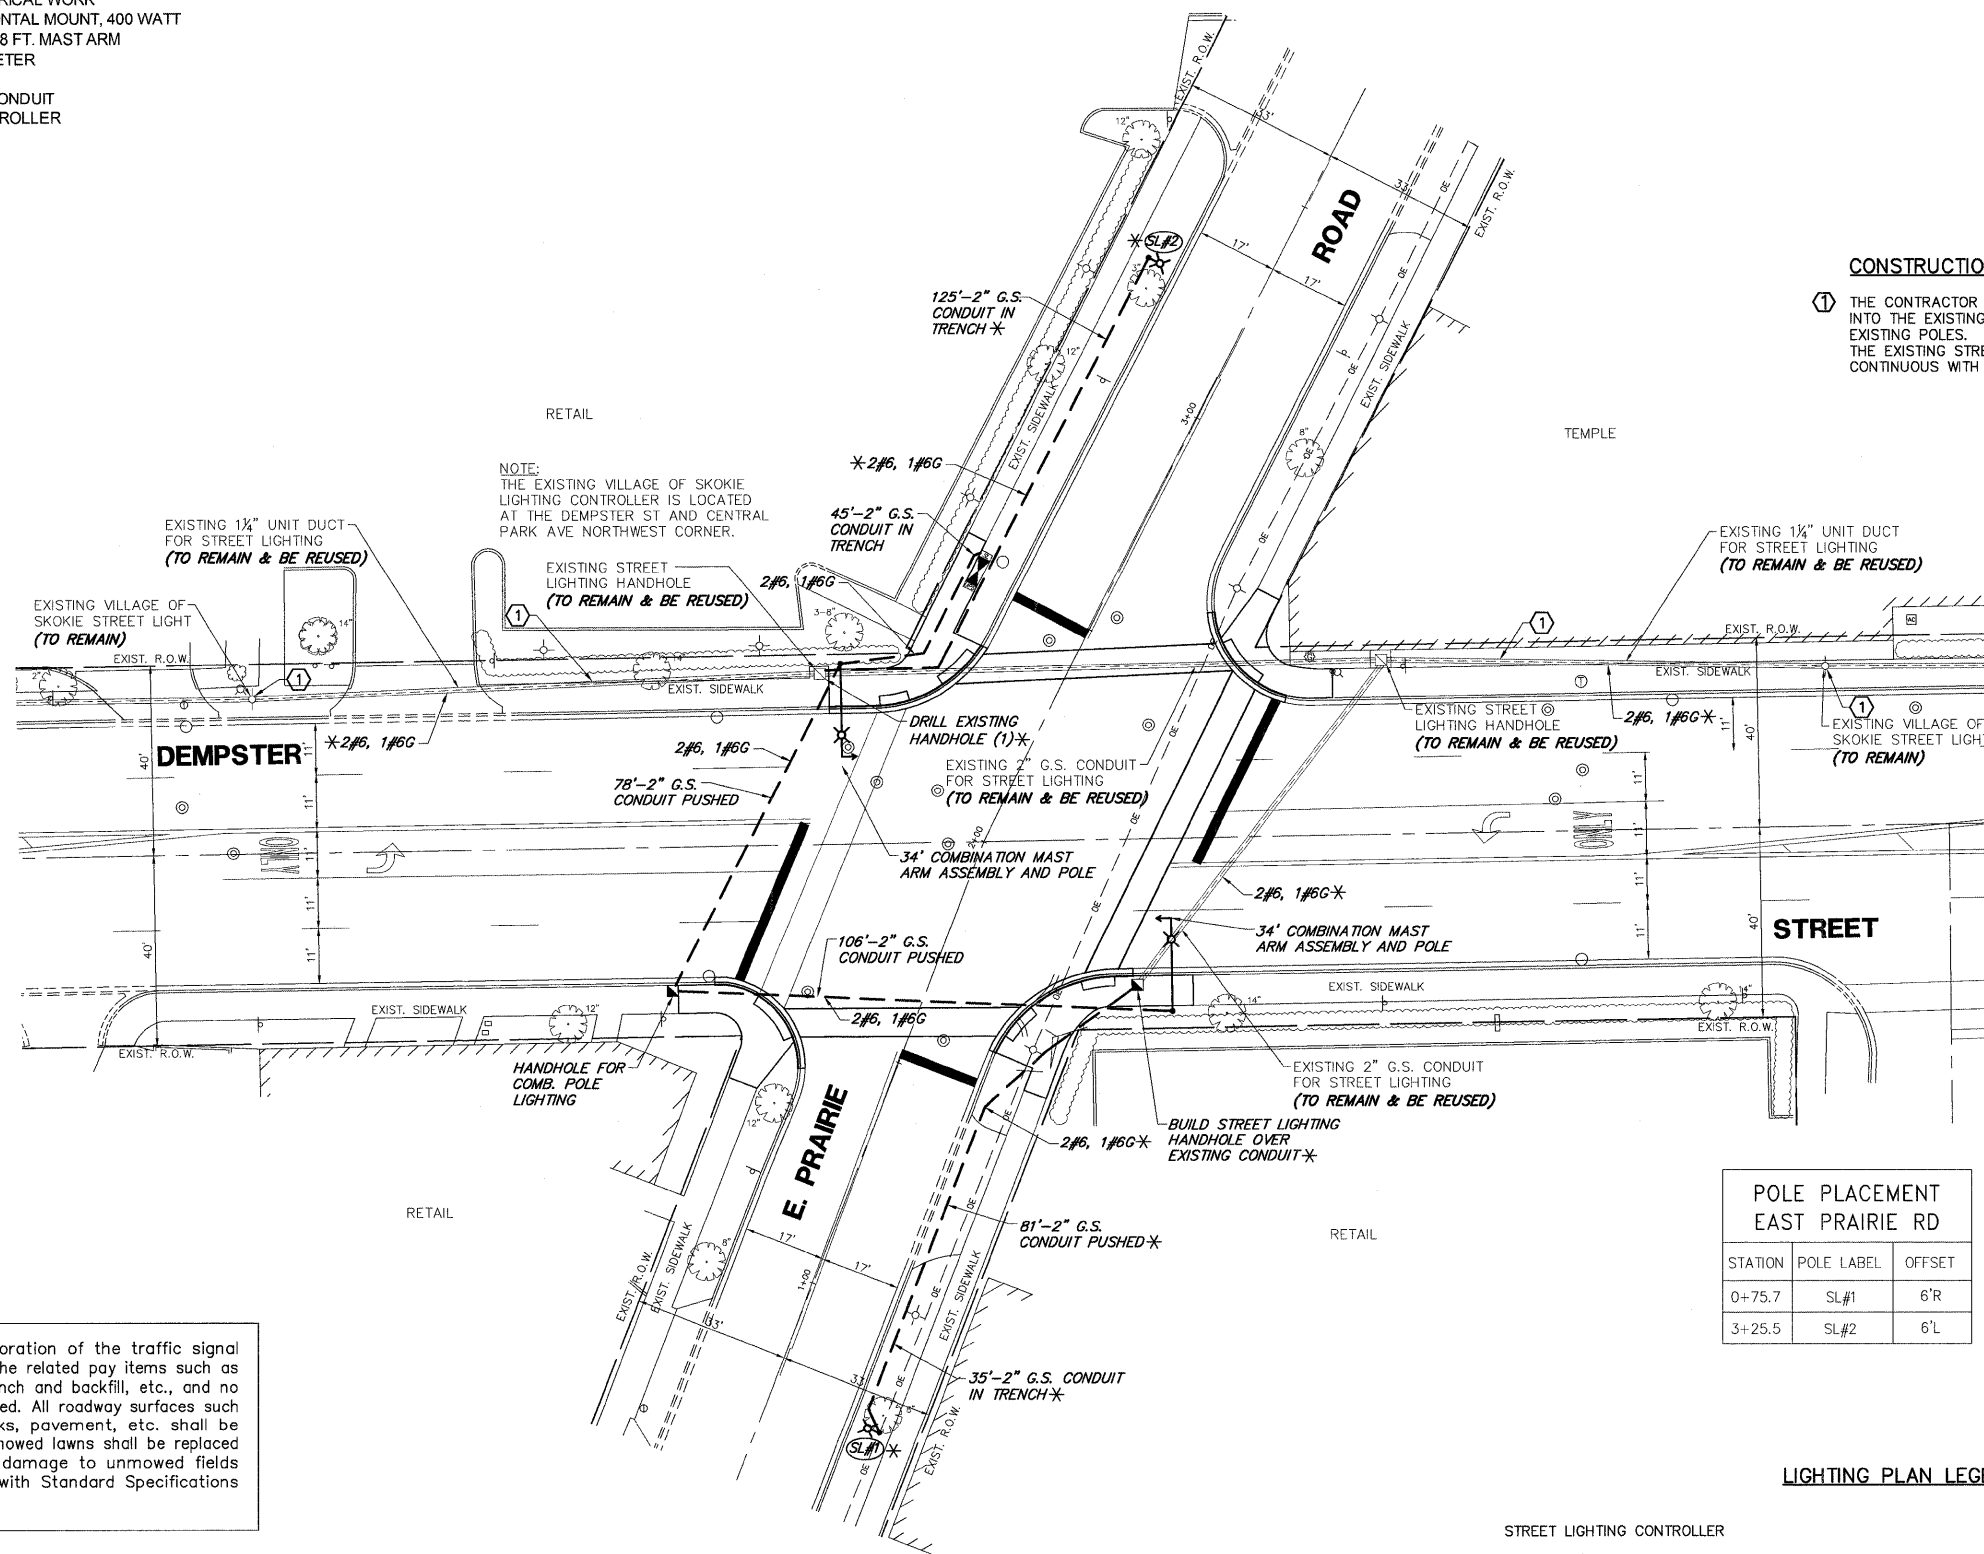


SCHEDULE OF QUANTITIES

DEMPSTER STREET AT EAST PRAIRIE AVENUE INTERSECTION LIGHTING

NO.	QUANT.	UNIT	
* 1.	206	FOOT	CONDUIT IN TRENCH, 2" DIA., GALVANIZED STEEL
2.	299	FOOT	CONDUIT PUSHED, 2" DIA., GALVANIZED STEEL
3.	2	EACH	HANDHOLE
4.	920	FOOT	ELECTRIC CABLE IN CONDUIT, 600V (XLP-TYPE USE) 3-1/C NO. 6
* 5.	226	FOOT	TRENCH AND BACKFILL FOR ELECTRICAL WORK
6.	4	EACH	LUMINAIRE, SODIUM VAPOR, HORIZONTAL MOUNT, 400 WATT
* 7.	2	EACH	LIGHT POLE, ALUMINUM, 35 FT. M.H., 8 FT. MAST ARM
* 8.	11	FOOT	LIGHT POLE FOUNDATION, 24" DIAMETER
* 9.	1	EACH	DRILL EXISTING HANDHOLE
* 10.	395	FOOT	REMOVE ELECTRIC CABLE FROM CONDUIT
11.	1	EACH	COMBINATION POLE LIGHTING CONTROLLER

* 100% OF THE COST TO THE VILLAGE OF SKOKIE

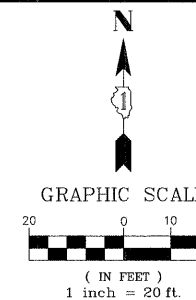

CONSTRUCTION NOTES:

- ① THE CONTRACTOR SHALL SPLICE NEW WIRES SERVICING SL#1 OR SL#2 INTO THE EXISTING VILLAGE OF SKOKIE STREET LIGHT CIRCUIT IN EXISTING POLES. THE CONTRACTOR SHALL INSTALL NEW WIRING FROM THE EXISTING STREET LIGHT TO SL#1 OR SL#2. THE WIRING SHALL BE CONTINUOUS WITH NO SPLICING ALLOWED. *

NOTE:
THE EXISTING VILLAGE OF SKOKIE LIGHTING CONTROLLER IS LOCATED AT THE DEMPSTER ST AND CENTRAL PARK AVE NORTHWEST CORNER.

Restoration of Work Area. Restoration of the traffic signal work area shall be incidental to the related pay items such as foundation, conduit, handhole, trench and backfill, etc., and no extra compensation shall be allowed. All roadway surfaces such as shoulders, medians, sidewalks, pavement, etc. shall be replaced in kind. All damage to mowed lawns shall be replaced with an approved sod, and all damage to unmowed fields shall be seeded in accordance with Standard Specifications 252 and 250 respectively.

POLE PLACEMENT EAST PRAIRIE RD		
STATION	POLE LABEL	OFFSET
0+75.7	SL#1	6'R
3+25.5	SL#2	6'L

LIGHTING PLAN LEGEND

- PROPOSED
- STREET LIGHTING CONTROLLER
- LIGHT POLE
- COMBINATION POLE
- * 100% OF THE COST TO THE VILLAGE OF SKOKIE

FILE NAME = 4085.870-TRI.dwg	USER NAME = ZACH WALLSTEN	DESIGNED - JRD	REVISED -	STATE OF ILLINOIS DEPARTMENT OF TRANSPORTATION	INTERSECTION LIGHTING PLAN DEMPSTER STREET AT EAST PRAIRIE ROAD	F.A.P. RTE. VARIES	SECTION 2010-006TS	COUNTY COOK	TOTAL SHEETS 58	SHEET NO. 41	CONTRACT # 60K24		
PLOT SCALE = 1" = .0833'	DRAWN - ZCW	CHECKED - KLB	REVISED -			SCALE 1"=20'	SHEET NO. OF SHEETS	STA. TO STA.	ILLINOIS FED. AID PROJECT				
PLOT DATE = 10/29/2010	DATE - 10/29/2010	REVISED -	REVISED -			GHA #4085.870							