


CITY OF WARRENVILLE
SE 1/4 SECTION 26 - 39 - 9


NE 1/4 SECTION 26 - 39 - 9

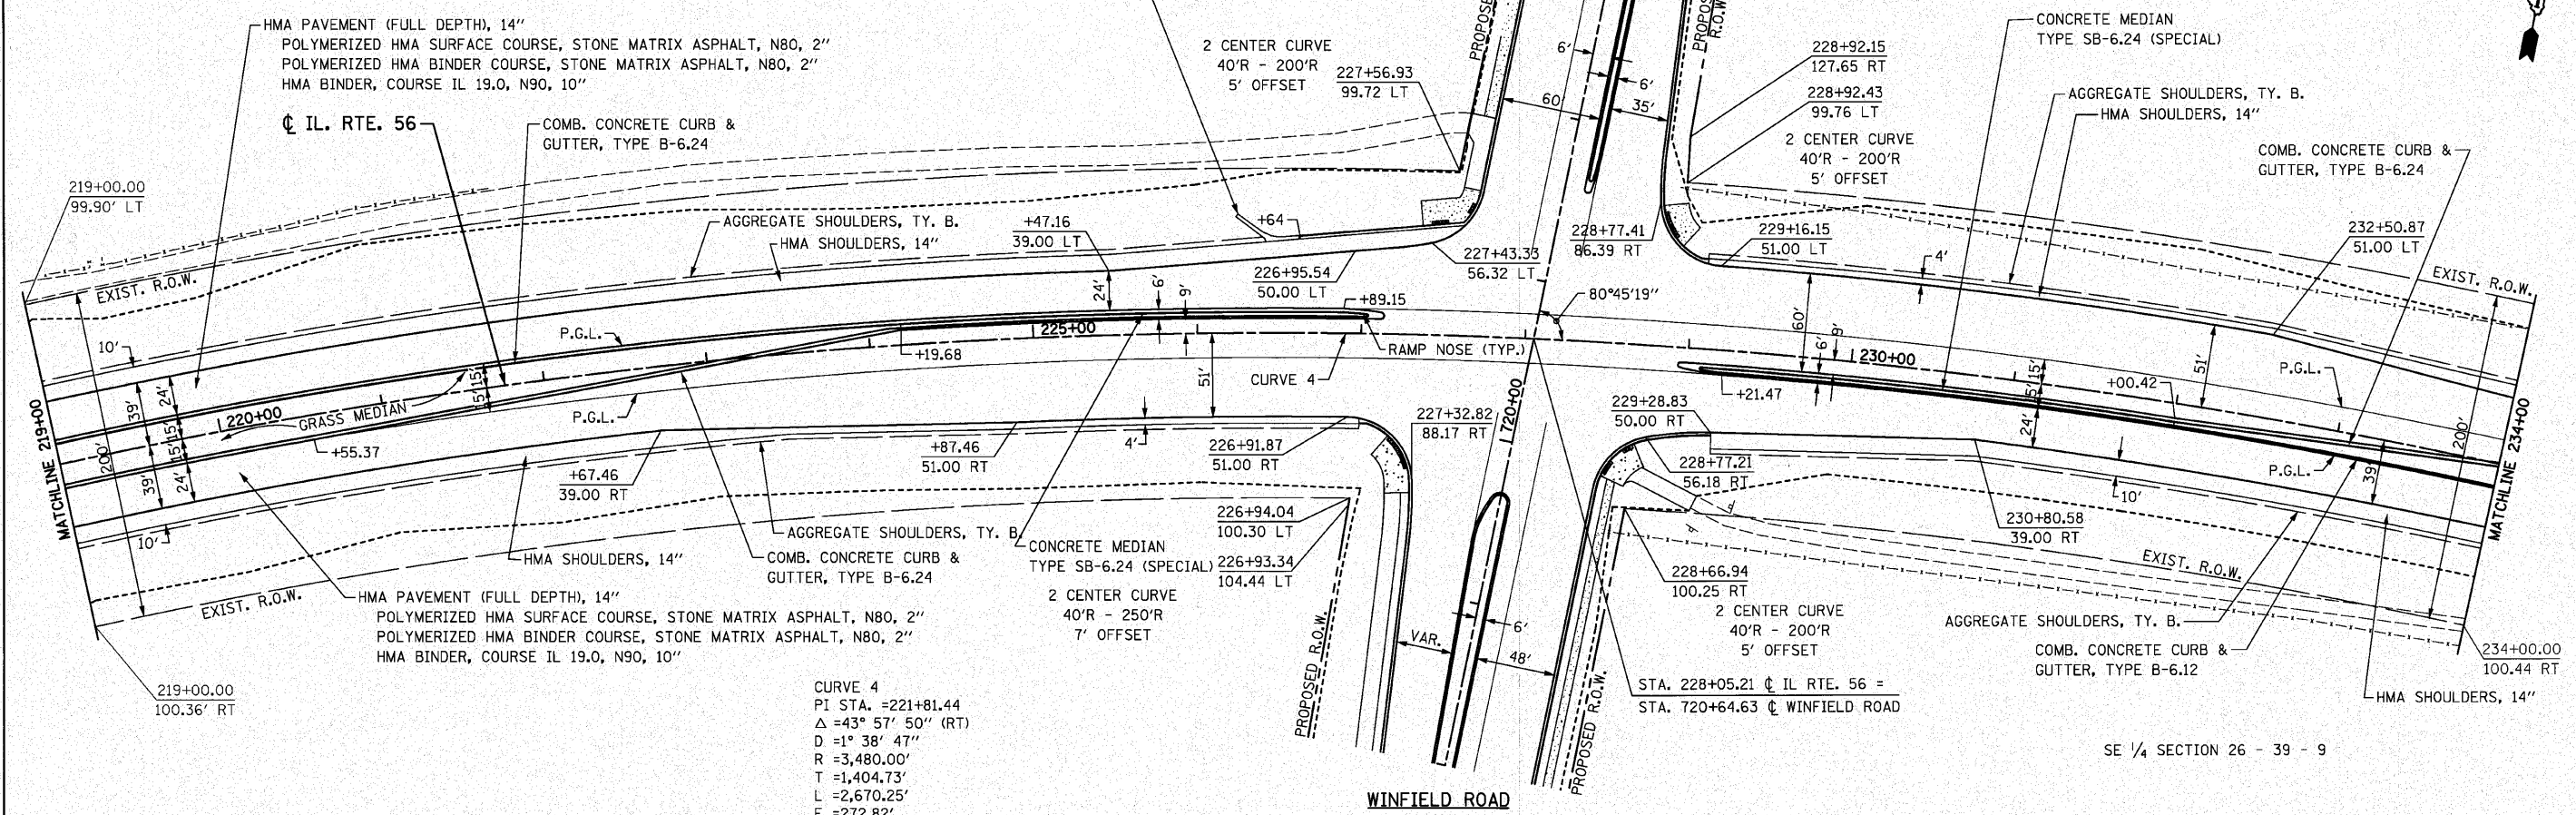

CURVE 4
PI STA. =221+81.44
Δ =43° 57' 50" (RT)
D =1° 38' 47"
R =3,480.00'
T =1,404.73'
L =2,670.25'
E =272.82'
e =3.02%
T.R. =75.49'
S.E. RUN =114'
P.C. STA. =207+76.71
P.T. STA. =234+46.96

BM 423 ELEV. 745.78
STA. 228+78.05 19.63' RT.
"□" CUT IN T.S. FOUNDATION

NOTES:
1. FOR WINFIELD ROAD INTERSECTION,
SEE DETAILS AND ELEVATIONS SHEET.

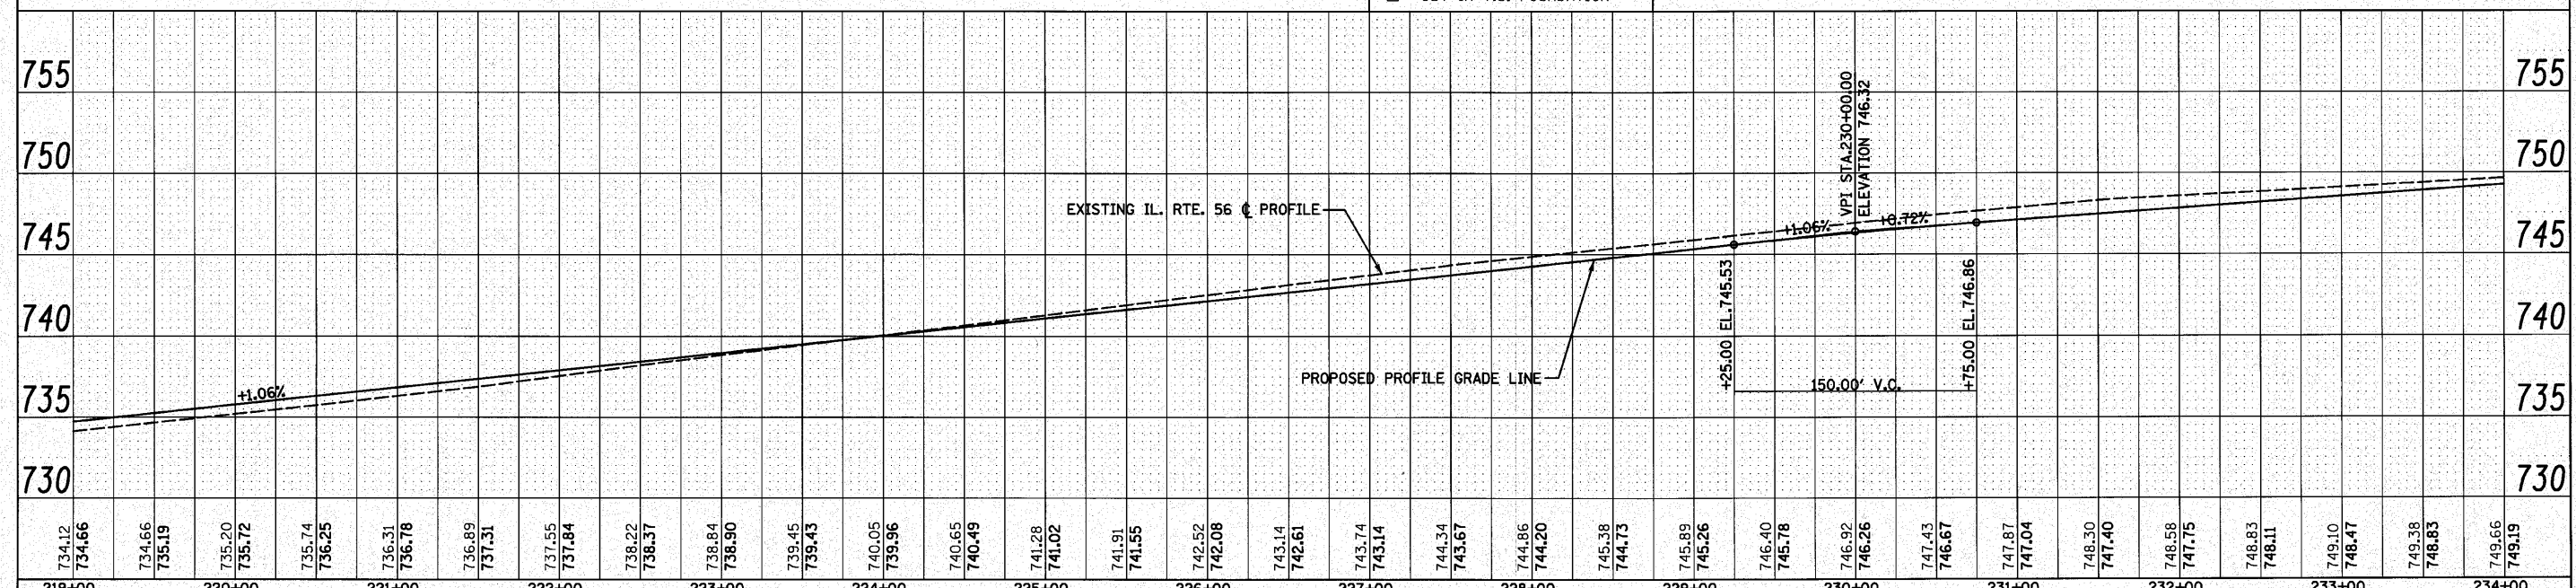

734.12 734.66	734.66 735.19	735.20 735.72	735.74 736.25	736.31 736.78	736.89 737.31	737.55 737.84	738.22 738.37	738.84 738.90	739.45 739.43	740.05 739.96	740.65 740.49	741.28 741.02	741.91 741.55	742.52 742.08	743.14 742.61	743.74 743.14	744.34 743.67	744.86 744.20	745.38 744.73	745.89 745.26	746.40 745.78	746.92 746.26	747.43 746.67	747.87 747.04	748.30 747.40	748.58 747.75	748.83 748.11	749.10 748.47	749.38 748.83	749.66 749.19
219+00	220+00	221+00	222+00	223+00	224+00	225+00	226+00	227+00	228+00	229+00	230+00	231+00	232+00	233+00	234+00															

FILE NAME =D162420-sh1-pln-rpf10.dgn
PLOT DATE =12/2/2010
PLOT SCALE=50.000' / IN.

CHRISTIAN-ROGE & ASSOCIATES, INC.
ENGINEERS-PLANNERS-SURVEYORS
211 WEST WACKER DRIVE
CHICAGO, ILLINOIS 60606
PHONE: (312)372-2023 FAX: (312)372-5274

DESIGNED - S.J.P.	REVISED -
DRAWN - B.K.P.	REVISED -
CHECKED - M.P.	REVISED -
DATE - DECEMBER 3, 2010	REVISED -

STATE OF ILLINOIS
DEPARTMENT OF TRANSPORTATION

ROADWAY PLAN AND PROFILE
IL. RTE. 56
SCALE: 1" = 50'
SHEET NO. 10 OF 12 SHEETS
STA. 219+00 TO STA. 234+00

F.A.P. RTE. 365	SECTION (58&59) WRS-3	COUNTY	TOTAL SHEETS 466	SHEET NO. 99
FED. ROAD DIST. NO. 1 ILLINOIS FED. AID PROJECT			CONTRACT NO. 62420	