

LEGEND

EXISTING DRAINAGE & UTILITIES

- GV ○ GAS VALVE
- WV ○ WATER VALVE
- BB ○ BUFFALO BOX
- VV ○ VALVE VAULT
- TEL ○ TELEPHONE VAULT
- ELEC ○ ELECTRIC VAULT
- ⊕ POWER POLE
- HANDHOLE
- HEAVY DUTY HANDHOLE
- ⊠ SPLICE BOX
- TELEPHONE POLE

- ADJ STRUCTURE TO BE ADJUSTED
- F FILLING EXISTING STRUCTURE
- C STRUCTURE TO BE CLEANED
- R REMOVE EXISTING STRUCTURE
- RM REMOVE STRUCTURE AND MAINTAIN FLOW
- REC STRUCTURE TO BE RECONSTRUCTED


- E — ELECTRIC
- G — GAS MAIN
- T — TELEPHONE
- S — STORM SEWER
- W — SANITARY SEWER
- W — WATER MAIN
- FO — FIBER OPTICS
- A — AERIAL CABLE
- TV — CABLE TELEVISION

NOTES:

1. THE REMOVAL OF EXISTING STORM SEWERS, DRAINAGE STRUCTURES AND PIPE CULVERTS SHALL BE INCLUDED IN THE COST OF THE CONTRACT WHEN THEY WILL BE REMOVED AS PART OF EARTH EXCAVATION OR DURING THE INSTALLATION OR THE PROPOSED ITEMS OF WORK.
2. TRENCH BACKFILL FOR STORM SEWER AND CULVERT REMOVAL SHALL ONLY BE PLACED UNDER AREAS OF PROPOSED PAVEMENT AND TO THE BOTTOM OF THE PROPOSED SUB-GRADE.

FERMILAB
NATIONAL ACCELERATOR
CITY OF WARRENVILLE
NE ¼ SECTION 33 - 39 - 9


BEGIN SECTION (58&59) WRS-3
STA. 90+00

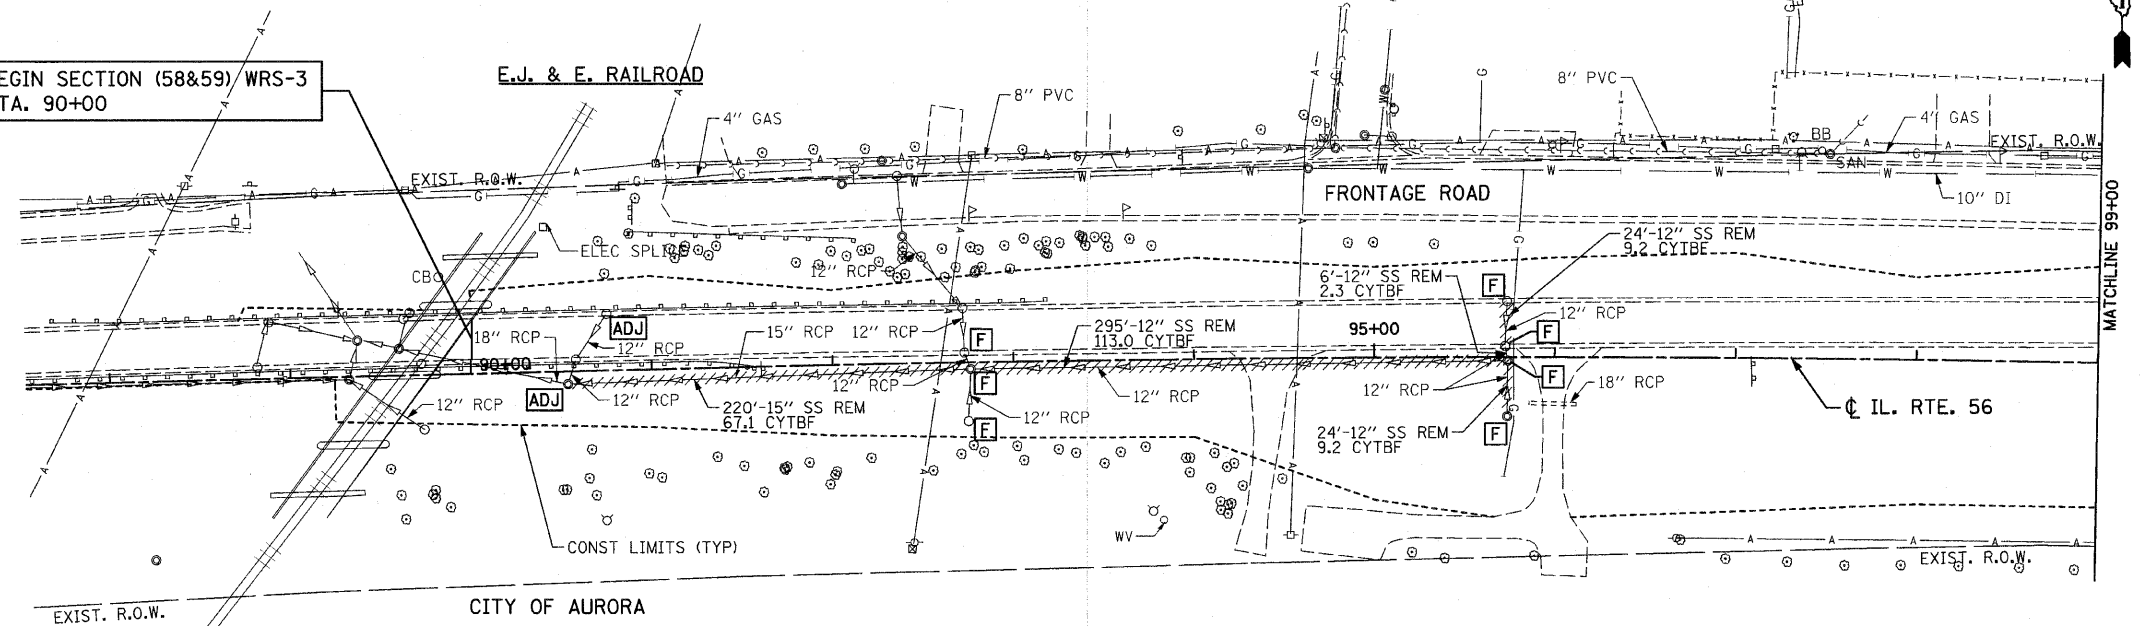

CITY OF WARRENVILLE
NE ¼ SECTION 33 - 39 - 9

BARKLEY AVENUE

TALBOT AVENUE

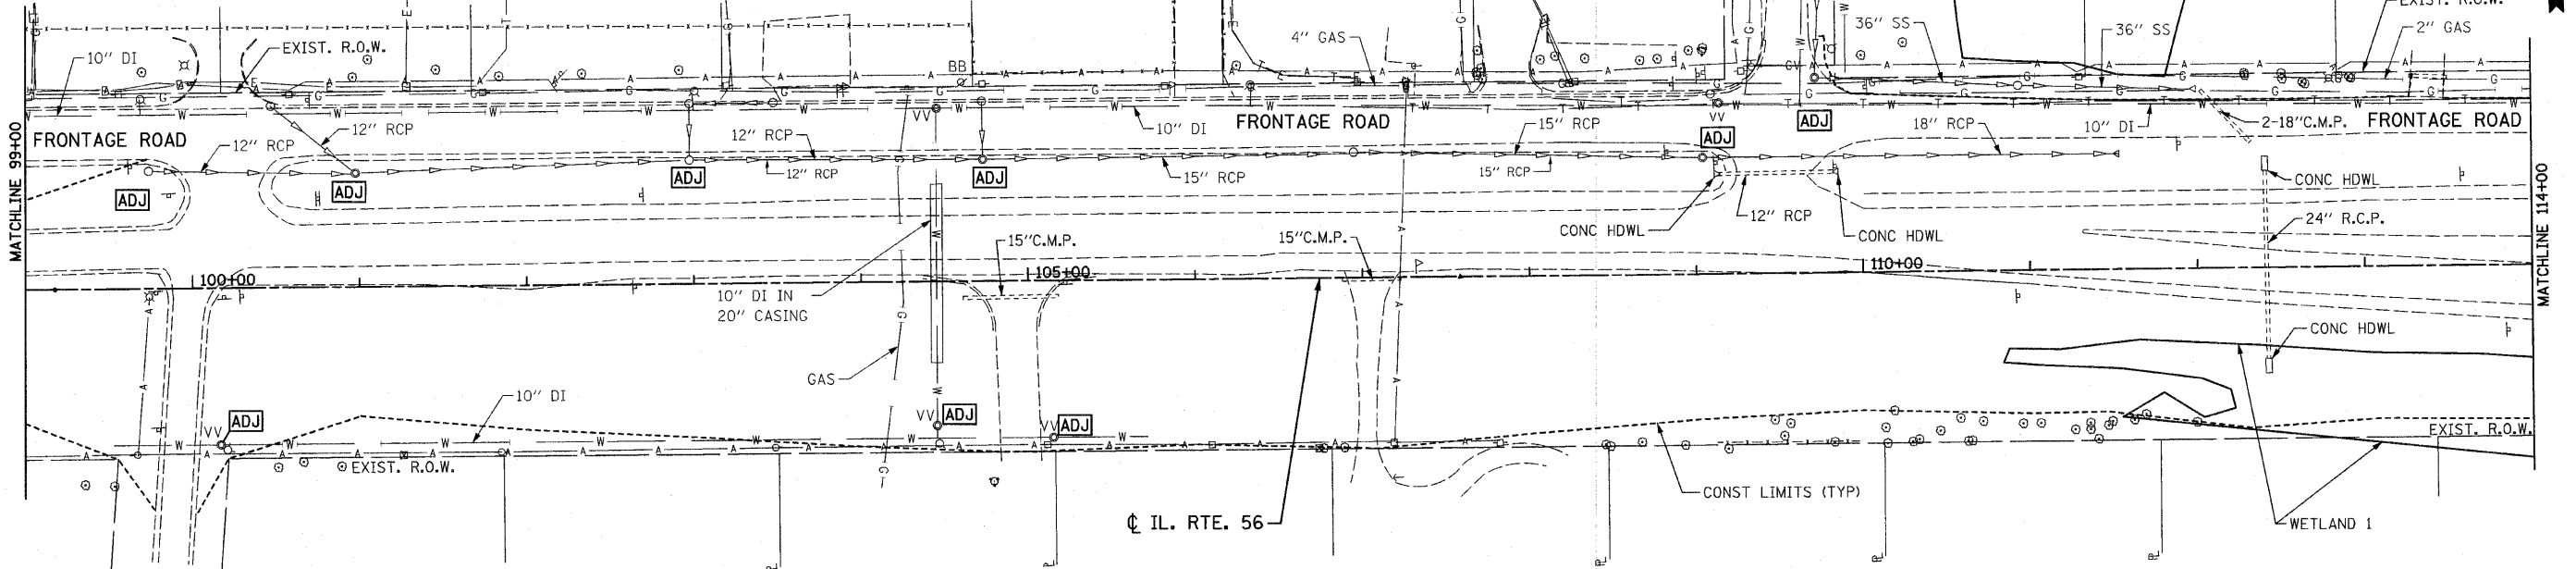

SE ¼ SECTION 33 - 39 - 9

FILE NAME = D162420-shd-util.dgn
PLOT DATE = 12/3/2010
PLOT SCALE = 50.000' / IN.

CHRISTIAN-ROGE & ASSOCIATES, INC.
ENGINEERS-PLANNERS-SURVEYORS
211 WEST WACKER DRIVE
CHICAGO, ILLINOIS 60606
PHONE: (312)372-2023 FAX: (312)372-5274

DESIGNED - S.J.P.	REVISED -
DRAWN - A.C.S.	REVISED -
CHECKED - M.P.	REVISED -
DATE - DECEMBER 3, 2010	REVISED -

**STATE OF ILLINOIS
DEPARTMENT OF TRANSPORTATION**

**EXISTING DRAINAGE & UTILITY PLAN
IL. RTE. 56**

SCALE: 1" = 50' SHEET NO. 1 OF 6 SHEETS STA. 90+00 TO STA. 114+00

F.A.P. RTE.	SECTION	COUNTY	TOTAL SHEETS	SHEET NO.
365	(58&59) WRS-3	DUPAGE	466	126
CONTRACT NO. 62420				

FED. ROAD DIST. NO. 1 ILLINOIS FED. AID PROJECT