


157
 STA. 254+75, CL
 CB TA 4' Ø T8C
 RIM EL 762.34
 INV 758.20

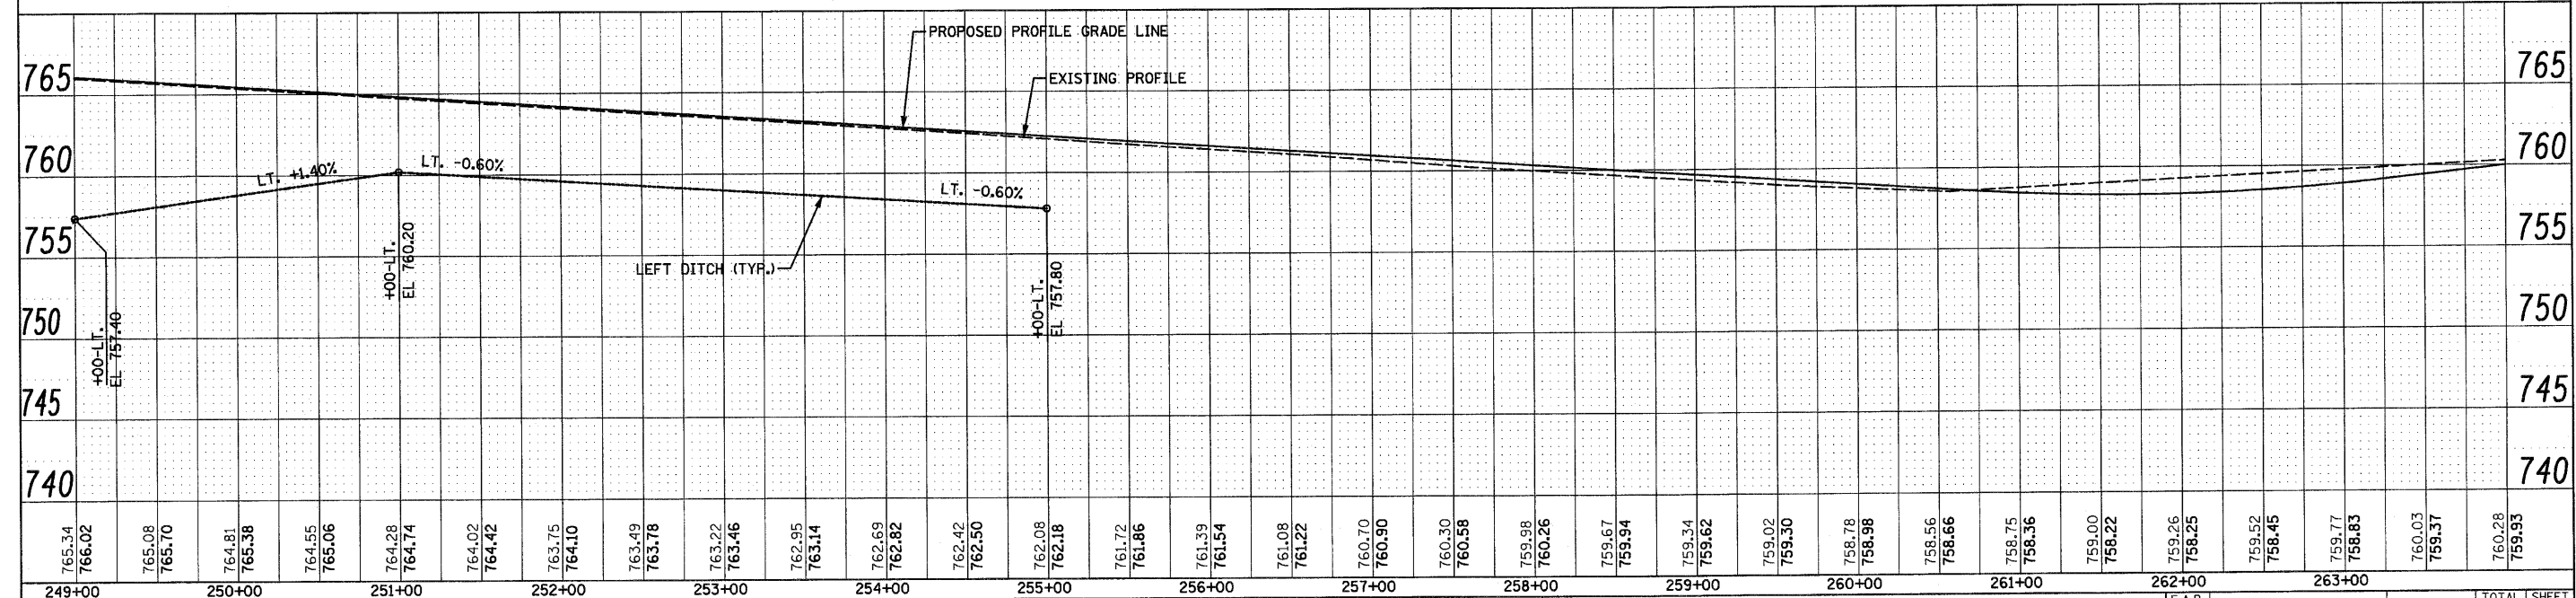

765.34 766.02	765.08 765.70	764.81 765.38	764.55 765.06	764.28 764.74	764.02 764.42	763.75 764.10	763.49 763.78	763.22 763.46	762.95 763.14	762.69 762.82	762.42 762.50	762.08 762.18	761.72 761.86	761.39 761.54	761.08 761.22	760.70 760.90	760.30 760.58	759.98 760.26	759.67 759.94	759.34 759.62	759.02 759.30	758.78 758.98	758.56 758.66	758.75 758.36	759.00 758.22	759.26 758.25	759.52 758.45	759.77 758.83	760.03 759.37	760.28 759.93
249+00	250+00	251+00	252+00	253+00	254+00	255+00	256+00	257+00	258+00	259+00	260+00	261+00	262+00	263+00																

FILE NAME = D:\62420-shd-drawn12.dgn
 PLOT DATE = 12/2/2010
 PLOT SCALE = 50.000' / IN.

CHRISTIAN-ROGE & ASSOCIATES, INC.
 ENGINEERS-PLANNERS-SURVEYORS
 211 WEST WACKER DRIVE
 CHICAGO, ILLINOIS 60606
 PHONE: (312)372-2023 FAX: (312)372-5274

DESIGNED - S.J.P.	REVISED -
DRAWN - A.C.S.	REVISED -
CHECKED - M.P.	REVISED -
DATE - DECEMBER 3, 2010	REVISED -

STATE OF ILLINOIS
DEPARTMENT OF TRANSPORTATION

DRAINAGE PLAN AND PROFILE
IL. RTE. 56
 SCALE: 1" = 50'
 SHEET NO. 12 OF 12 SHEETS
 STA. 249+00 TO STA. 255+00

F.A.P. RTE. 365	SECTION (58&59) WRS-3	COUNTY DuPAGE	TOTAL SHEETS 466	SHEET NO. 146
CONTRACT NO. 62420			FED. ROAD DIST. NO. 1 ILLINOIS FED. AID PROJECT	