
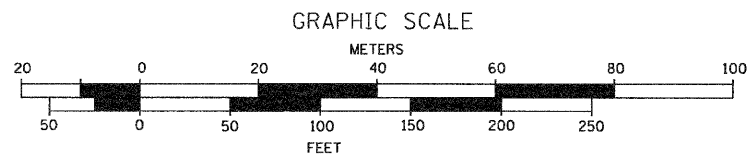


TEMPORARY LIGHTING NOTES:

1. ALL AERIAL CABLES ARE (3) 1/C #4 ALUMINUM WITH MESSENGER WIRE.
2. CONTRACTOR SHALL COORDINATE AND STAGE TEMPORARY, DEMOLITION AND PROPOSED LIGHTING INSTALLATION AND ENERGIZATION SO THAT NO SECTIONS OF ROADWAY THAT ARE CURRENTLY ILLUMINATED WILL BE WITHOUT LIGHT FOR ANY NIGHTTIME PERIOD.
3. MAINTAIN CLEARANCE FROM GROUND PER NEC SECTION 225.18 FOR ALL AERIAL CABLES. MAINTAIN CLEARANCE FROM COMED OVERHEAD ELECTRIC LINES AS REQUIRED BY COMED.
4. ALL TEMPORARY LIGHT UNITS SHALL HAVE 60' CLASS 4 WOOD POLES AND 15' MAST ARMS WITH A LUMINAIRE MOUNTING HEIGHT OF 47'-6". LUMINAIRES SHALL BE 400W, 240V, MCIII.
5. WORK ON THIS SHEET SHALL BE COORDINATED WITH THE MAINTENANCE OF TRAFFIC PLANS.
6. TEMPORARY LIGHTING CIRCUITS TO BE CONNECTED TO EXISTING CONTROLLER.
7. INSTALL (1) 2" PVC CONDUIT IN TRENCH WITH 1-3/C#4 AND 1-1/C#6 GROUND FOR TEMPORARY CONNECTIONS BETWEEN EXISTING LIGHTING CONTROLLER AND AERIAL CABLES. REFER TO "WOOD POLE TO LIGHTING CONTROLLER WIRING CONNECTION" DETAIL ON SHEET LT-18.
8. ELECTRICAL SERVICE TO EXISTING CONTROLLER TO REMAIN ENERGIZED UNTIL PROPOSED LIGHTING SYSTEM IS IN SERVICE. REMOVE EXISTING ELECTRICAL SERVICE AFTER PROPOSED LIGHTING SYSTEM IS IN SERVICE.
9. REMOVE CONDUCTORS FROM ALL EXISTING UNIT DUCTS. EMPTY UNIT DUCTS ARE TO BE ABANDONED IN PLACE.
10. REMOVAL OF THE LIGHTING UNITS LOCATED ON THE EXISTING COMBINATION MAST ARMS AND THE COMBINATION MAST ARM FOUNDATIONS IS INCLUDED IN TRAFFIC SIGNAL PAY ITEMS.

DEMOLITION LEGEND

- R EXISTING TO BE REMOVED AND SALVAGED TO IDOT
- T WOOD POLE WITH LUMINAIRE FOR TEMPORARY LIGHTING

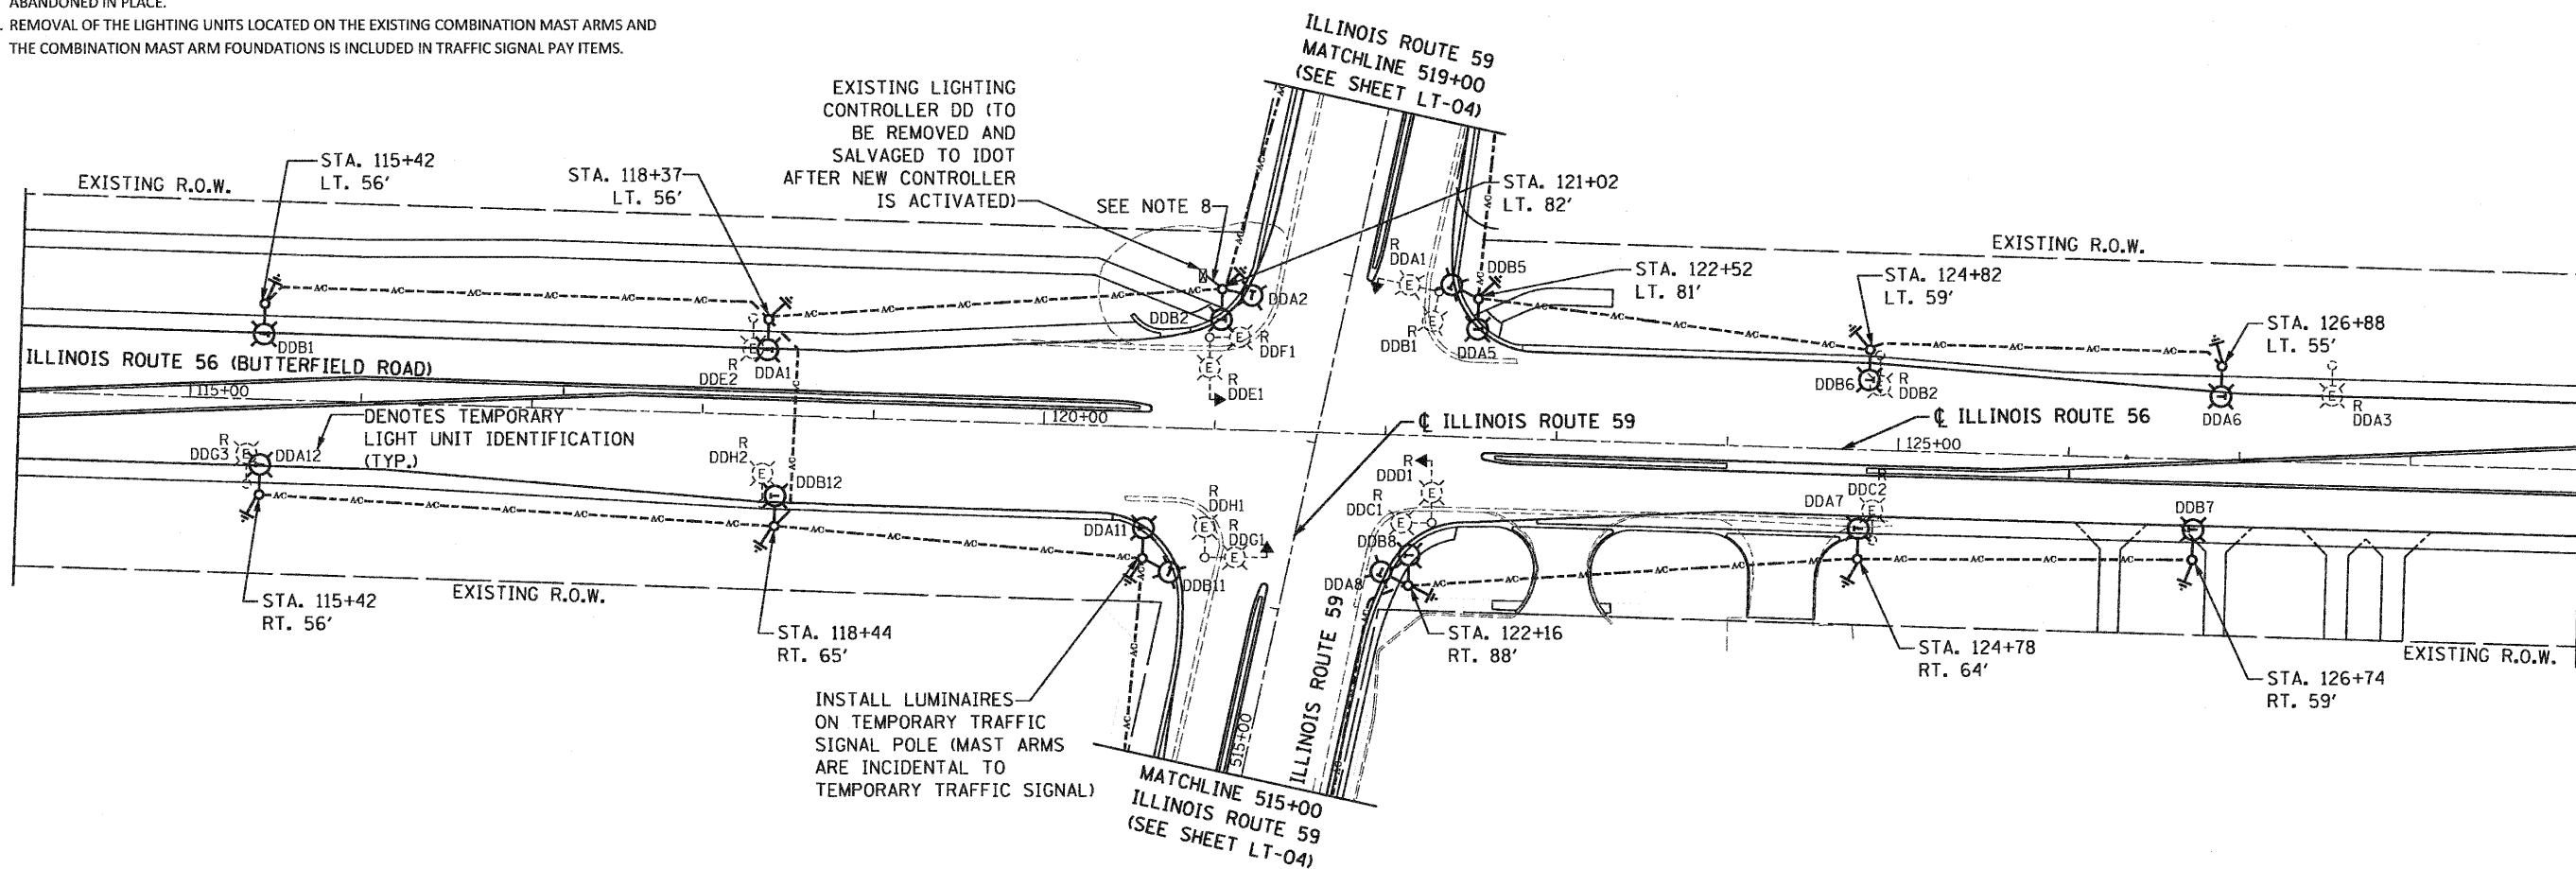

LT-03

FILE NAME = LT-03.dgn PLOT DATE = 8/13/2018	SPAAN Tech, Inc. <small>311 S. Wacker Drive, Suite 2400 Chicago, Illinois 60606 phone: 312.277.8800 fax: 312.277.8808 web: www.spaanTech.com</small>	DESIGNED - I. A. B.	REVISED -	STATE OF ILLINOIS DEPARTMENT OF TRANSPORTATION	DEMOLITION AND TEMPORARY LIGHTING PLAN ILLINOIS ROUTE 56 AT ILLINOIS ROUTE 59	F.A.P. RTE. 365	SECTION (58&59) WRS-3	COUNTY DUPAGE	TOTAL SHEETS 466	SHEET NO. 268
		DRAWN - M. K. J.	REVISED -			SCALE: 1" = 50' SHEET NO. 1 OF 2 SHEETS STA. 114+00 TO STA. 129+00 FED. ROAD DIST. NO. 1 (ILLINOIS) FED. AID PROJECT				
		CHECKED - A. D. O.	REVISED -	CONTRACT NO. 62420						
		DATE - AUGUST 2010	REVISED -							