


F.A.P. RTE.	SECTION	COUNTY	TOTAL SHEETS	SHEET NO.
353	(12&13)WRS-4	WILL	608	199
STA. 980+00		TO STA. 989+00		
FED. ROAD DIST. NO. 1 ILLINOIS FED. AID PROJECT				

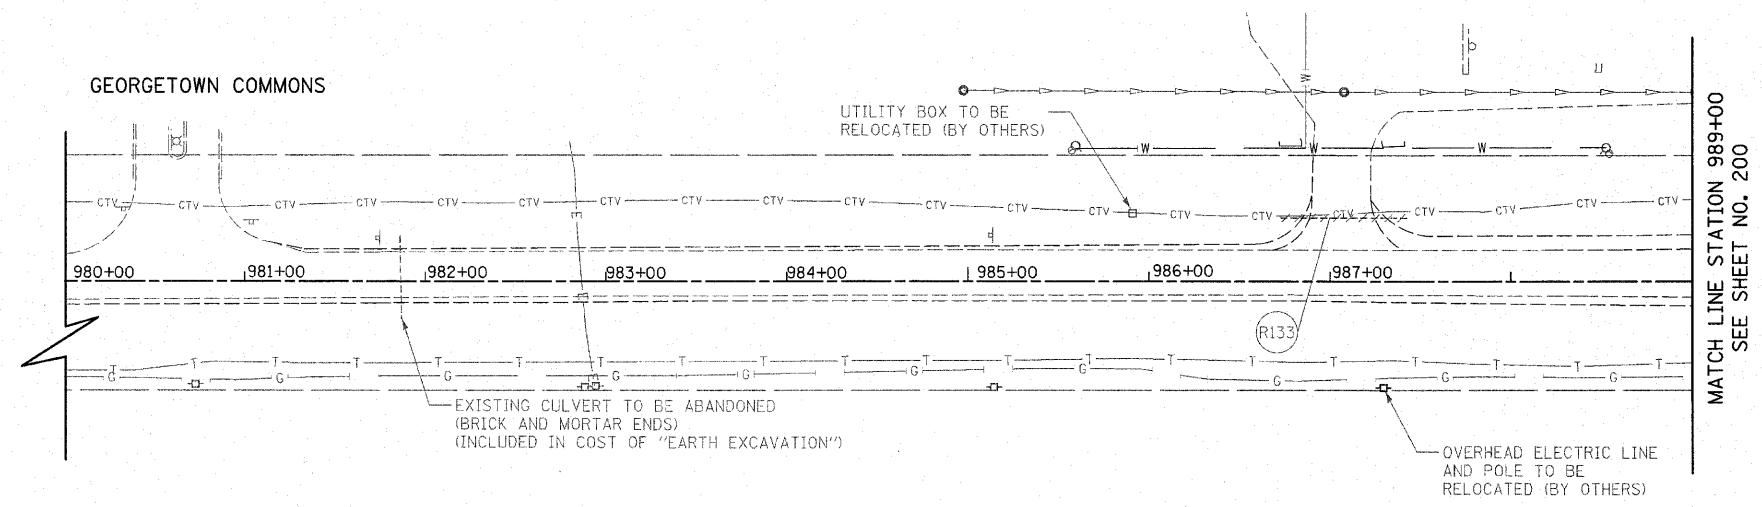


- (R132) NOT USED
- (R133) 72' STORM SEWER REMOVAL 12"  
TBF = 5.0 CY

EXISTING HARLEM AVENUE



- 518 NOT USED
- 519 NOT USED
- 520 NOT USED
- 521 STA. 986+83, 47.0' LT  
PRC FLARED END SECTION, 15"  
INV = 716.40
- 522 STA. 987+35, 47.0' LT  
PRC FLARED END SECTION, 15"  
INV = 715.88
- 523 STA. 988+20.64, 45.0' LT  
MH, T-A, 5'-DIA., T-1 FR. CL.  
RIM = 718.06  
INV = 711.32 (24" N)
- 524 NOT USED

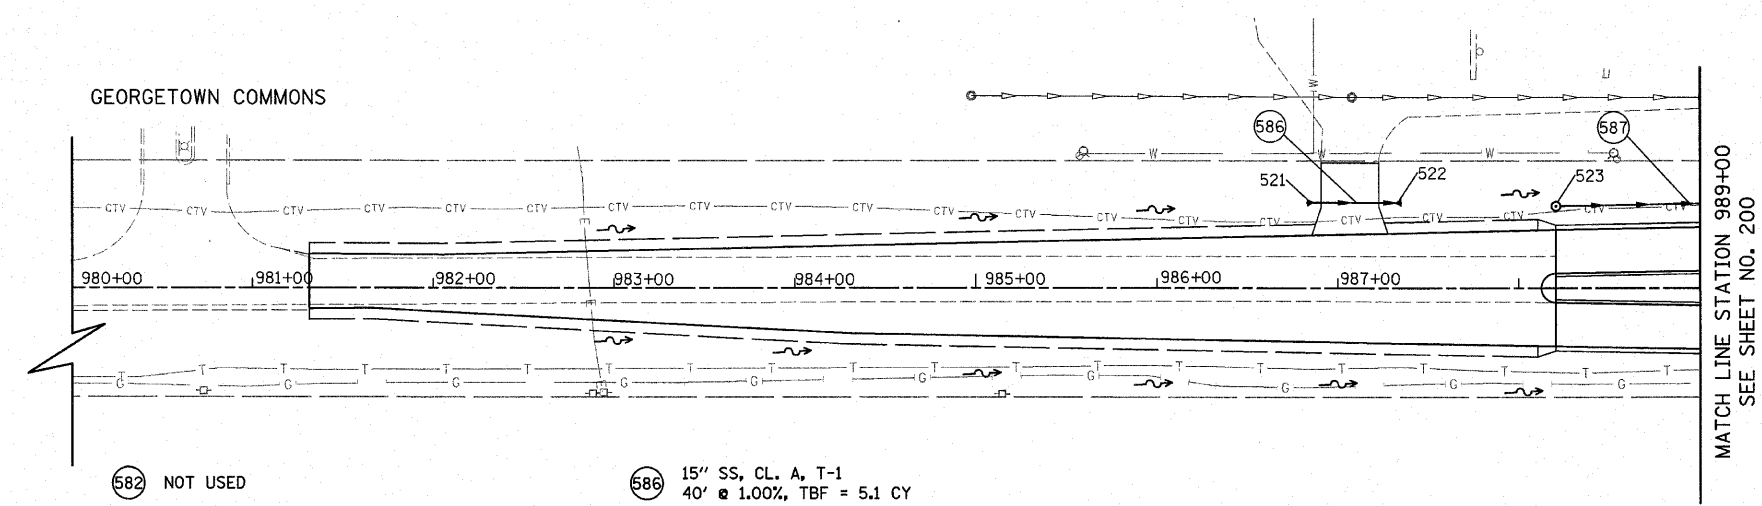

- (582) NOT USED
- (583) NOT USED
- (584) NOT USED
- (585) NOT USED
- (586) 15" SS, CL. A, T-1  
40' @ 1.00%, TBF = 5.1 CY
- (587) 24" SS, CL. A, T-2  
319' @ 0.17%, TBF = 0.0 CY
- (588) NOT USED

NOTES:  
1. SEE SHEET NO. 215 FOR  
CORRESPONDING PROFILE

REVISIONS	
NAME	DATE

PROPOSED HARLEM AVENUE

ILLINOIS DEPARTMENT OF TRANSPORTATION

HARLEM AVENUE  
DRAINAGE AND UTILITY PLANS

STATION 980+00 TO STATION 989+00

SCALE IN FEET

DATE 6/11/2010

DRAWN BY DJK  
CHECKED BY JRV