


LIGHTING LEGEND



- LIGHT POLE AND LUMINAIRE, TYPE A
- LIGHT POLE AND LUMINAIRE, TYPE B
- LIGHTING CONTROLLER
- UNIT DUCT IN TRENCH
- UNIT DUCT IN CONDUIT (PUSHED)

PROPOSED

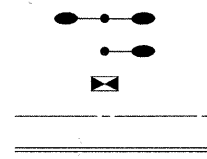

UNIT DUCT LEGEND

- (A) UNIT DUCT, 600V, 3-1C NO. 8, 1/C NO. 8 GROUND, (XLP-TYPE USE), 1" DIA. POLYETHYLENE
- (B) UNIT DUCT, 600V, 2-1C NO. 6, 1/C NO. 6 GROUND, (XLP-TYPE USE), 1" DIA. POLYETHYLENE
- (C) UNIT DUCT, 600V, 2-1C NO. 4, 1/C NO. 4 GROUND, (XLP-TYPE USE), 1" DIA. POLYETHYLENE

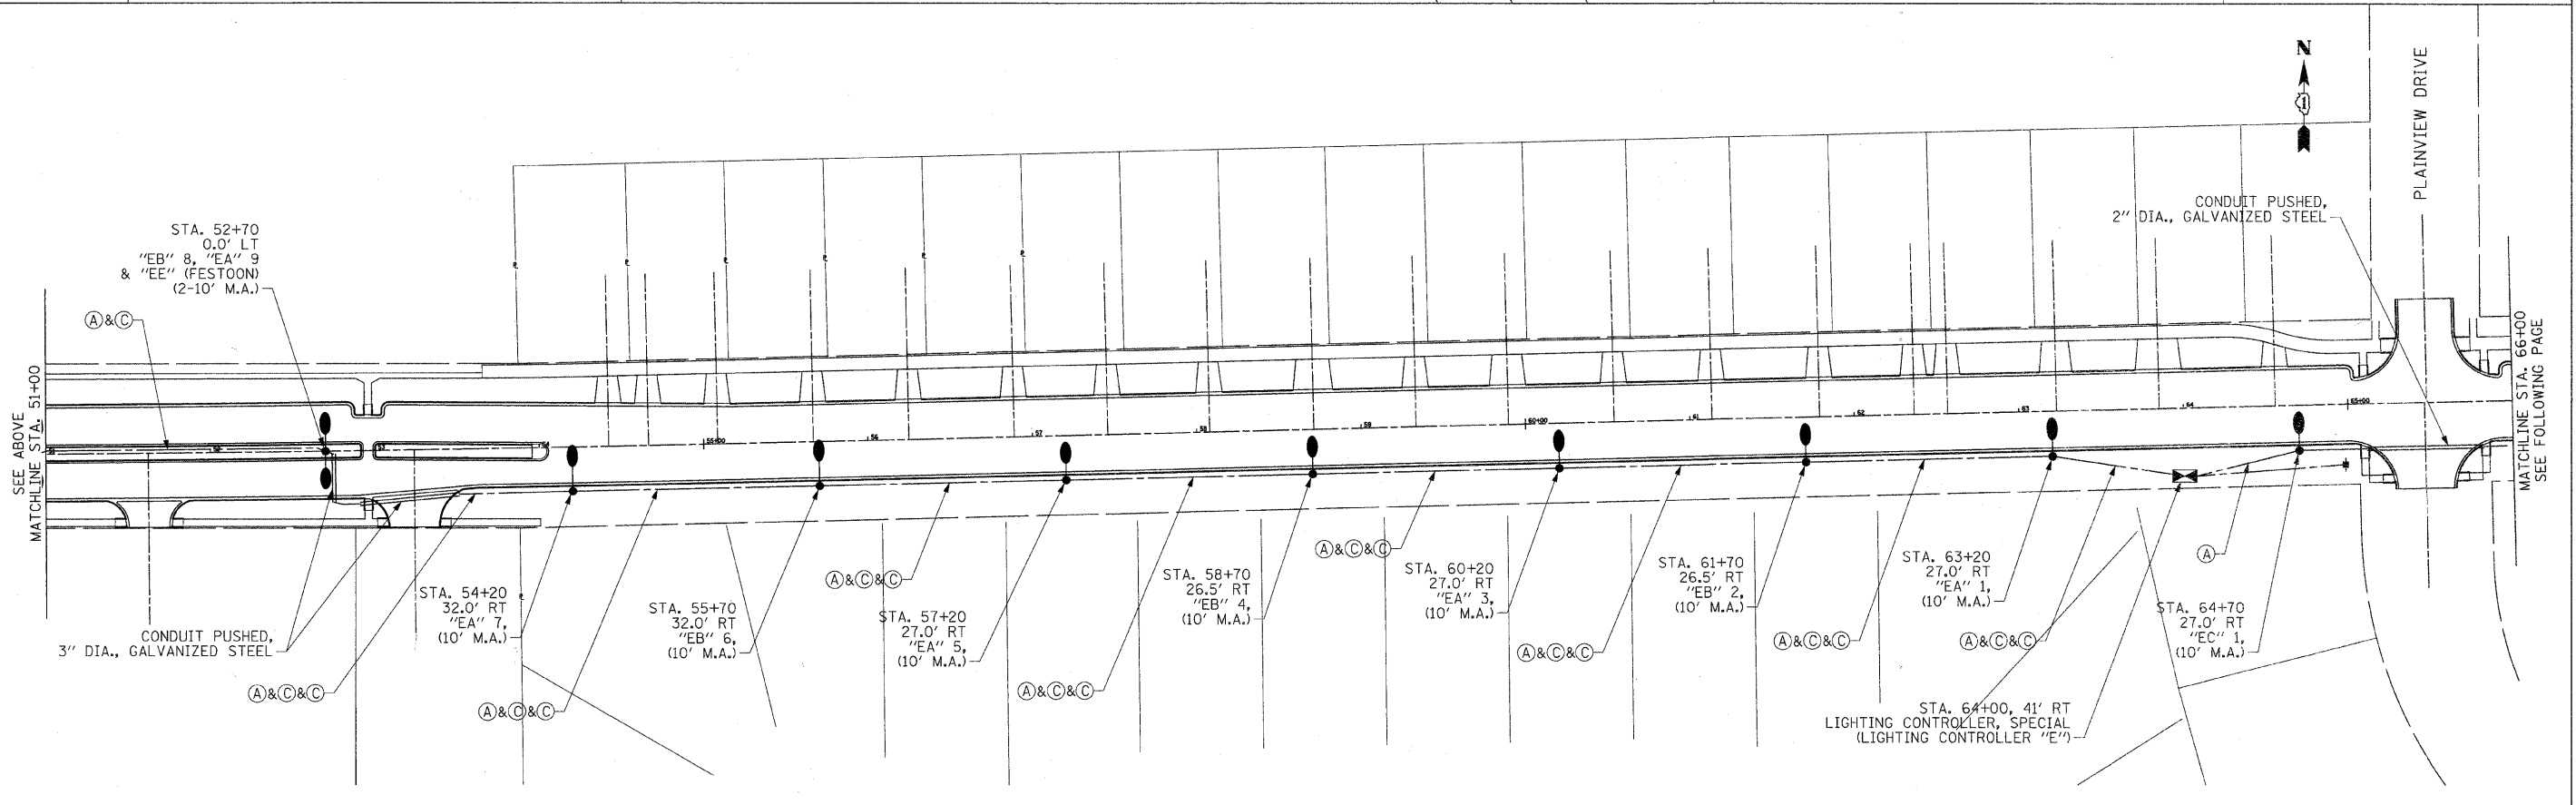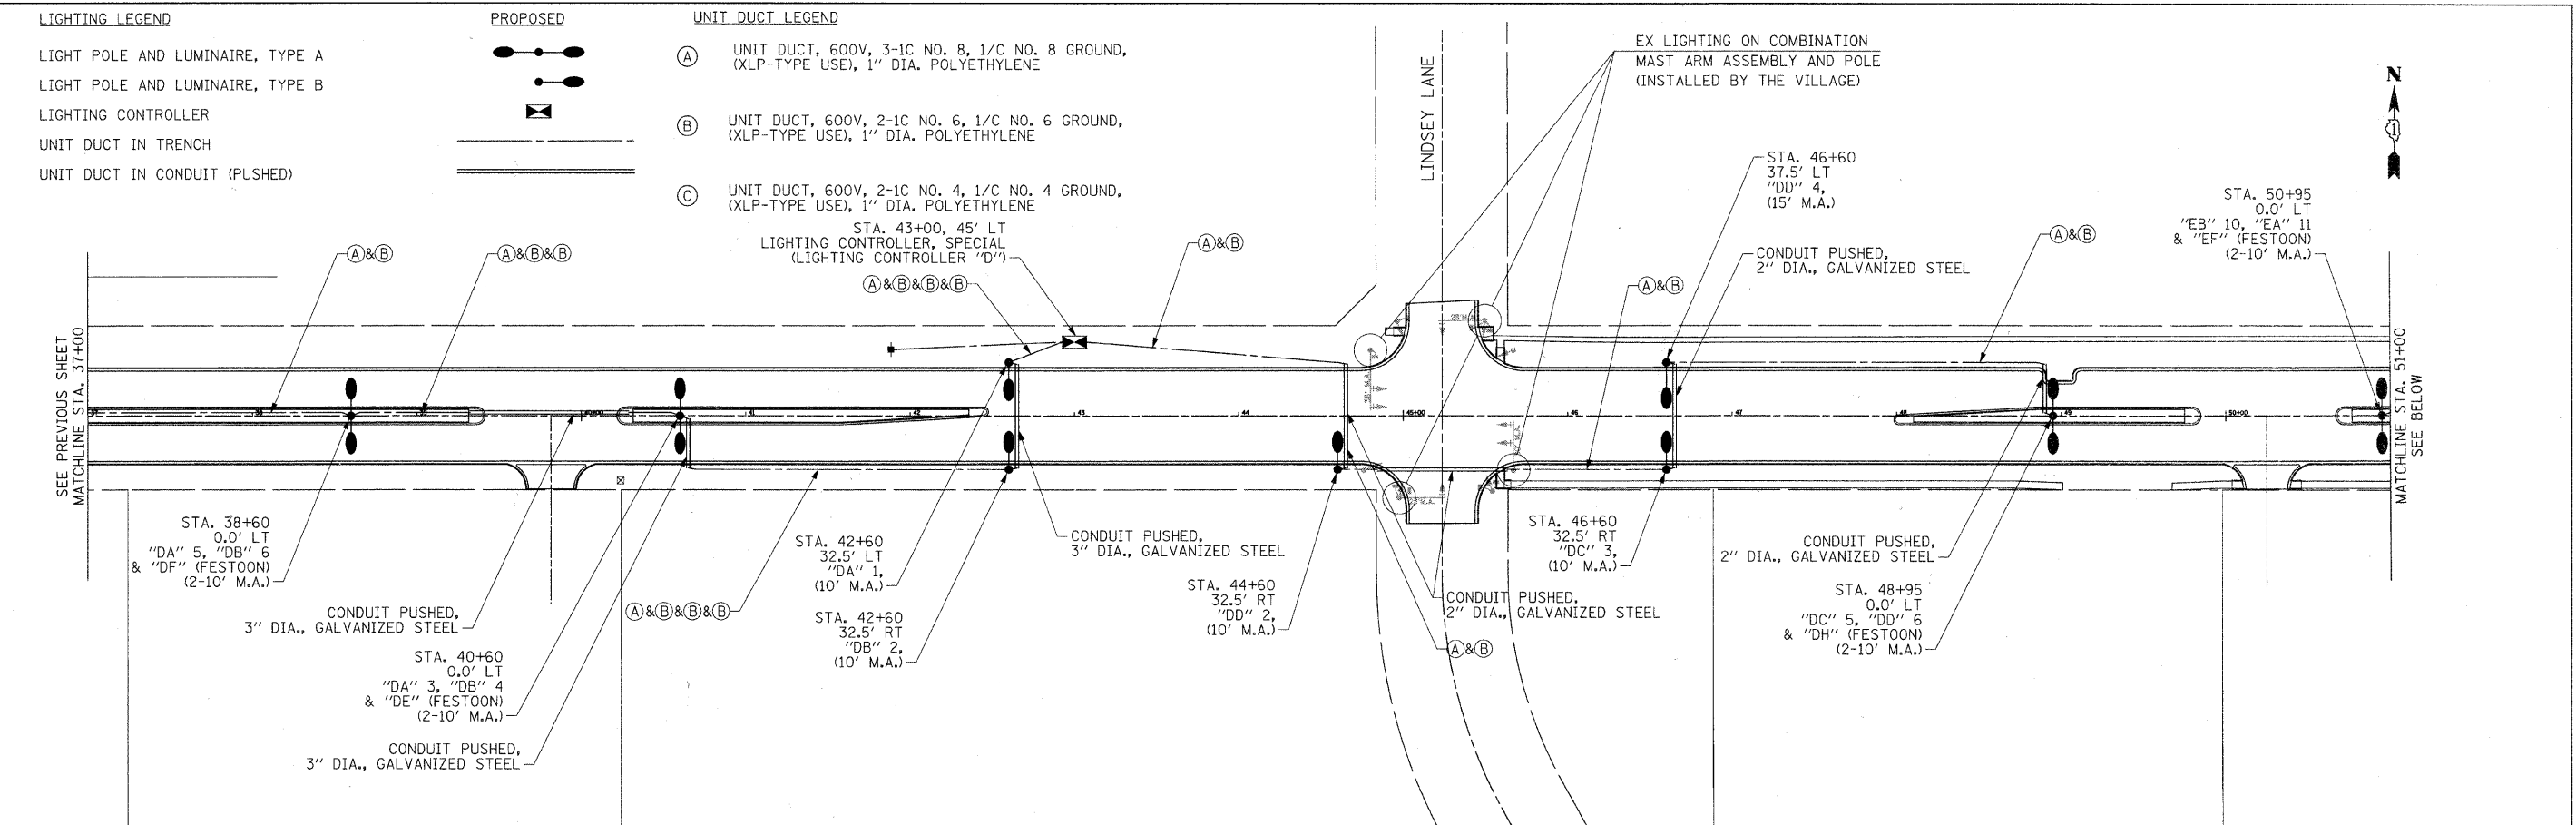

FILE NAME =	USER NAME = IE Consultants	DESIGNED -	REVISED -	STATE OF ILLINOIS DEPARTMENT OF TRANSPORTATION	LILY CACHE LANE LIGHTING PLANS	F.A.U.	SECTION	COUNTY	TOTAL SHEET NO.
GA\S09021\CADD\Sheets\TS & LIGHTING\11.LT02.dgn	DRAWN -	REVISED -	1578			06-00046-01-PV	WILL	244	201
PLOT SCALE = 50.0000' / IN.	CHECKED -	REVISED -	CONTRACT NO. 63503						
PLOT DATE = 10/22/2010	DATE -	REVISED -	ILLINOIS FED. AID PROJECT						
						SCALE:	SHEET NO. OF SHEETS	STA. TO STA.	