 


**LIGHTING LEGEND**



- LIGHT POLE AND LUMINAIRE, TYPE A
- LIGHT POLE AND LUMINAIRE, TYPE B
- LIGHTING CONTROLLER
- UNIT DUCT IN TRENCH
- UNIT DUCT IN CONDUIT (PUSHED)

**PROPOSED**



**UNIT DUCT LEGEND**

- (A) UNIT DUCT, 600V, 3-1C NO. 8, 1/C NO. 8 GROUND, (XLP-TYPE USE), 1" DIA. POLYETHYLENE
- (B) UNIT DUCT, 600V, 2-1C NO. 6, 1/C NO. 6 GROUND, (XLP-TYPE USE), 1" DIA. POLYETHYLENE
- (C) UNIT DUCT, 600V, 2-1C NO. 4, 1/C NO. 4 GROUND, (XLP-TYPE USE), 1" DIA. POLYETHYLENE

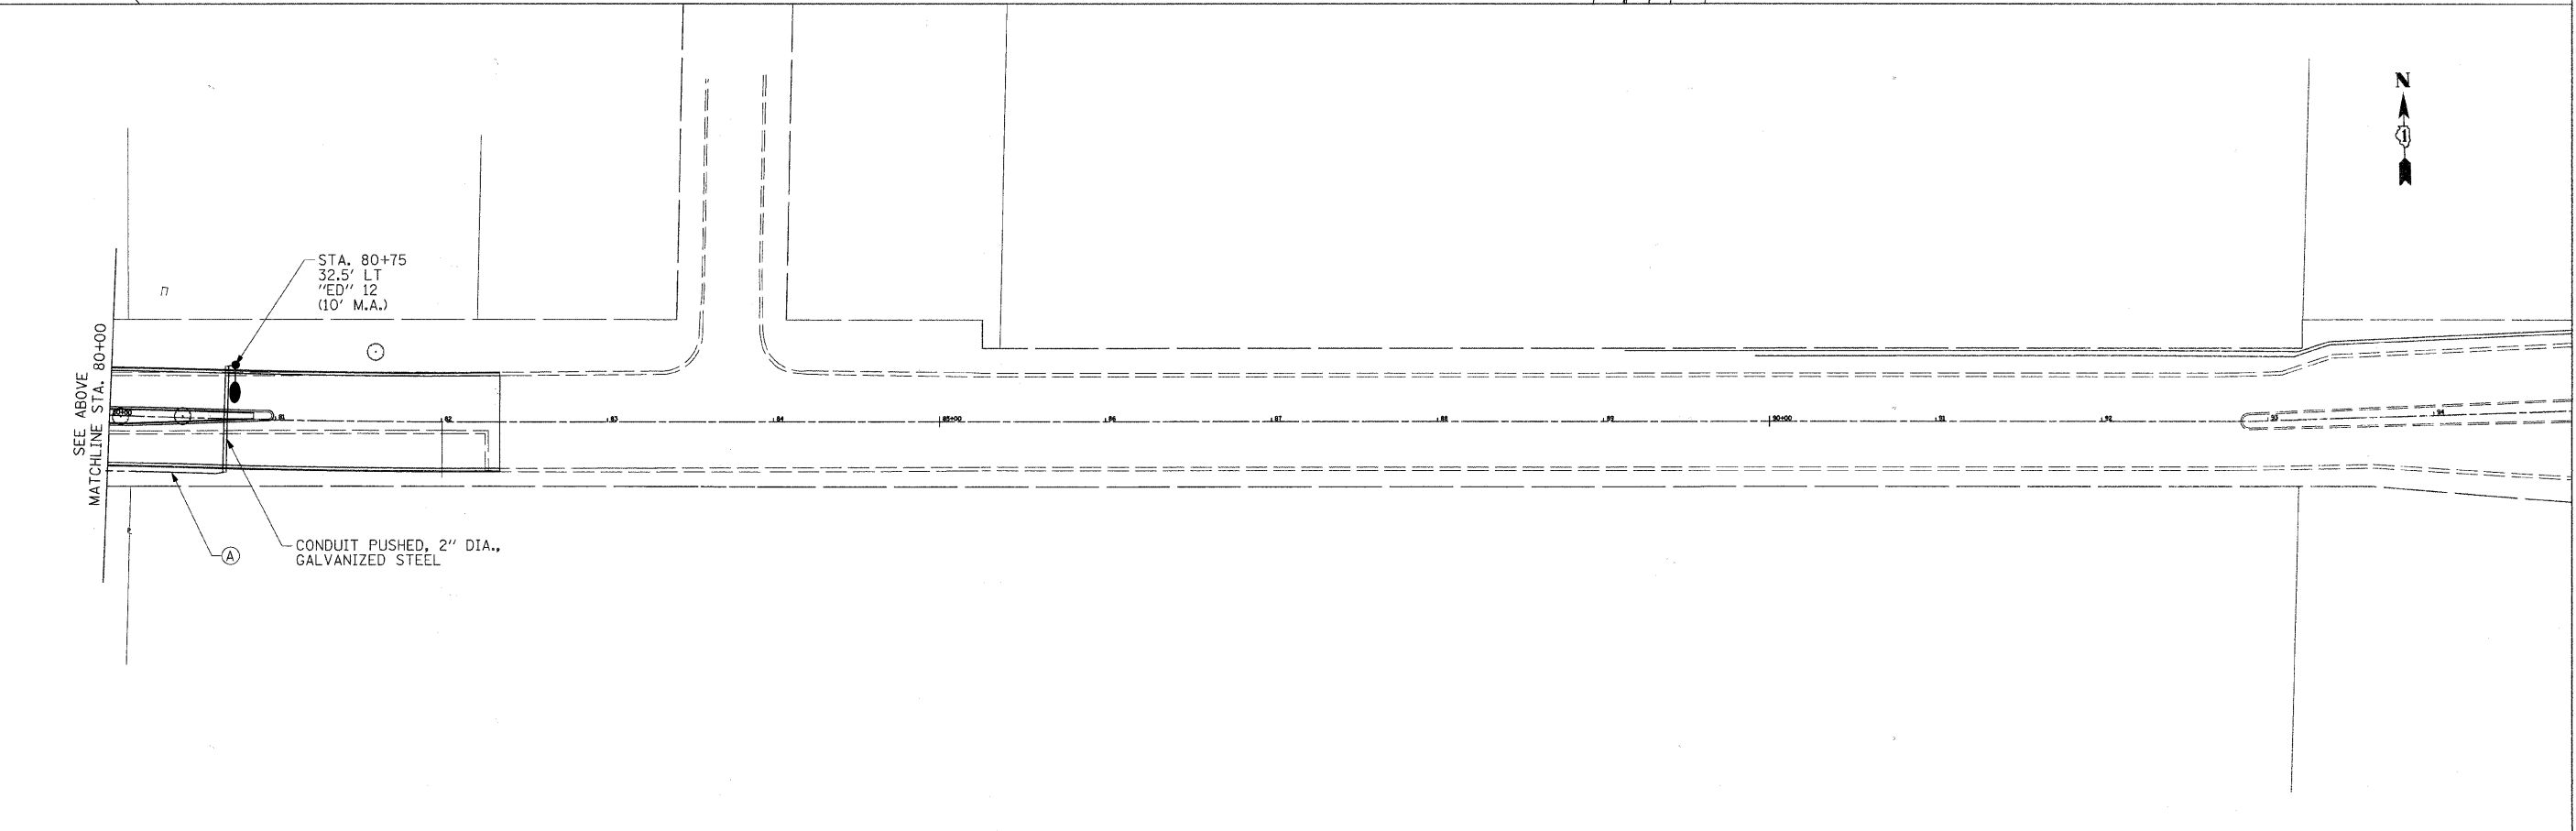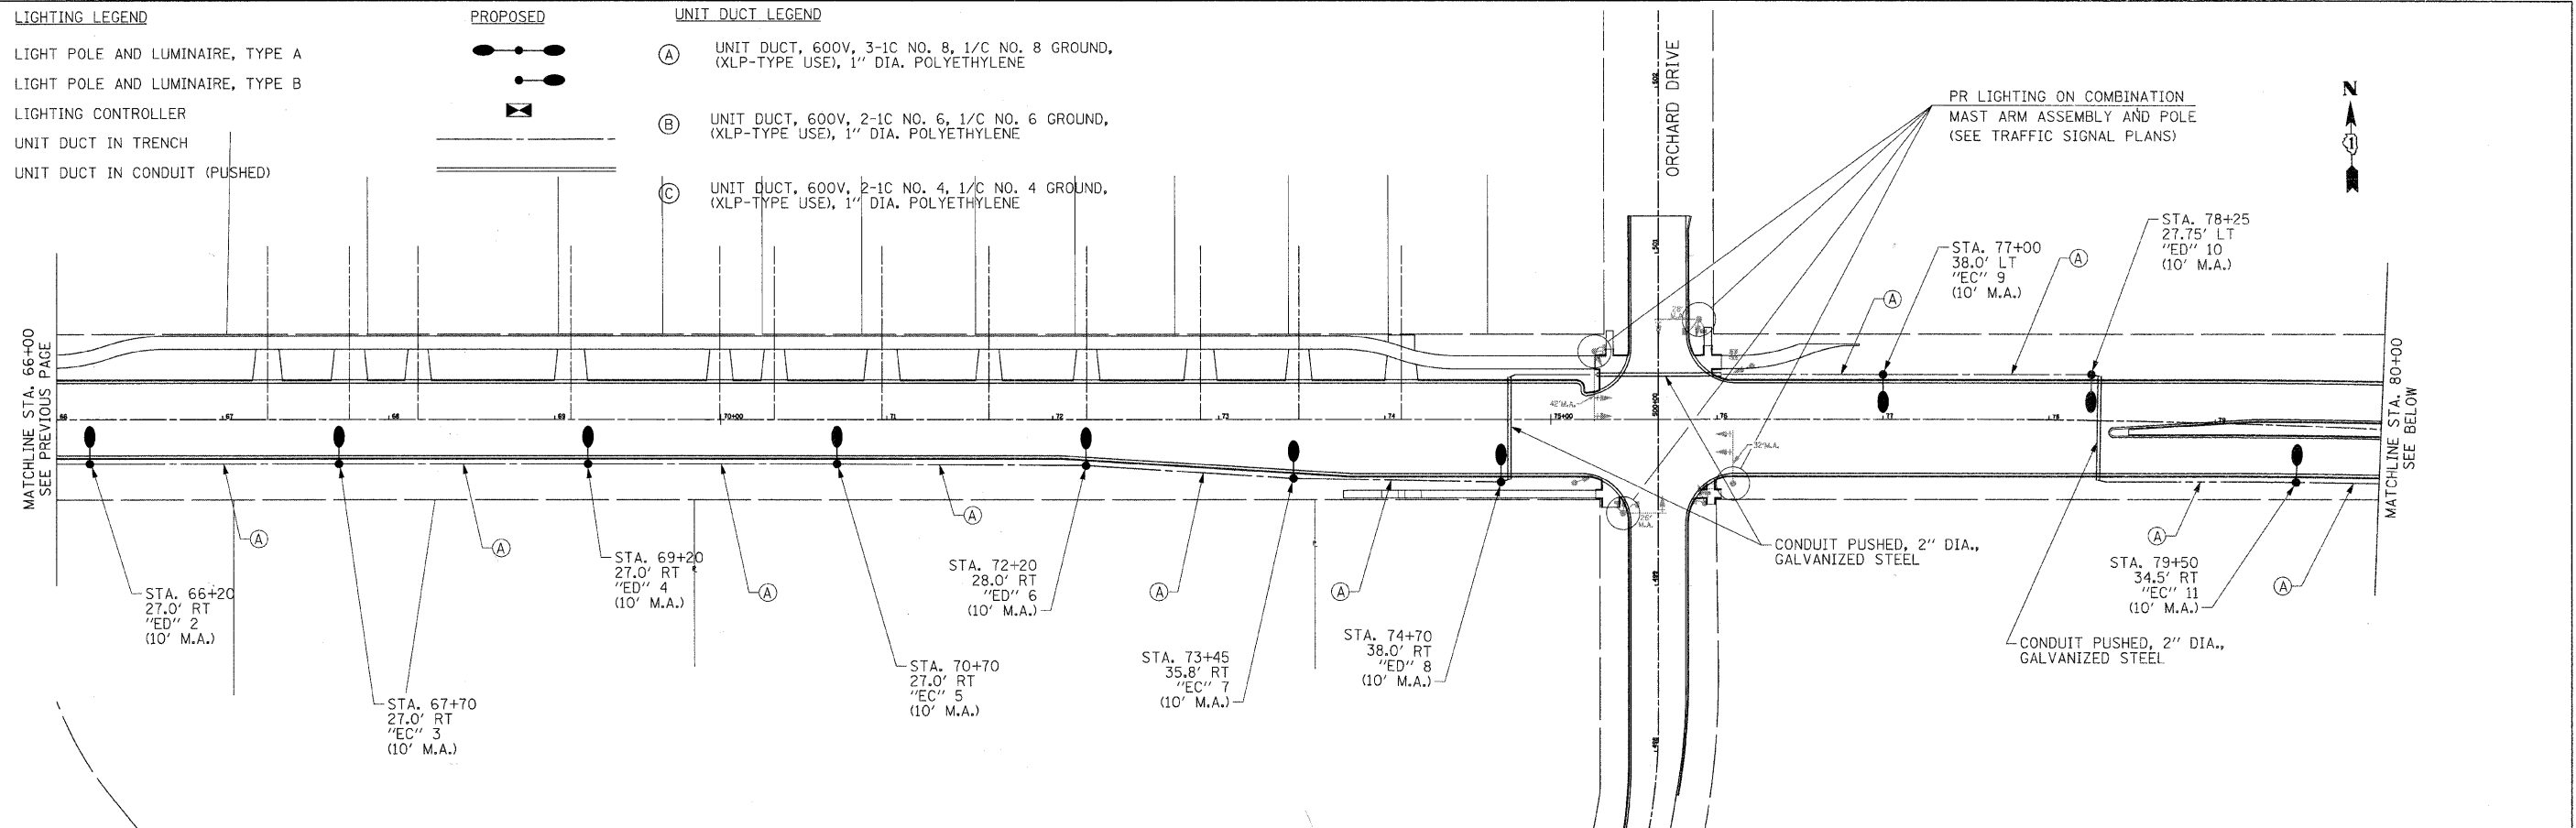

FILE NAME = G:\S09021\CADD\Sheets\TS & LIGHTING\1011.LT003.dgn	USER NAME = IE Consultants	DESIGNED -	REVISED -	<b>STATE OF ILLINOIS DEPARTMENT OF TRANSPORTATION</b>	<b>LILY CACHE LANE LIGHTING PLANS</b>			F.A.U.	SECTION	COUNTY	TOTAL SHEETS	SHEET NO.
	PLOT SCALE = 50.0000' / IN.	DRAWN -	REVISED -					1578	06-00046-01-PV	WILL	244	202
	PLOT DATE = 10/22/2010	CHECKED -	REVISED -					CONTRACT NO. 63503				
		DATE -	REVISED -					ILLINOIS FED. AID PROJECT				
SCALE:					SHEET NO.	OF	SHEETS	STA.	TO	STA.		