
 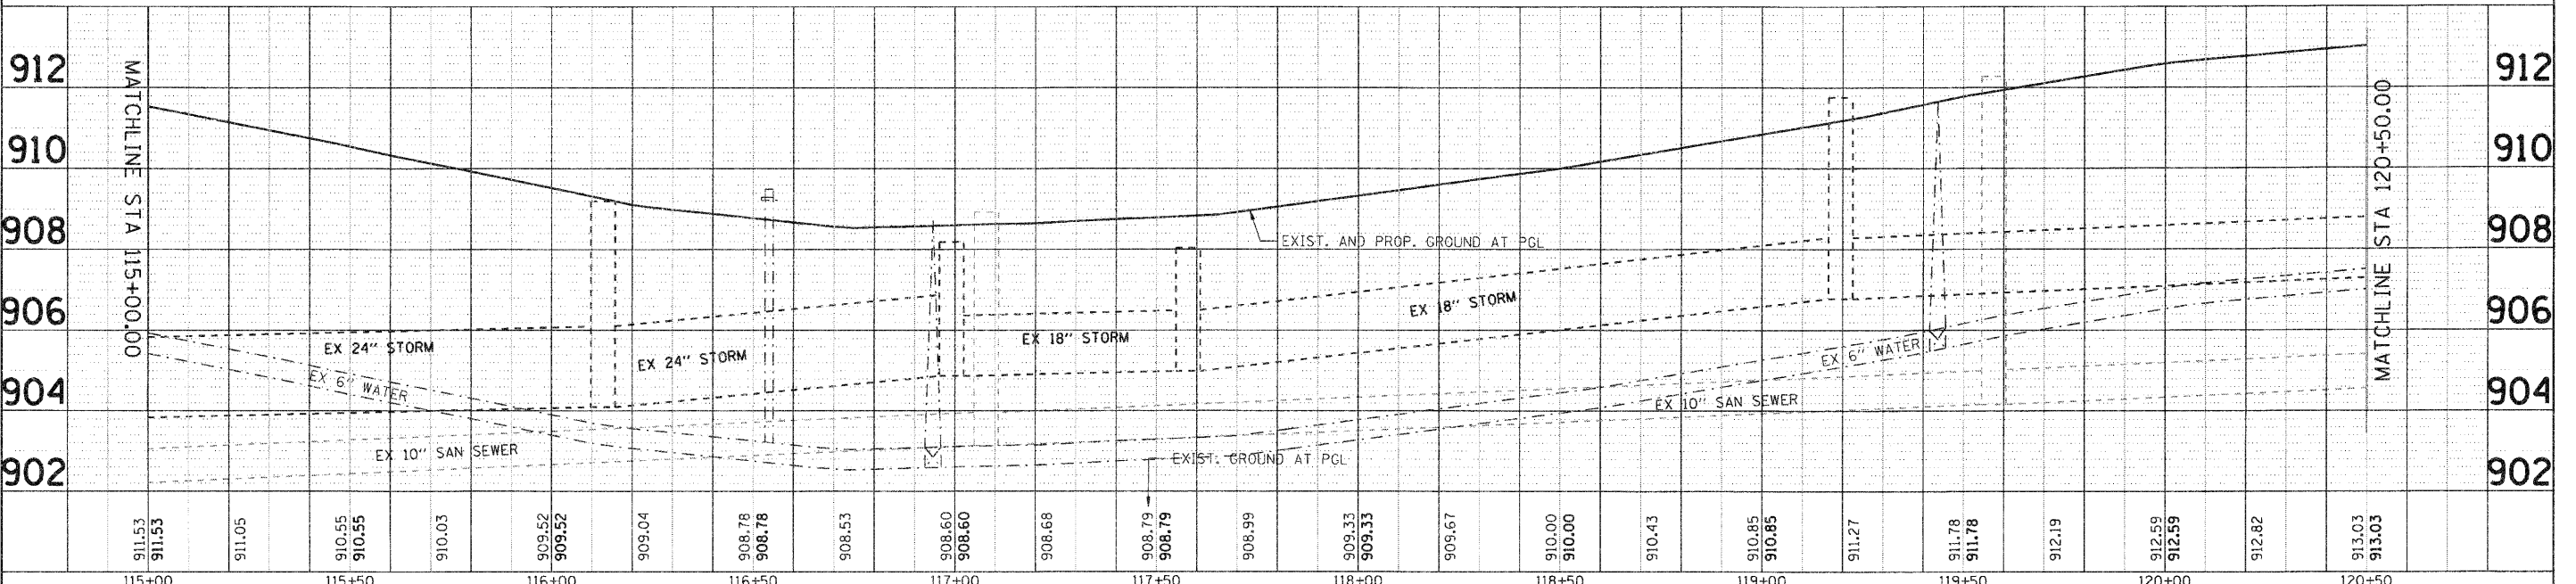



PLAN	SURVEYED	DATE
	PLOTTED	
	NOTED	
	REVISIONS	
	FILE NAME	
	FILE NO.	
	FILE DATE	
	FILE TIME	
	FILE USER	
	FILE PATH	
	FILE SIZE	
	FILE TYPE	
	FILE EXTENSION	
	FILE CONTENTS	
	FILE PERMISSIONS	
	FILE ATTRIBUTES	
	FILE METADATA	
	FILE COMMENTS	
	FILE HISTORY	
	FILE LOG	
	FILE SUMMARY	
	FILE INDEX	
	FILE TOOLS	
	FILE SERVICES	
	FILE SUPPORT	
	FILE HELP	
	FILE ABOUT	

PROFILE	SURVEYED	DATE
	PLOTTED	
	NOTED	
	REVISIONS	
	FILE NAME	
	FILE NO.	
	FILE DATE	
	FILE TIME	
	FILE USER	
	FILE PATH	
	FILE SIZE	
	FILE TYPE	
	FILE EXTENSION	
	FILE CONTENTS	
	FILE PERMISSIONS	
	FILE ATTRIBUTES	
	FILE METADATA	
	FILE COMMENTS	
	FILE HISTORY	
	FILE LOG	
	FILE SUMMARY	
	FILE INDEX	
	FILE TOOLS	
	FILE SERVICES	
	FILE SUPPORT	
	FILE HELP	
	FILE ABOUT	

COMPANY NAME: SEC GROUP, INC.
 PROJECT CONTACT: A. JAIN
 PROJECT ADDRESS: VILLAGE OF CARPENTERSVILLE
 CLIENT: VILLAGE OF CARPENTERSVILLE
 FILE NAME: 06-00074-00-FP
 FILE NO.: 06-00074-00-FP
 FILE DATE: 11/1/2010
 FILE TIME: 11:11:11
 FILE USER: a.jain
 FILE PATH: c:\projects\06-00074-00-FP\06-00074-00-FP.dwg
 FILE SIZE: 1000000
 FILE TYPE: DWG
 FILE EXTENSION: .dwg
 FILE CONTENTS: DRAINAGE AND UTILITY PLAN AND PROFILE
 FILE PERMISSIONS: RW-
 FILE ATTRIBUTES: Standard-Trans.tbl
 FILE METADATA: SEC GROUP, INC.
 FILE COMMENTS: DRAINAGE AND UTILITY PLAN AND PROFILE
 FILE HISTORY: 11/1/2010 11:11:11 A. JAIN
 FILE LOG: 11/1/2010 11:11:11 A. JAIN
 FILE SUMMARY: DRAINAGE AND UTILITY PLAN AND PROFILE
 FILE INDEX: DRAINAGE AND UTILITY PLAN AND PROFILE
 FILE TOOLS: DRAINAGE AND UTILITY PLAN AND PROFILE
 FILE SERVICES: DRAINAGE AND UTILITY PLAN AND PROFILE
 FILE SUPPORT: DRAINAGE AND UTILITY PLAN AND PROFILE
 FILE HELP: DRAINAGE AND UTILITY PLAN AND PROFILE
 FILE ABOUT: DRAINAGE AND UTILITY PLAN AND PROFILE

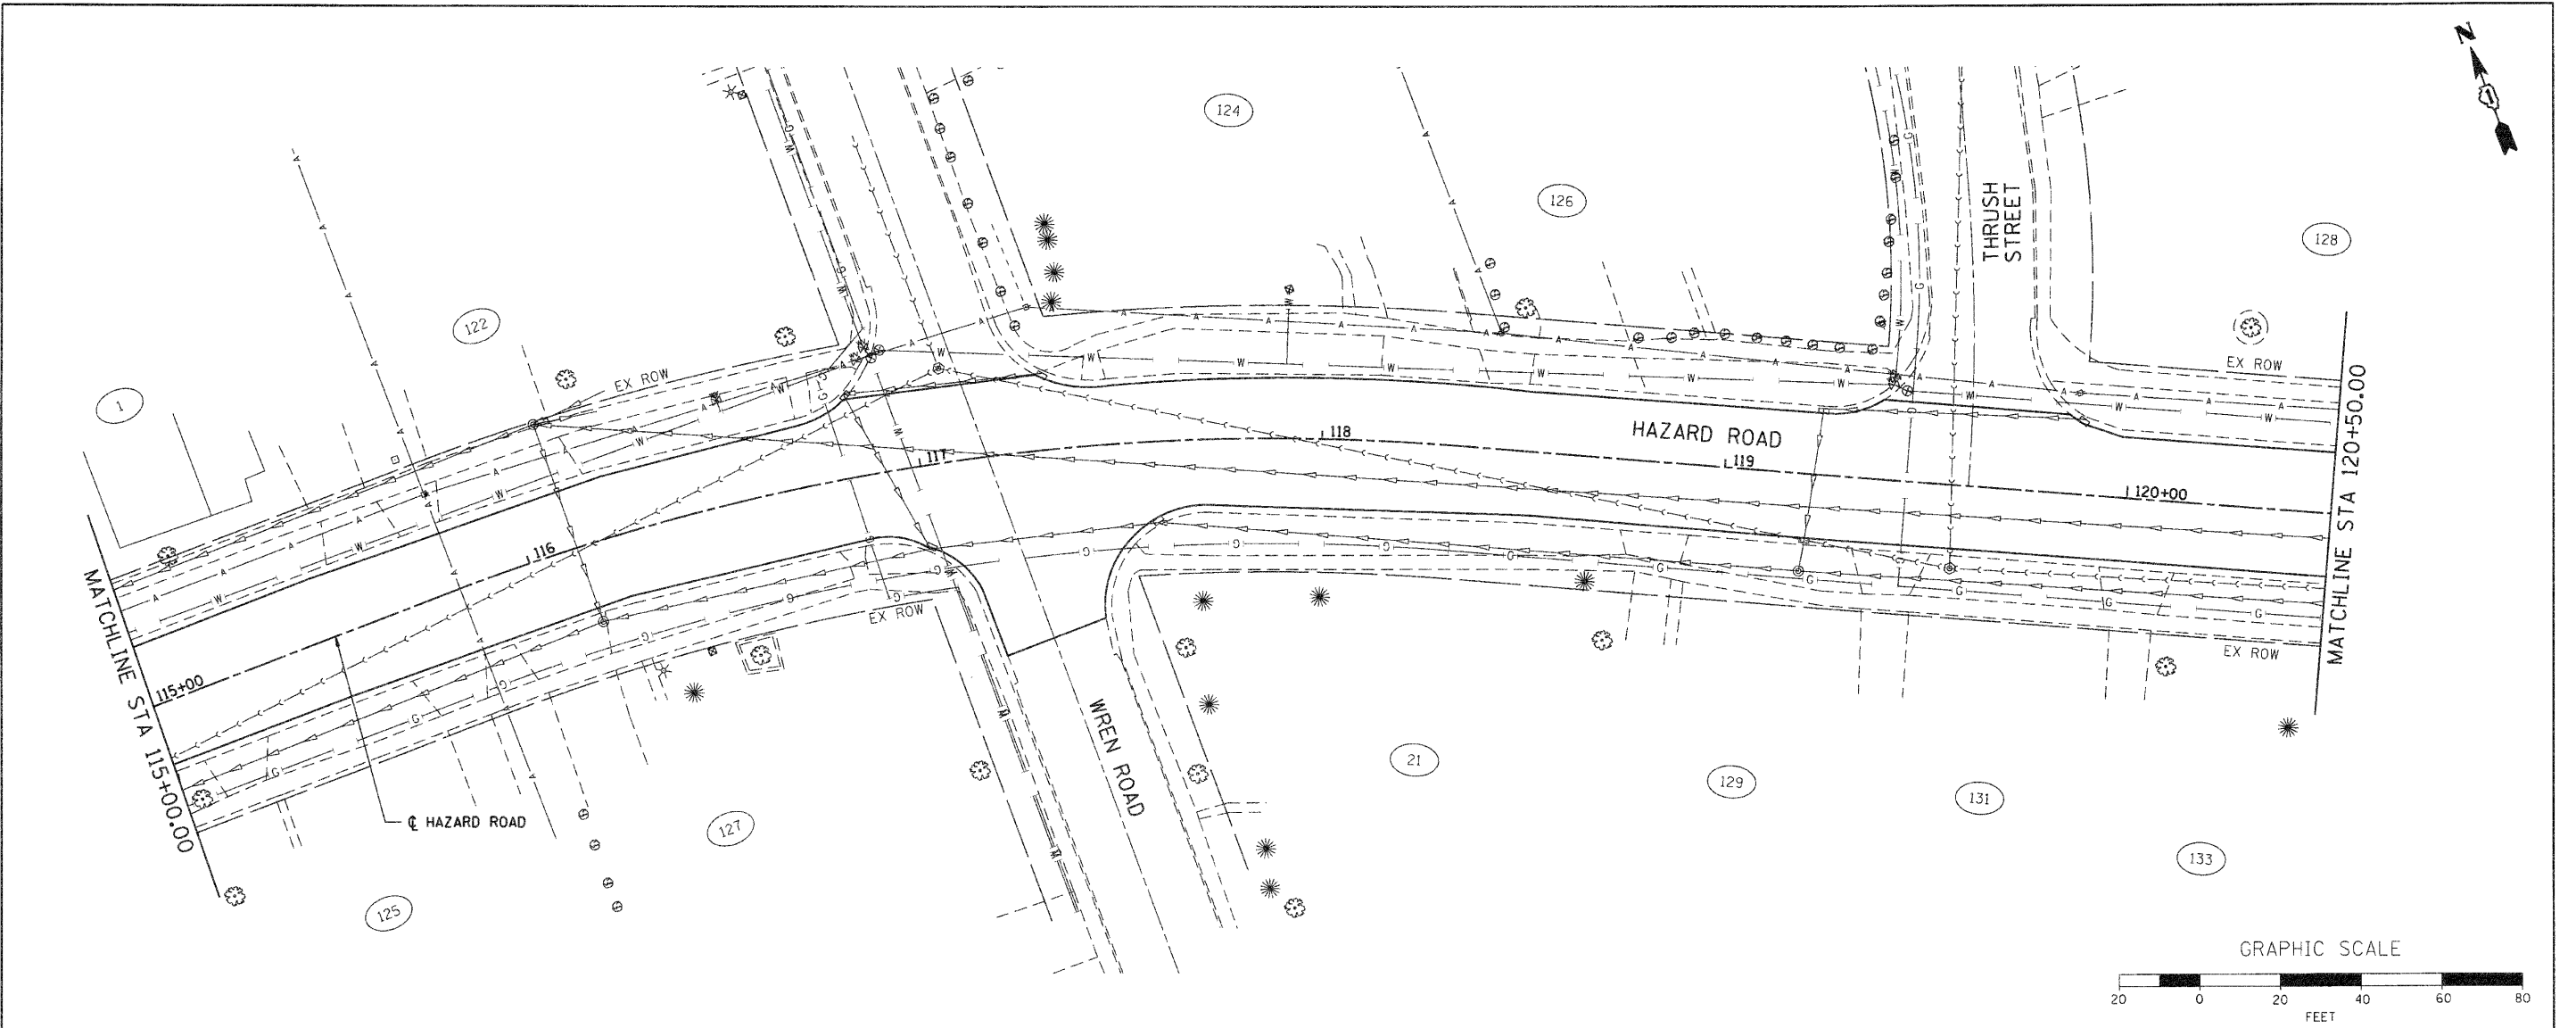

115+00	115+50	116+00	116+50	117+00	117+50	118+00	118+50	119+00	119+50	120+00	120+50																						
911.53	911.05	910.55	910.55	910.03	909.52	909.52	909.04	908.78	908.78	908.53	908.60	908.60	908.68	908.79	908.79	908.99	909.33	909.33	909.67	910.00	910.00	910.43	910.85	910.85	911.27	911.78	911.78	912.19	912.59	912.59	912.82	913.03	913.03

DESIGNED - A. JAIN	REVISIONS -
DRAWN - S. PERNAL	REVISIONS -
CHECKED - T. HAMILTON	REVISIONS -
DATE - 10/25/10	REVISIONS -

SEC Group, Inc.	USER NAME - C:\or-tkx
401 N. First Street Moline, IL 61905-2138 TEL: 309.246.1778 FAX: 309.246.1781 www.secgroup.com	
PLOT SCALE = 1" = 20'	
PLOT DATE = 11/1/2010	

VILLAGE OF CARPENTERSVILLE	DRAINAGE AND UTILITY PLAN AND PROFILE
	HAZARD ROAD
SCALE: 1" = 20'	SHEET NO. 3 OF 21 SHEETS
STA. 115+00	TO STA. 120+50

F.A. RTE.	SECTION	COUNTY	TOTAL SHEETS	SHEET NO.
	06-00074-00-FP	KANE	211	51
	FAU 2414, FAU 1280, FAP 343			CONTRACT NO. 63504
	FED. ROAD DIST. NO. (ILLINOIS) FED. AID PROJECT			