
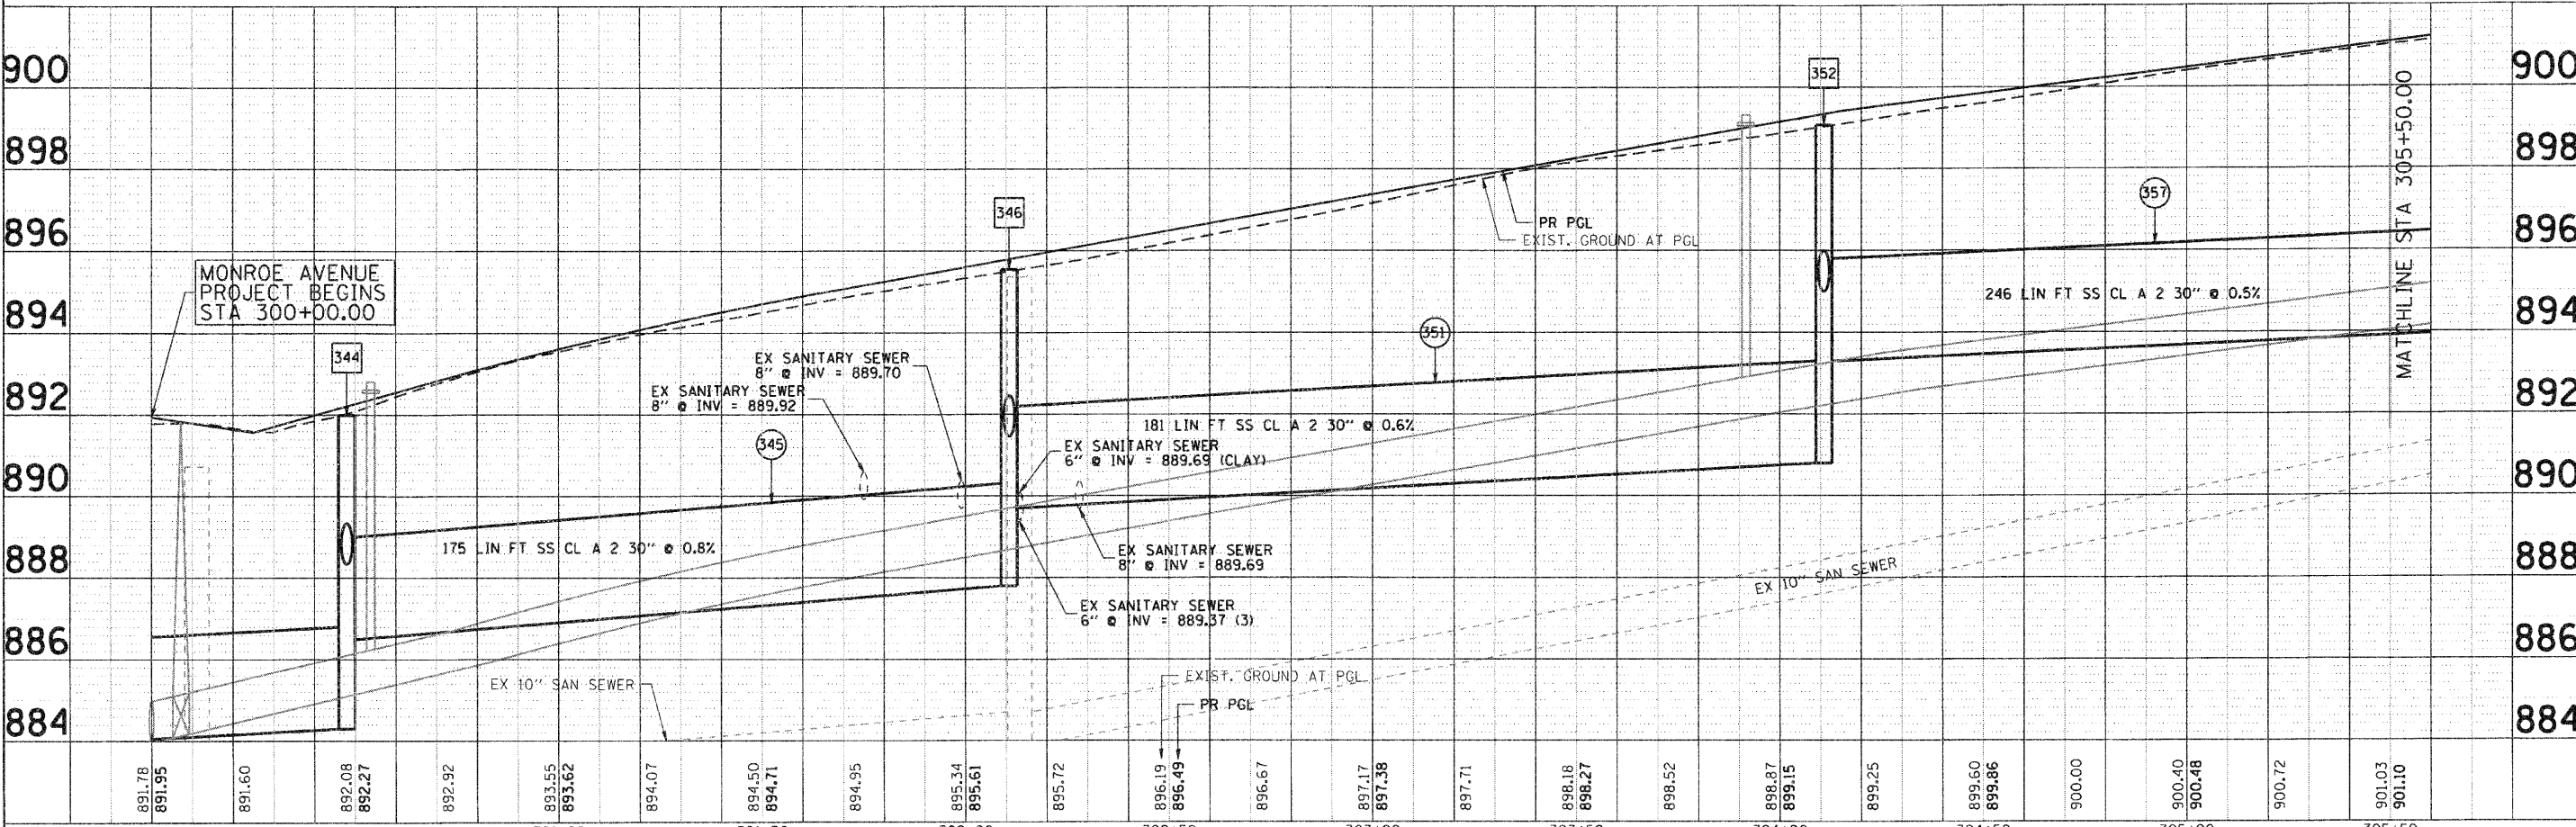


DATE	
BY	
PLAN	
DATE	
BY	
PROFILE	
DATE	
BY	

DATE	
BY	
PROFILE	
DATE	
BY	

COMPANY NAME: SEC GROUP, INC.
 PROJECT CONTACT: A. JAIN
 PROJECT: VILLAGE OF CARPENTERSVILLE
 DATE PLOTTED: 11/17/2010 5:57:59 PM
 PLOT SCALE: 1" = 20'
 PLOT DATE: 11/17/2010
 PEN TABLE: standard-trans.tbl

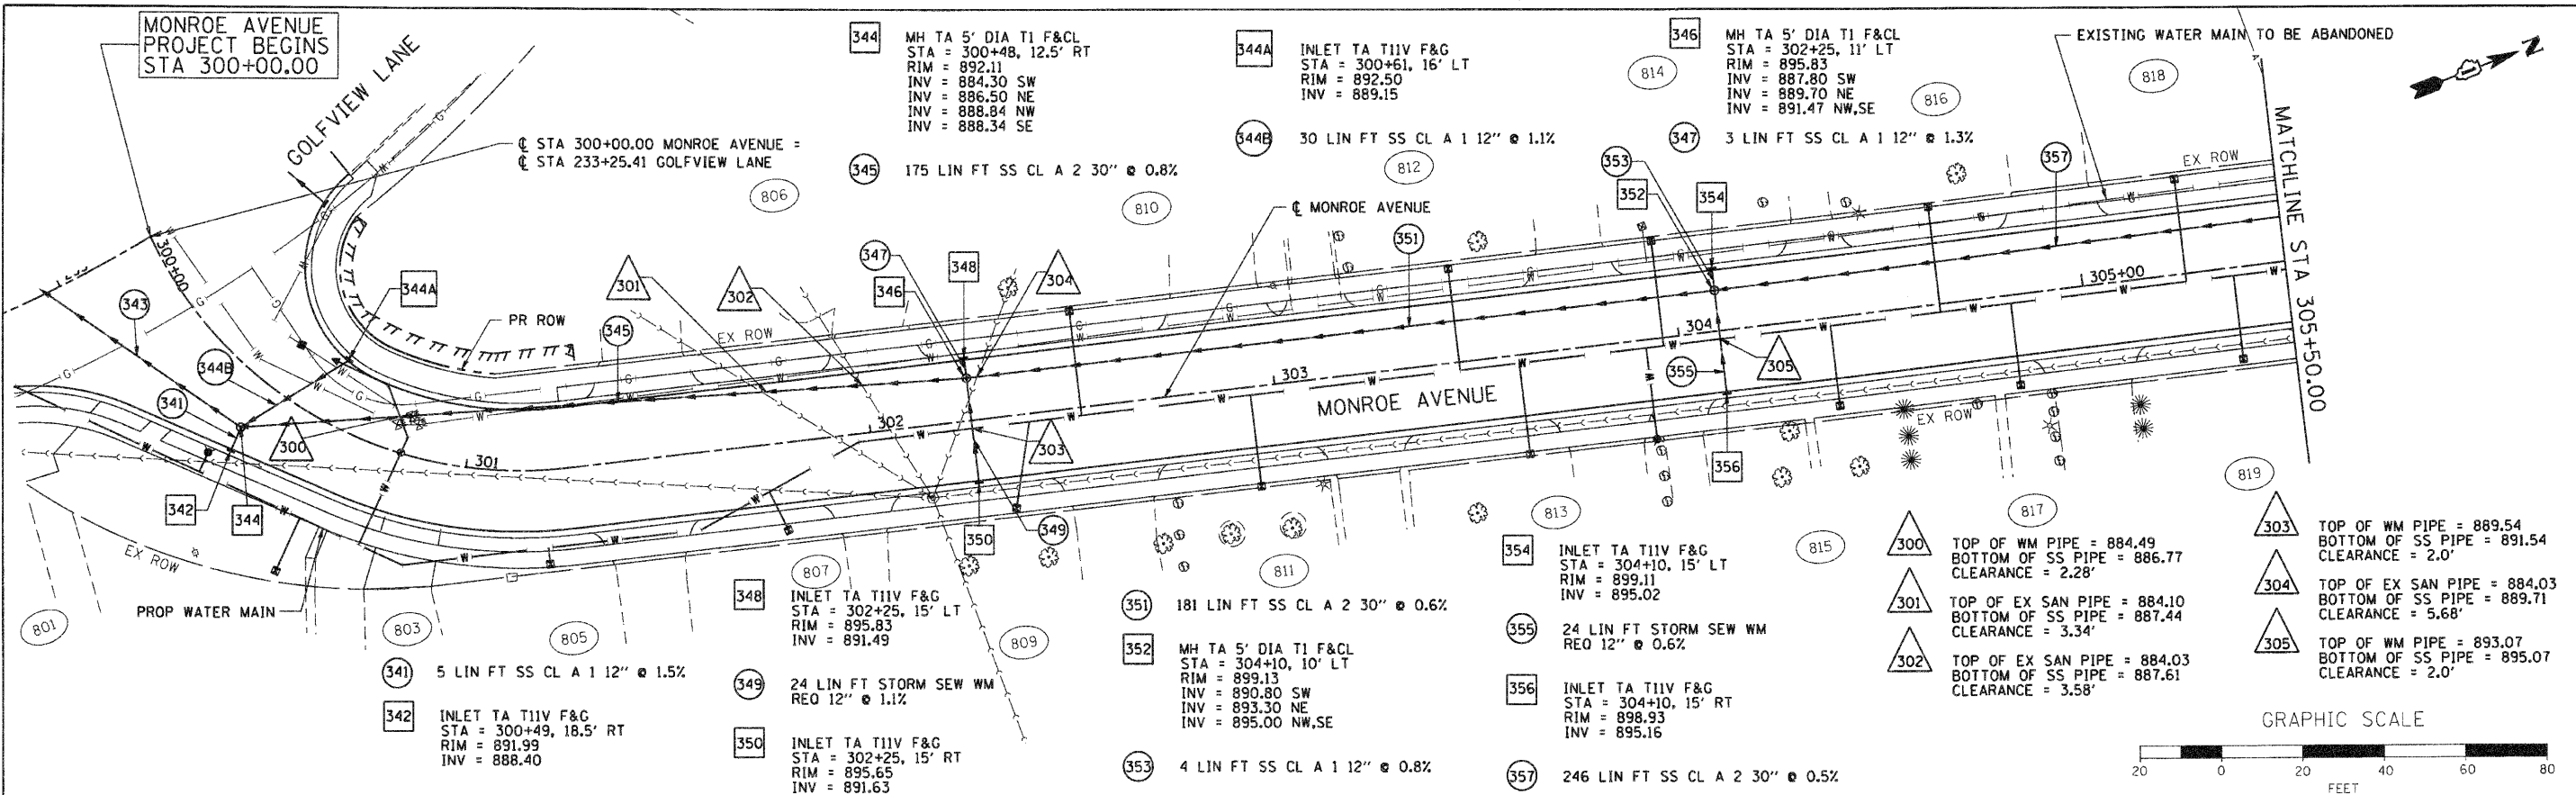

		USER NAME = CHar-tke PLOT SCALE = 1" = 20' PLOT DATE = 11/17/2010	DESIGNED - A. JAIN DRAWN - S. PERNAL CHECKED - T. HAMILTON DATE - 10/25/10	REVISED - REVISED - REVISED - REVISED -	VILLAGE OF CARPENTERSVILLE DRAINAGE AND UTILITY PLAN AND PROFILE MONROE AVENUE	SECTION 06-00074-00-FP COUNTY KANE TOTAL SHEETS 211 SHEET NO. 61	F.A. RTE. FAU 2414, FAU 1280, FAP 343 CONTRACT NO. 63504
--	--	---	---	--	---	---	---

C:\31-34-01
 11/17/2010 5:57:59 PM
 060226-00p-1.dgn