
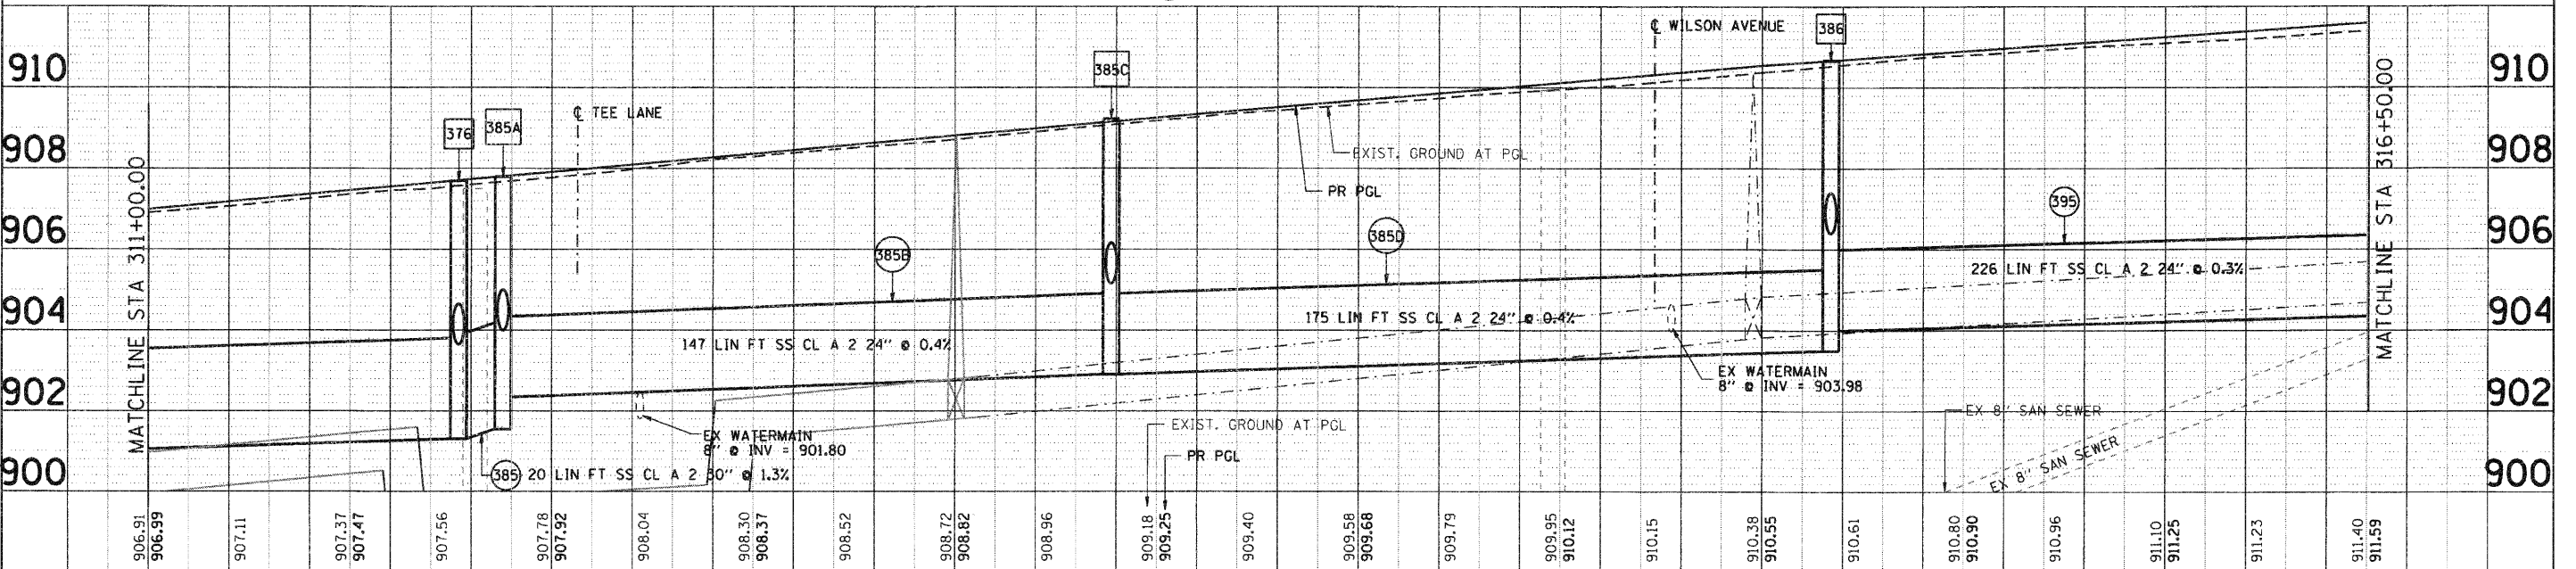


| | |
|------|---------------------|
| DATE | |
| BY | |
| PLAN | SURVEYED |
| | PLOTTED |
| | PERFORMED |
| | REL. OF WAY CHECKED |
| | NO. _____ |
| | CADD FILE NAME |

| | |
|---------|-----------------------------|
| DATE | |
| BY | |
| PROFILE | SURVEYED |
| | PLOTTED |
| | PERFORMED |
| | REVISIONS CHECKED |
| | NO. _____ |
| | STRUCTURE NOTATIONS CHECKED |

SEC GROUP, INC.
 A. JAIN
 VILLAGE OF CARPENTERSVILLE
 1115 S. MONROE STREET
 CARPENTERSVILLE, IL 61813
 618-241-1200
 www.secgroup.com

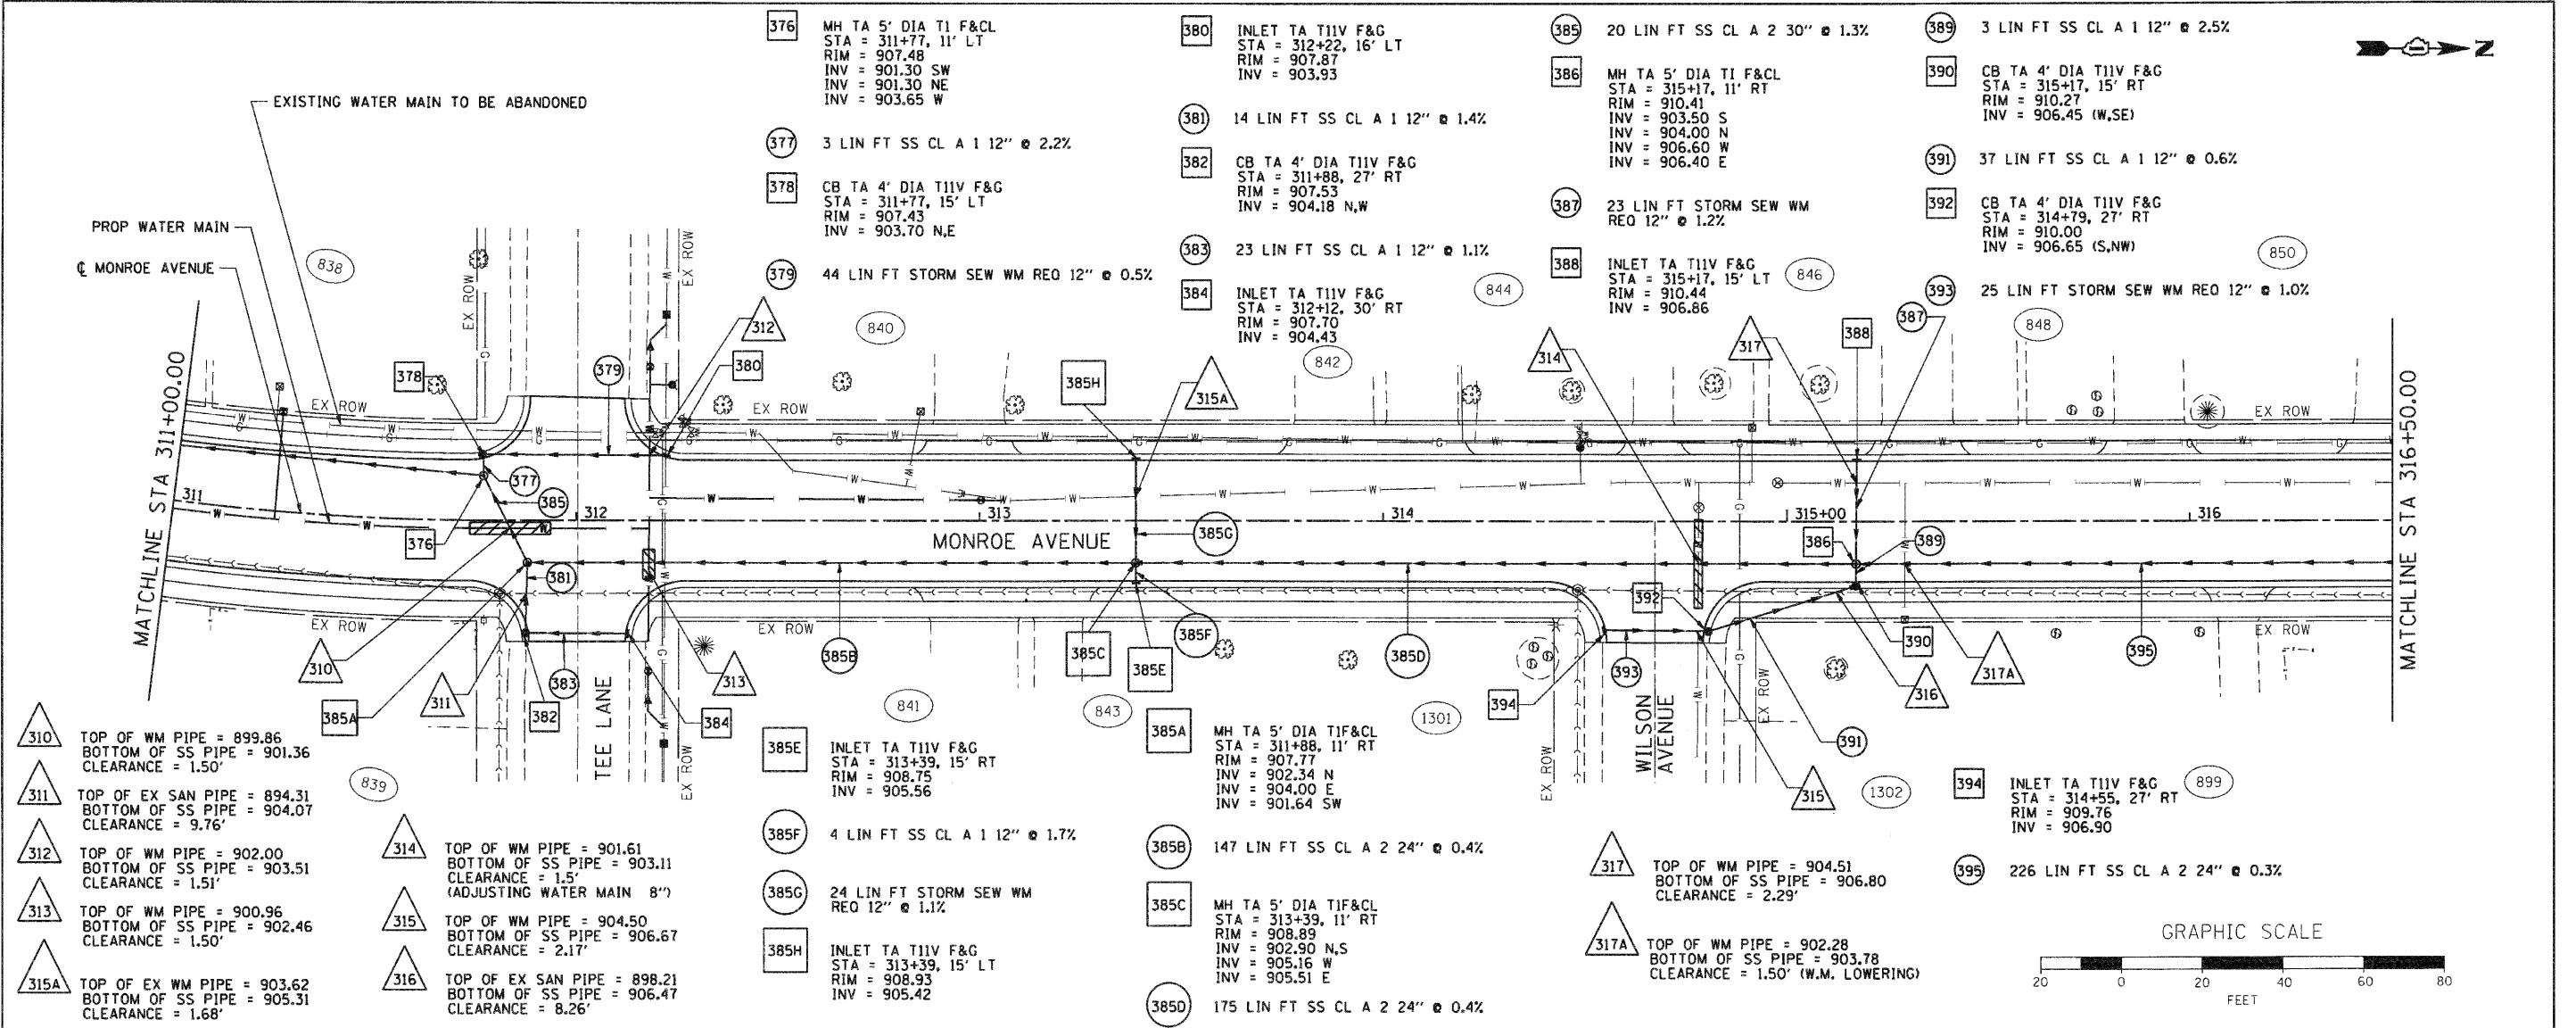

| | | | |
|---|--|--|---|
| DESIGNED - A. JAIN DRAWN - S. PERNAL CHECKED - T. HAMILTON DATE - 10/25/10 | REVISED - REVISED - REVISED - REVISED - | VILLAGE OF CARPENTERSVILLE DRAINAGE AND UTILITY PLAN AND PROFILE MONROE AVENUE | SECTION 06-00074-00-PP COUNTY KANE TOTAL SHEETS 211 SHEET NO. 63 |
|---|--|--|---|