
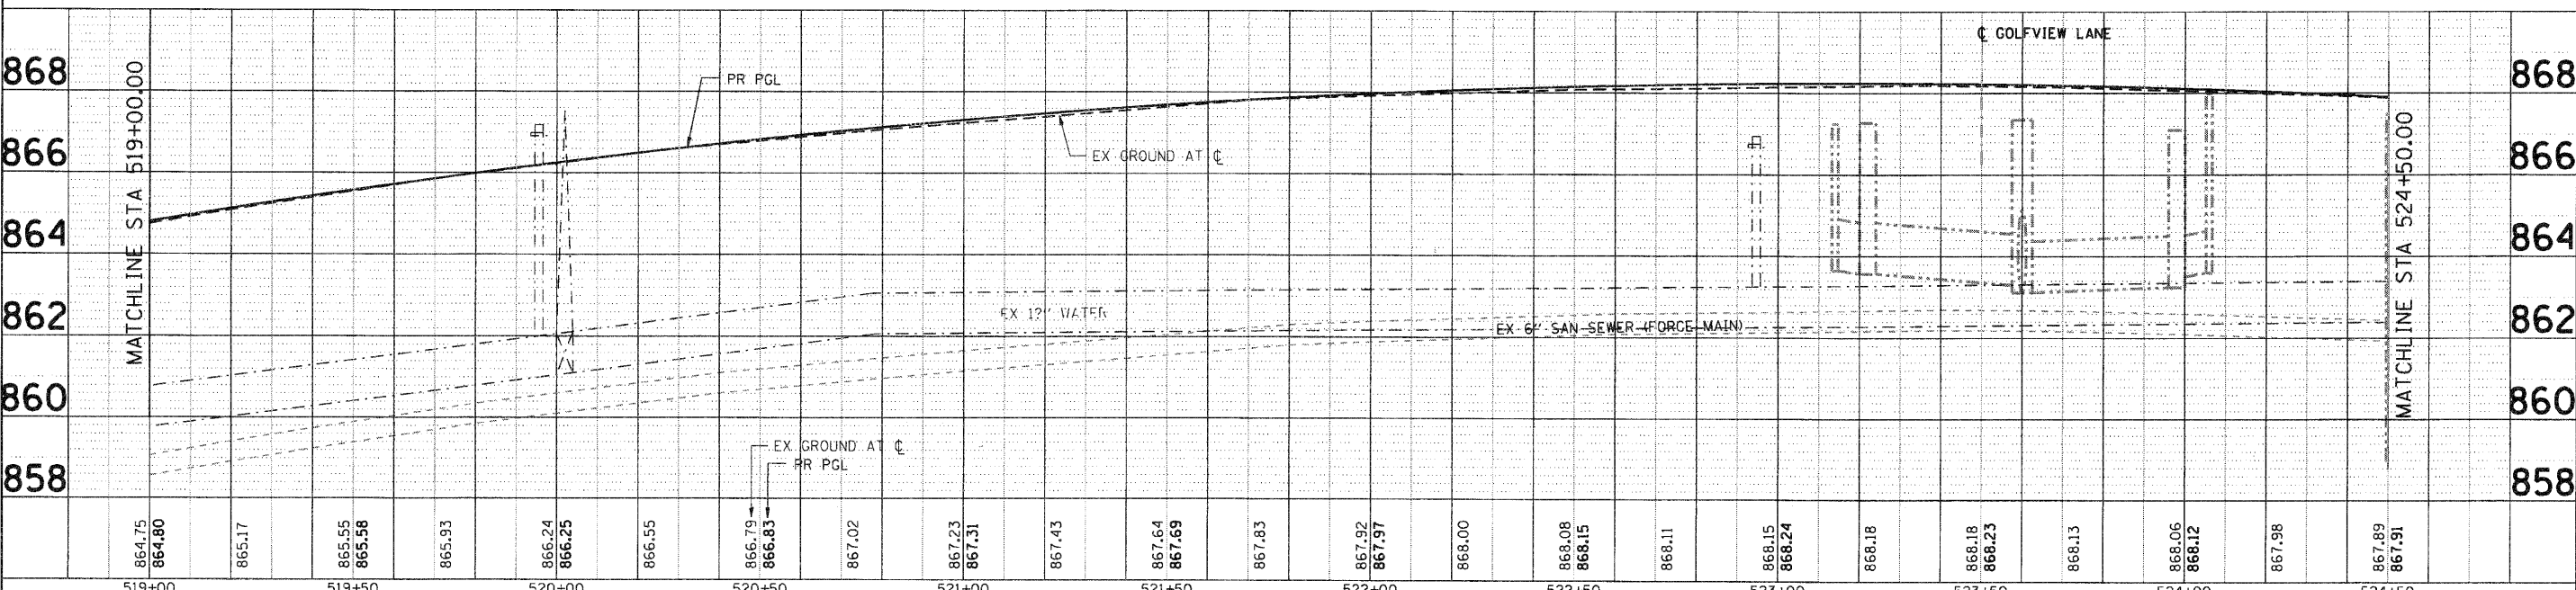


DATE	
BY	
REVISIONS	
NO.	
DATE	
BY	
REVISIONS	
NO.	
DATE	
BY	
REVISIONS	
NO.	

DATE	
BY	
REVISIONS	
NO.	
DATE	
BY	
REVISIONS	
NO.	
DATE	
BY	
REVISIONS	
NO.	

COMPANY NAME: SEC GROUP, INC.
 PROJECT CONTACT: A. JAIN
 CLIENT: VILLAGE OF CARPENTERSVILLE
 CLIENT ADDRESS: 2001 HURON AVENUE
 CITY: CARPENTERSVILLE, IL 61813
 PHONE: 618-241-1800
 FAX: 618-241-1801
 WWW: www.secgroup.com

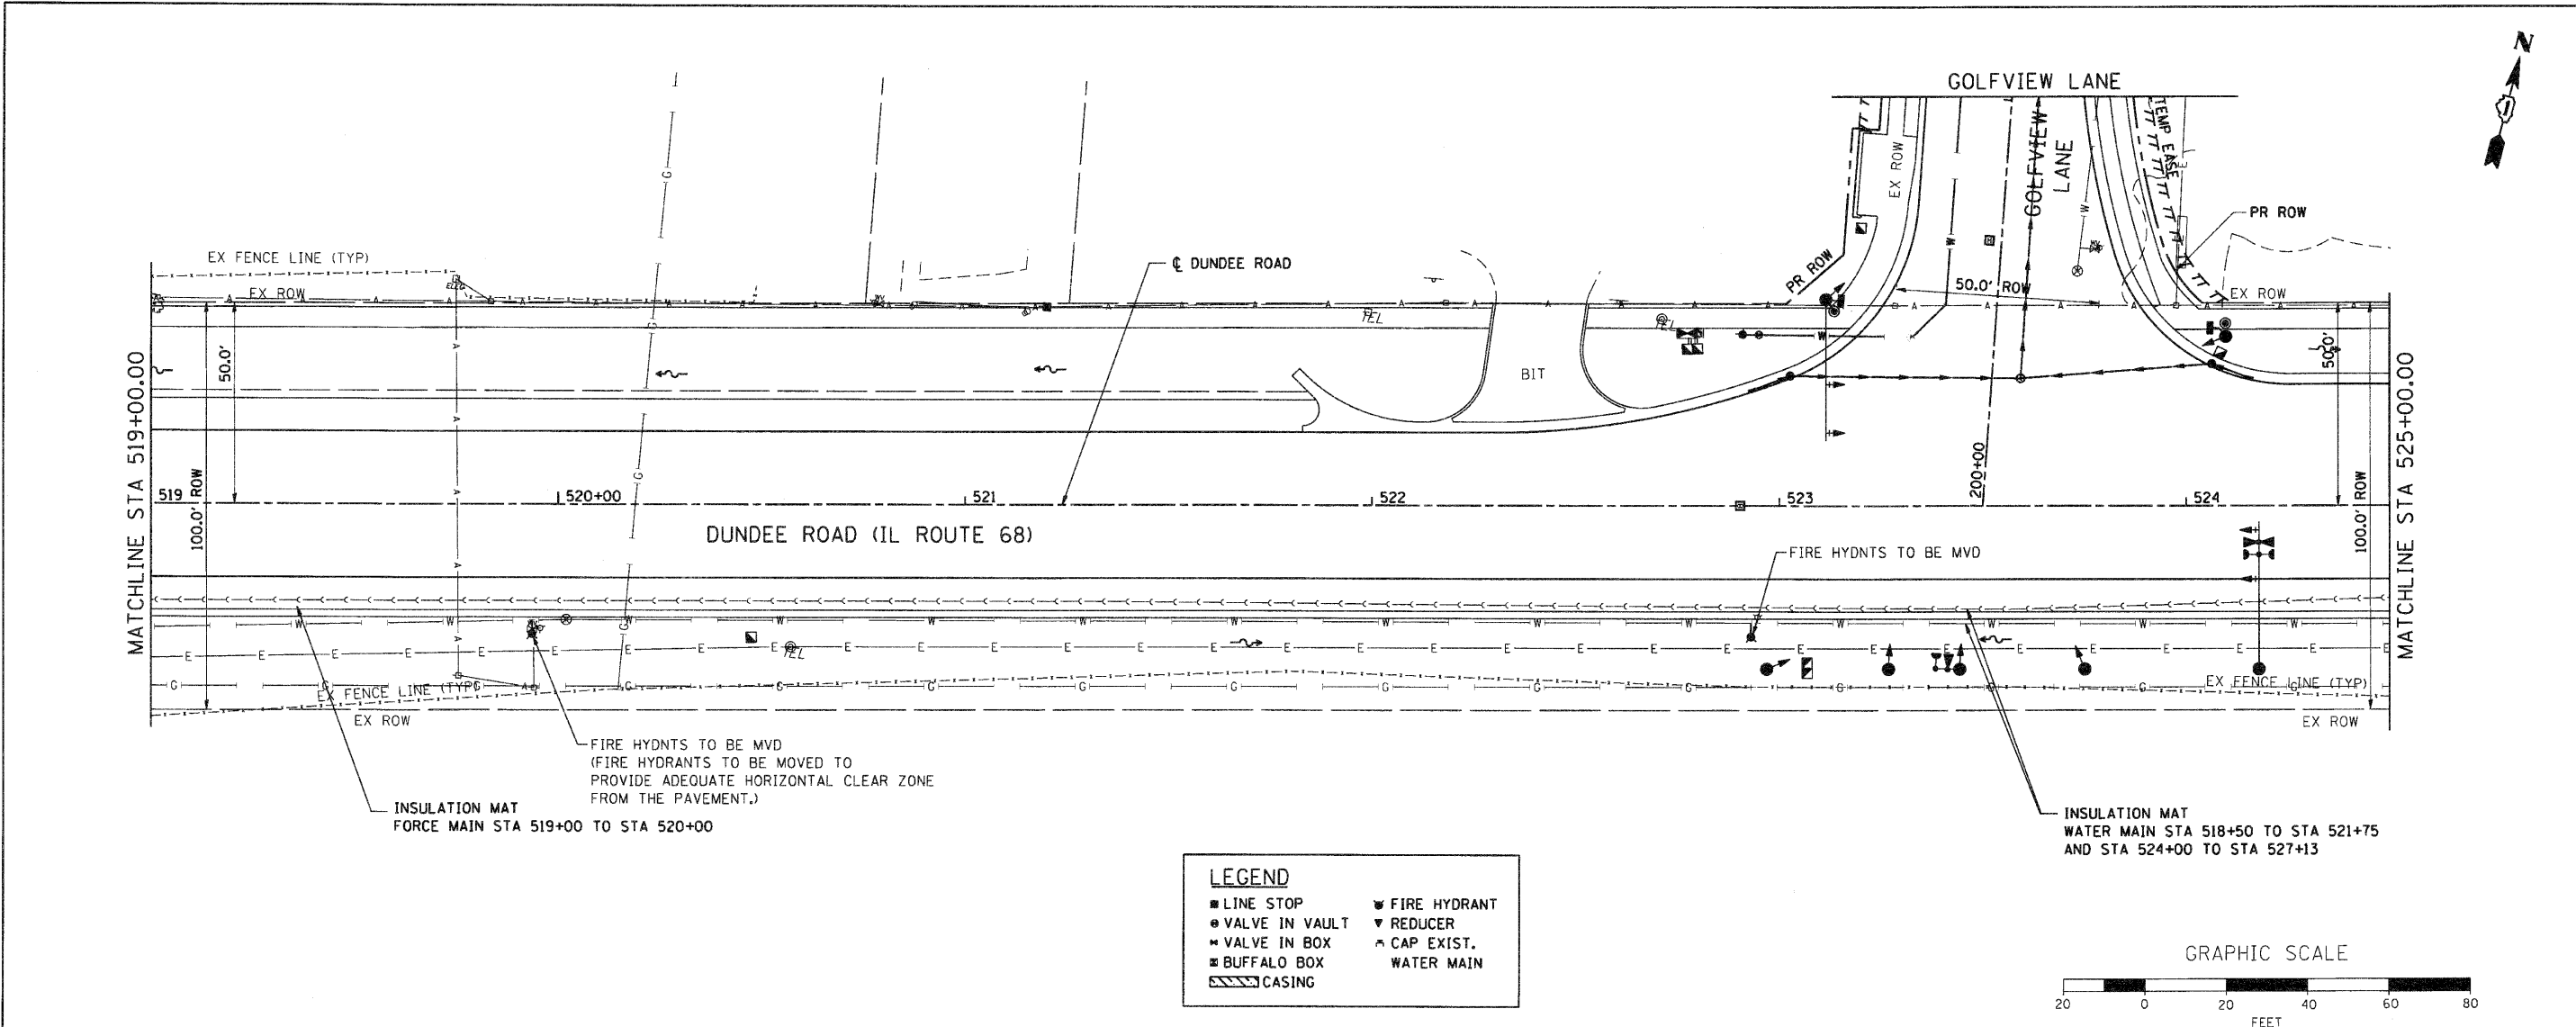

864.75	864.80	865.17	865.55	865.58	865.93	866.24	866.25	866.55	866.79	866.83	867.02	867.23	867.31	867.43	867.64	867.69	867.83	867.92	867.97	868.00	868.08	868.15	868.11	868.15	868.24	868.18	868.18	868.23	868.13	868.06	868.12	867.98	867.89	867.91
519+00	519+00	519+50	519+50	520+00	520+00	520+50	520+50	521+00	521+00	521+50	521+50	522+00	522+00	522+50	522+50	523+00	523+00	523+50	523+50	524+00	524+00	524+00	524+50	524+50	524+50	524+50	524+50	524+50	524+50	524+50	524+50	524+50	524+50	524+50

SEC Group, Inc.
 2540 Dundee Road
 618-241-1800
 www.secgroup.com

USER NAME = C:\a-jain	DESIGNED - C. PIEPER	REVISED -
PLLOT SCALE = 1" = 20'	DRAWN - R. BEST	REVISED -
PLLOT DATE = 11/2/2010	CHECKED - T. HAMILTON	REVISED -
	DATE - 10/25/10	REVISED -

VILLAGE OF CARPENTERSVILLE

**WATERMAIN AND SANITARY SEWER PLAN AND PROFILE
 DUNDEE ROAD (IL ROUTE 68)**

F.A. RTE.	SECTION	COUNTY	TOTAL SHEETS	SHEET NO.
FAU 2414, FAU 1280, FAP 343	06-00074-00-FP	KANE	211	87
CONTRACT NO. 63504				