
 
 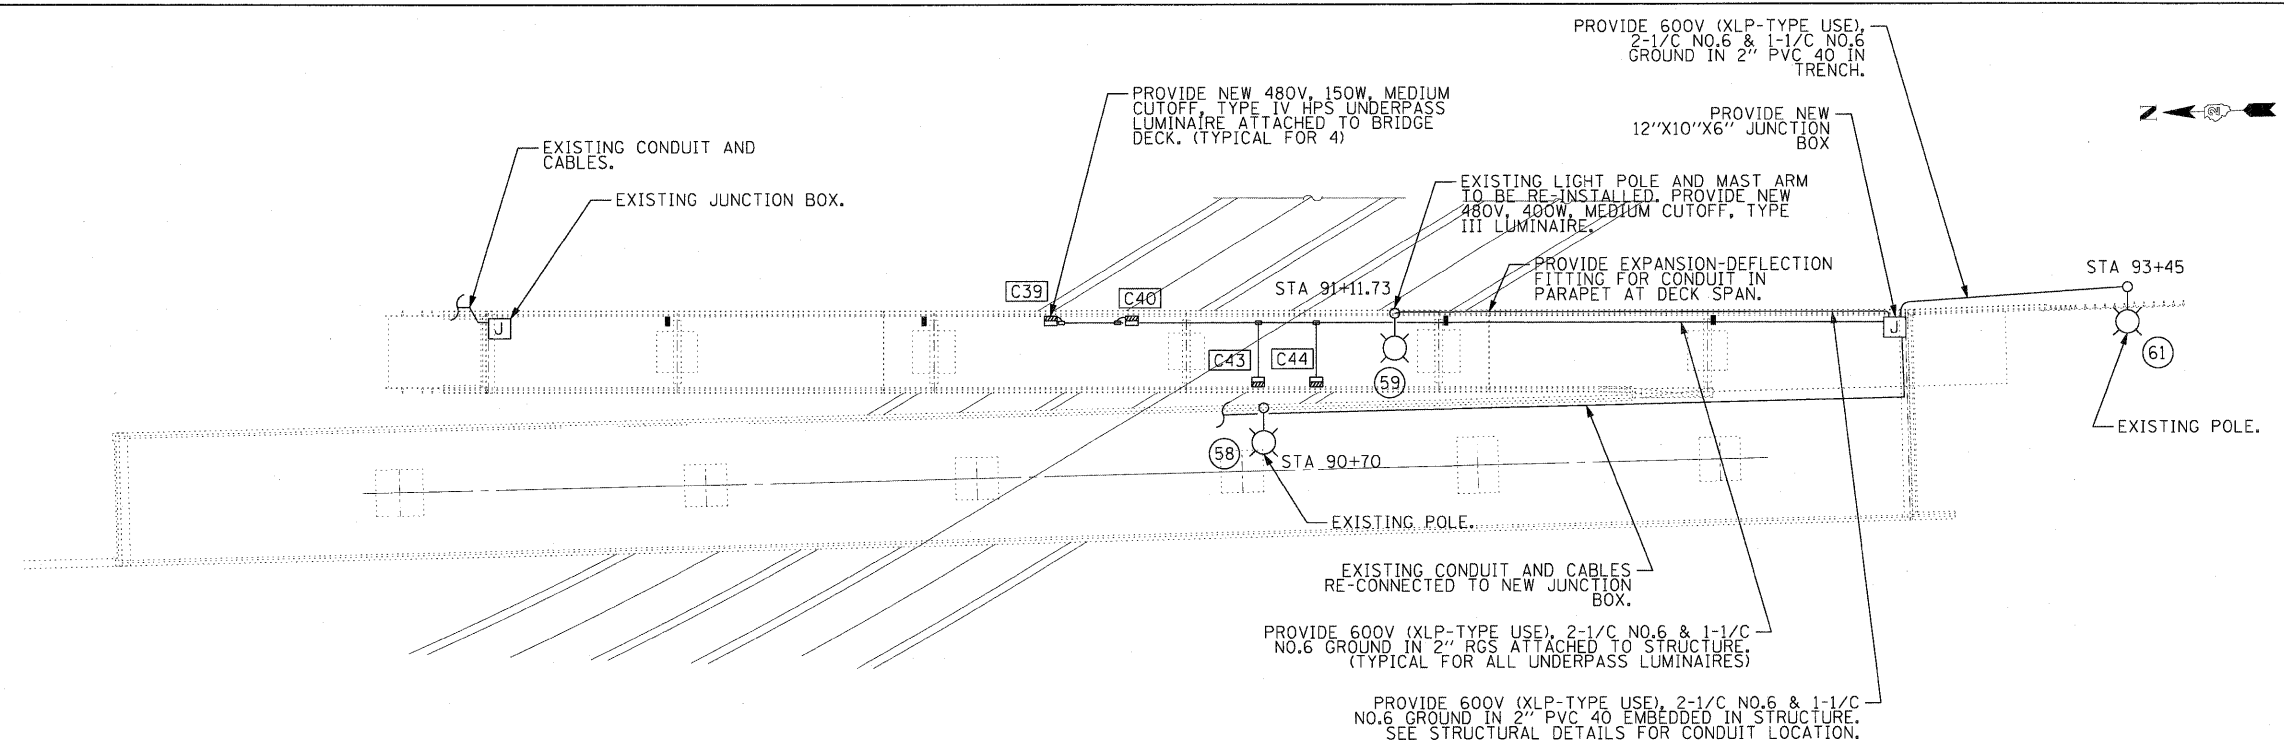


RAMP S-7 ELECTRICAL REMOVAL PLAN



RAMP S-7 ELECTRICAL PROPOSED PLAN



FILE NAME = E2 Ramp S-7 Lighting Plan.dgn JACOBS	USER NAME = JACOBS	DESIGNED - HS	REVISED -	STATE OF ILLINOIS DEPARTMENT OF TRANSPORTATION	E2 RAMP S-7 LIGHTING PLAN	F.A.I. RTE.	SECTION	COUNTY	TOTAL SHEETS	SHEET NO.
	PLOT SCALE =	DRAWN - HS	REVISED -			74	(81-IHBD)	ROCK ISLAND	78	15
	PLOT DATE = 10/28/2010	CHECKED - CDS	REVISED -			CONTRACT NO. 64D95			ILLINOIS FED. AID PROJECT	
	SHEET NO. 15 OF 78 SHEETS									