
 
 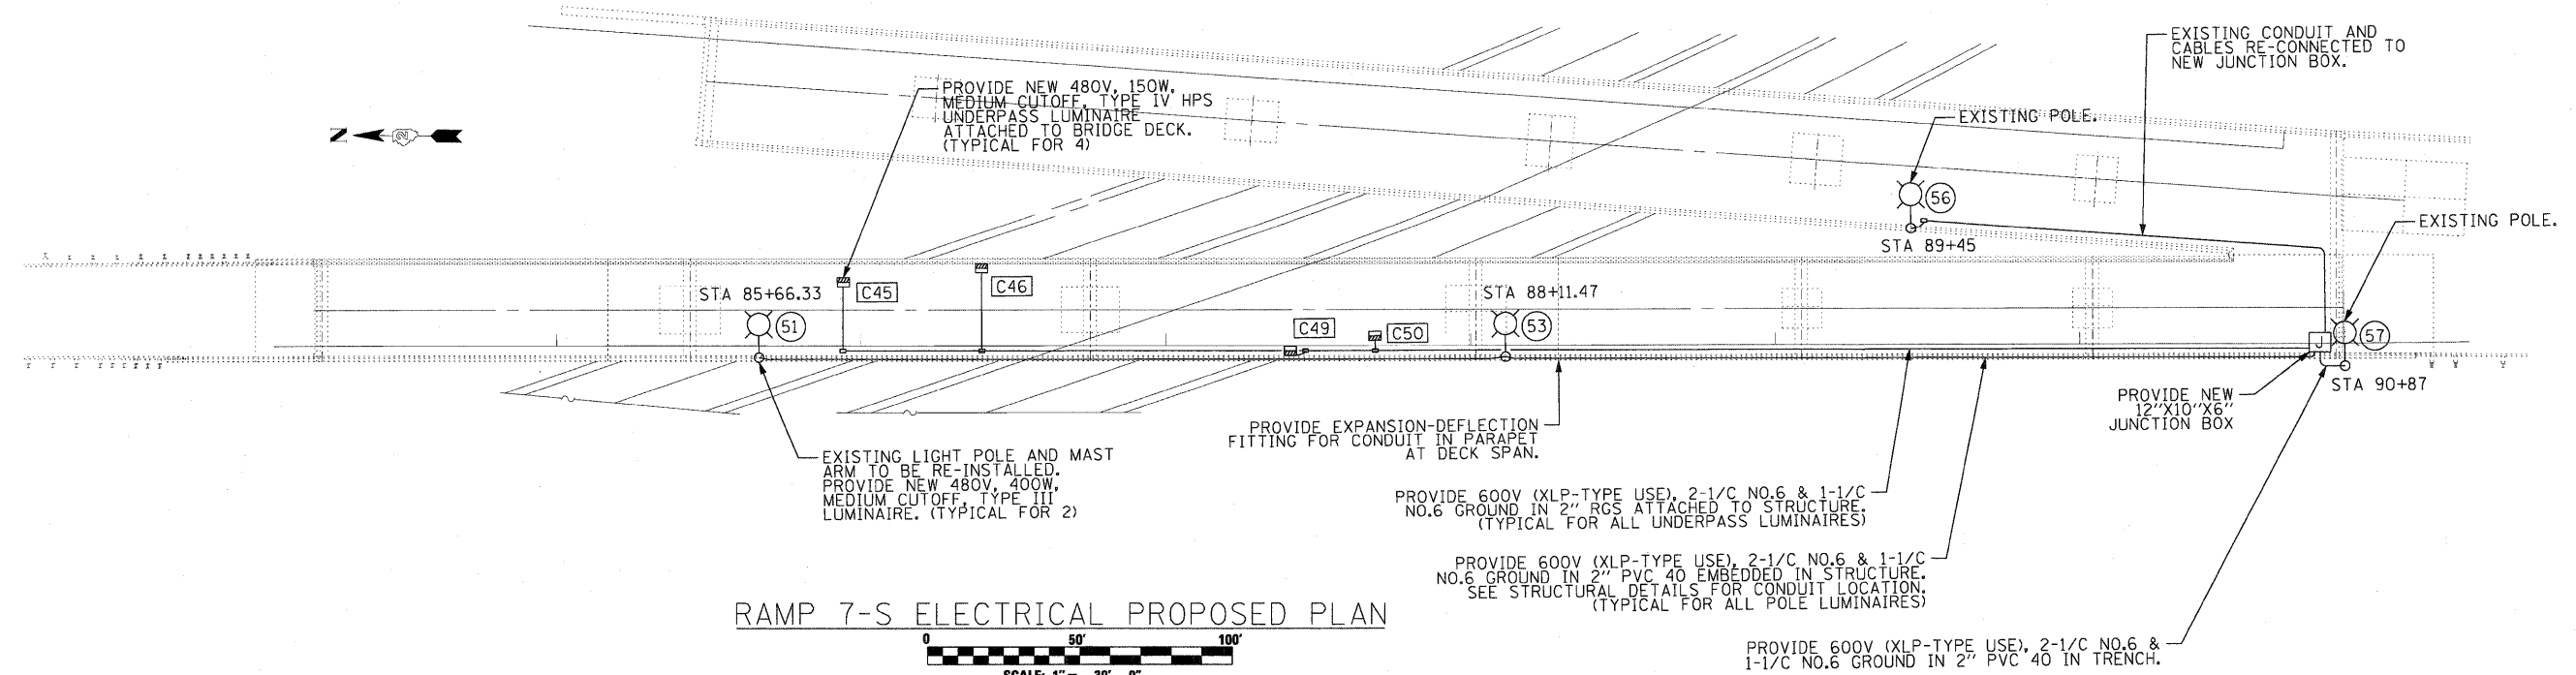


RAMP 7-S ELECTRICAL REMOVAL PLAN



RAMP 7-S ELECTRICAL PROPOSED PLAN



FILE NAME = E3 Ramp 7-S Lighting Plan.dgn
JACOBS

USER NAME = JACOBS
 PLOT SCALE =
 PLOT DATE = 10/28/2010

DESIGNED - HS
 CHECKED - CDS
 DRAWN - HS
 CHECKED - CDS

REVISED -
 REVISED -
 REVISED -
 REVISED -

STATE OF ILLINOIS
 DEPARTMENT OF TRANSPORTATION

E3 RAMP 7-S LIGHTING PLAN
 SHEET NO. 16 OF 78 SHEETS

F.A.I. RTE.	SECTION	COUNTY	TOTAL SHEETS	SHEET NO.
74	(81-1HB)D	ROCK ISLAND	78	16
CONTRACT NO. 64D95				
ILLINOIS FED. AID PROJECT				