


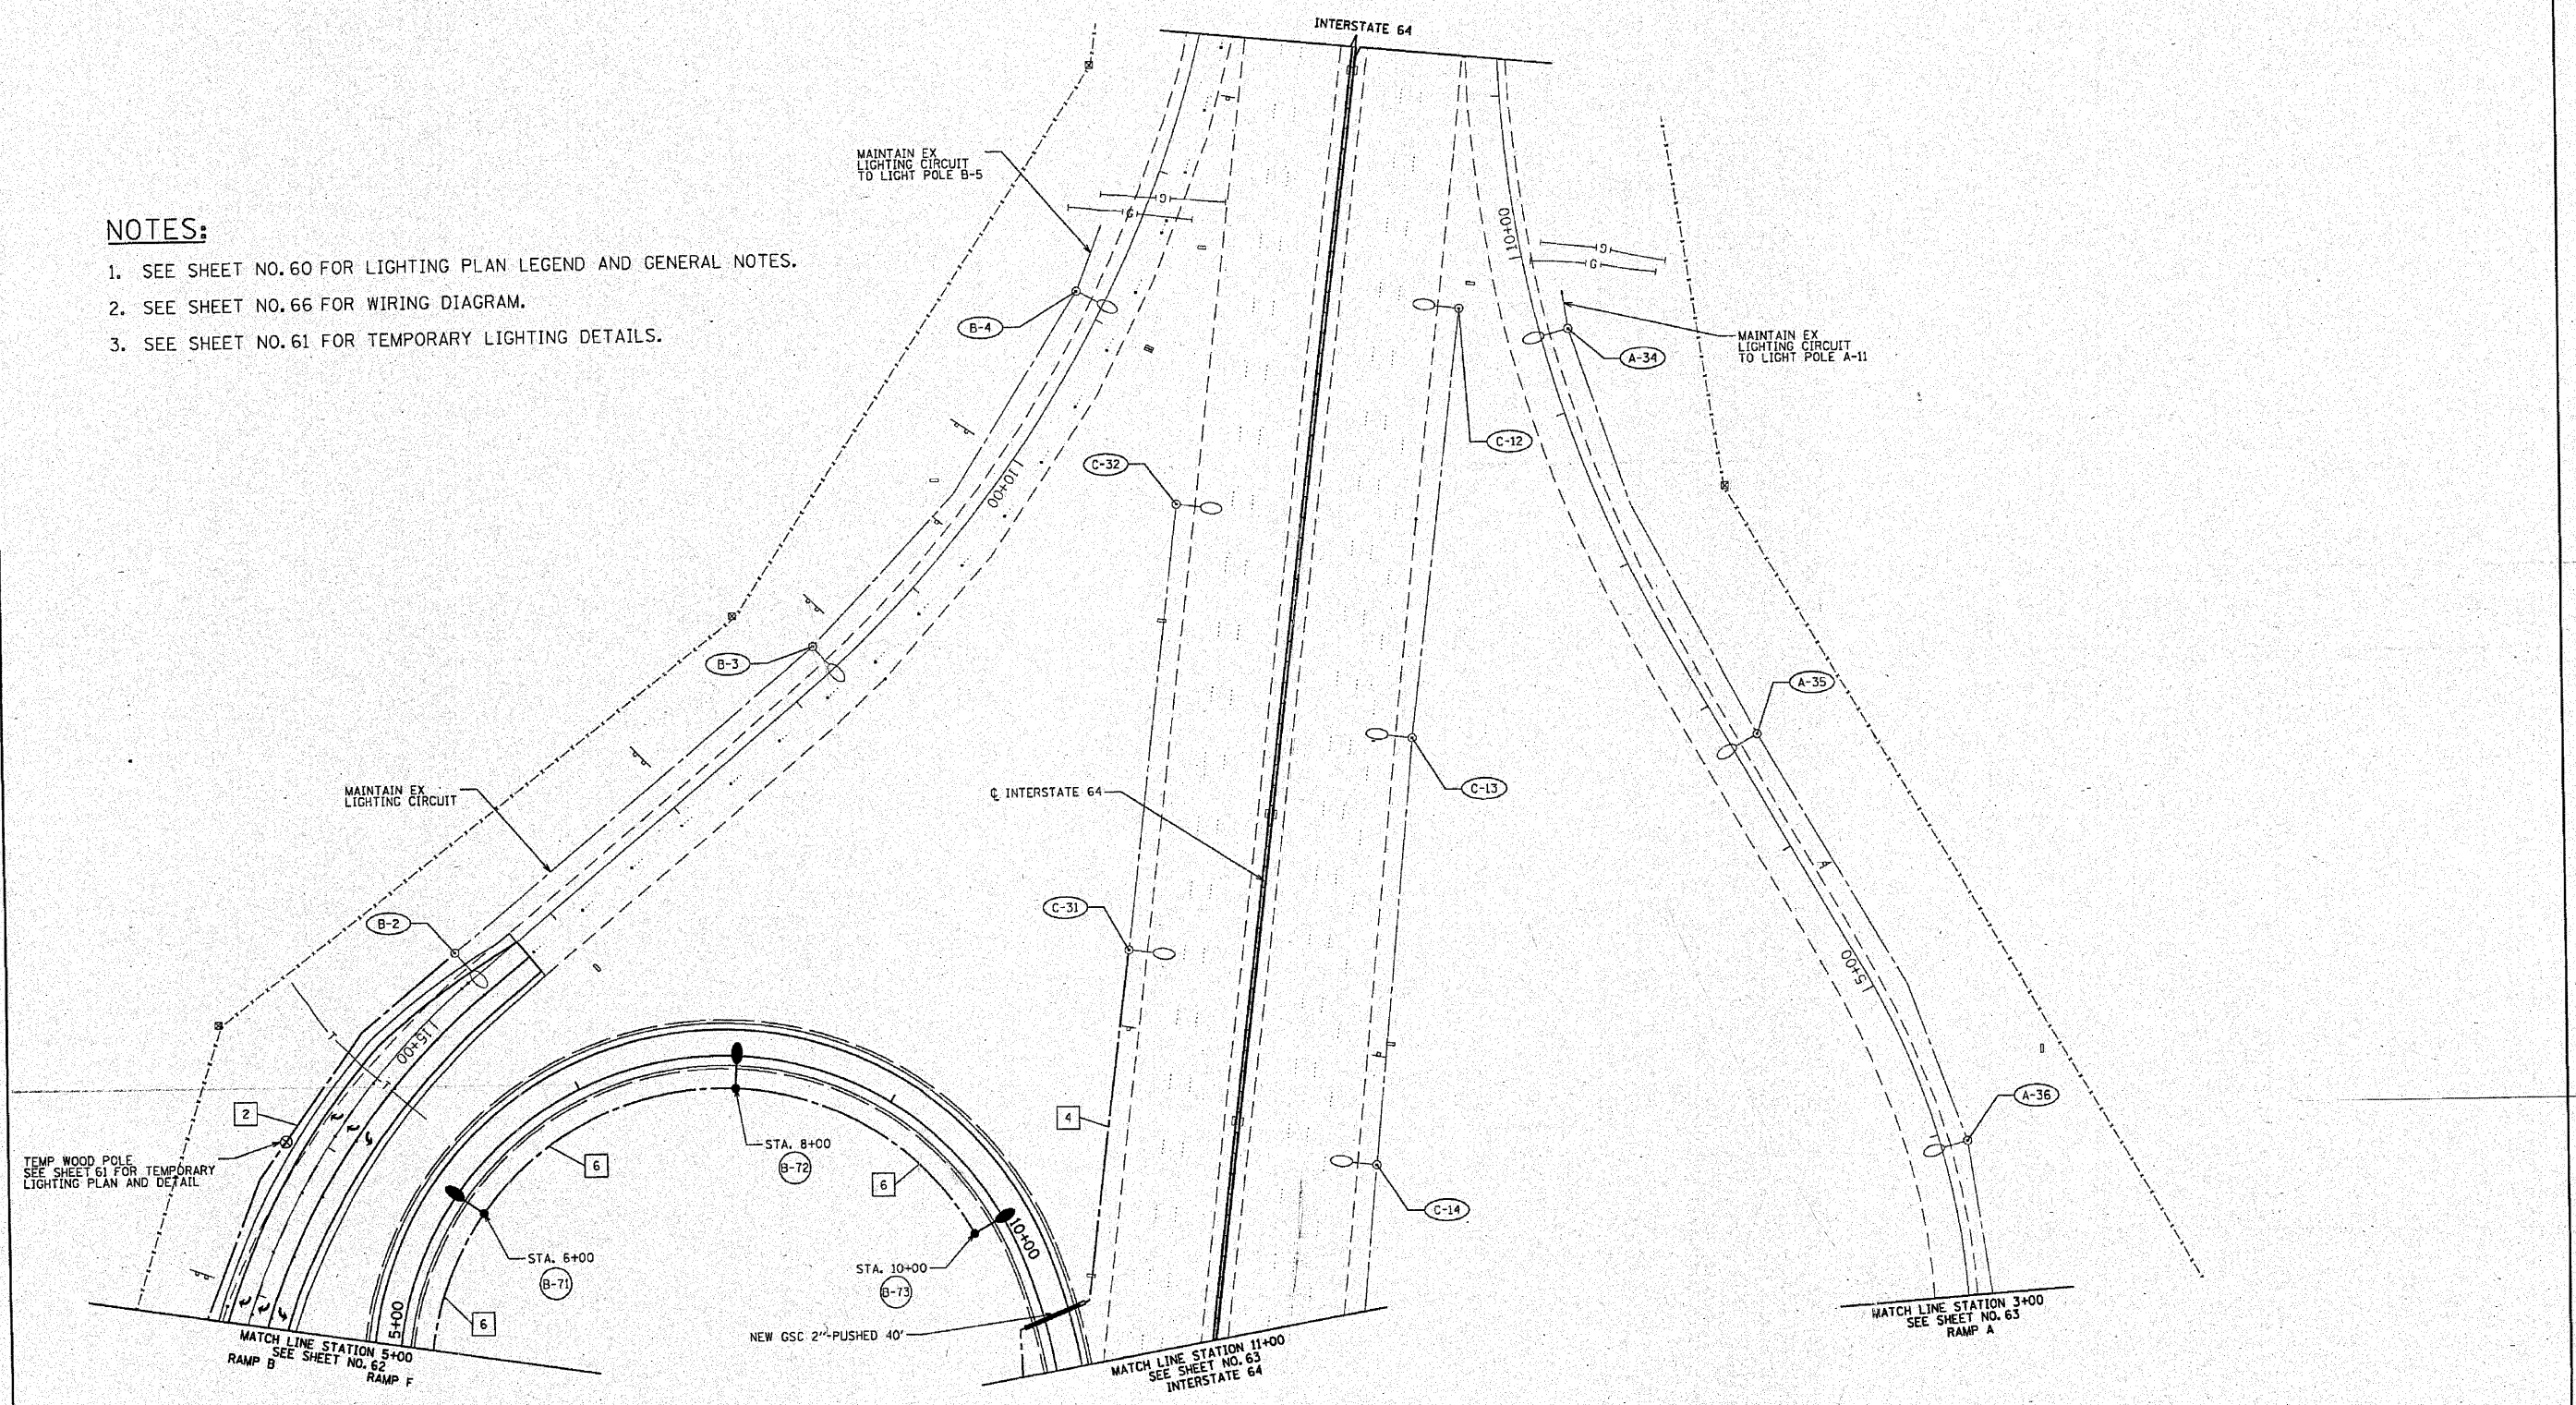

NOTES:

1. SEE SHEET NO. 60 FOR LIGHTING PLAN LEGEND AND GENERAL NOTES.
2. SEE SHEET NO. 66 FOR WIRING DIAGRAM.
3. SEE SHEET NO. 61 FOR TEMPORARY LIGHTING DETAILS.



FILENAME =
g:\ch10\8047\road\C-CU-183.dgn

USER NAME = a.j.pondexter	DESIGNED - XB	REVISED -
PLOT DATE = 10/19/2010 2:30:47 PM	DRAWN - AJP	REVISED -
	CHECKED - SRF	REVISED -
	DATE - 5-21-10	REVISED -

**STATE OF ILLINOIS
DEPARTMENT OF TRANSPORTATION**

**LIGHTING
PROPOSED IMPROVEMENT PLAN**

SCALE: 1"=50' SHEET NO. OF SHEETS STA. TO STA.

F.A.I. RTE.	SECTION	COUNTY	TOTAL SHEETS	SHEET NO.
64	B2-5K-2	ST. CLAIR	162	64
JOB NO. D-98-024-10		PTB NO. 153/053		
FED. ROAD DIST. NO. ILLINOIS FED. AID PROJECT				