


STATE OF ILLINOIS  
DEPARTMENT OF TRANSPORTATION

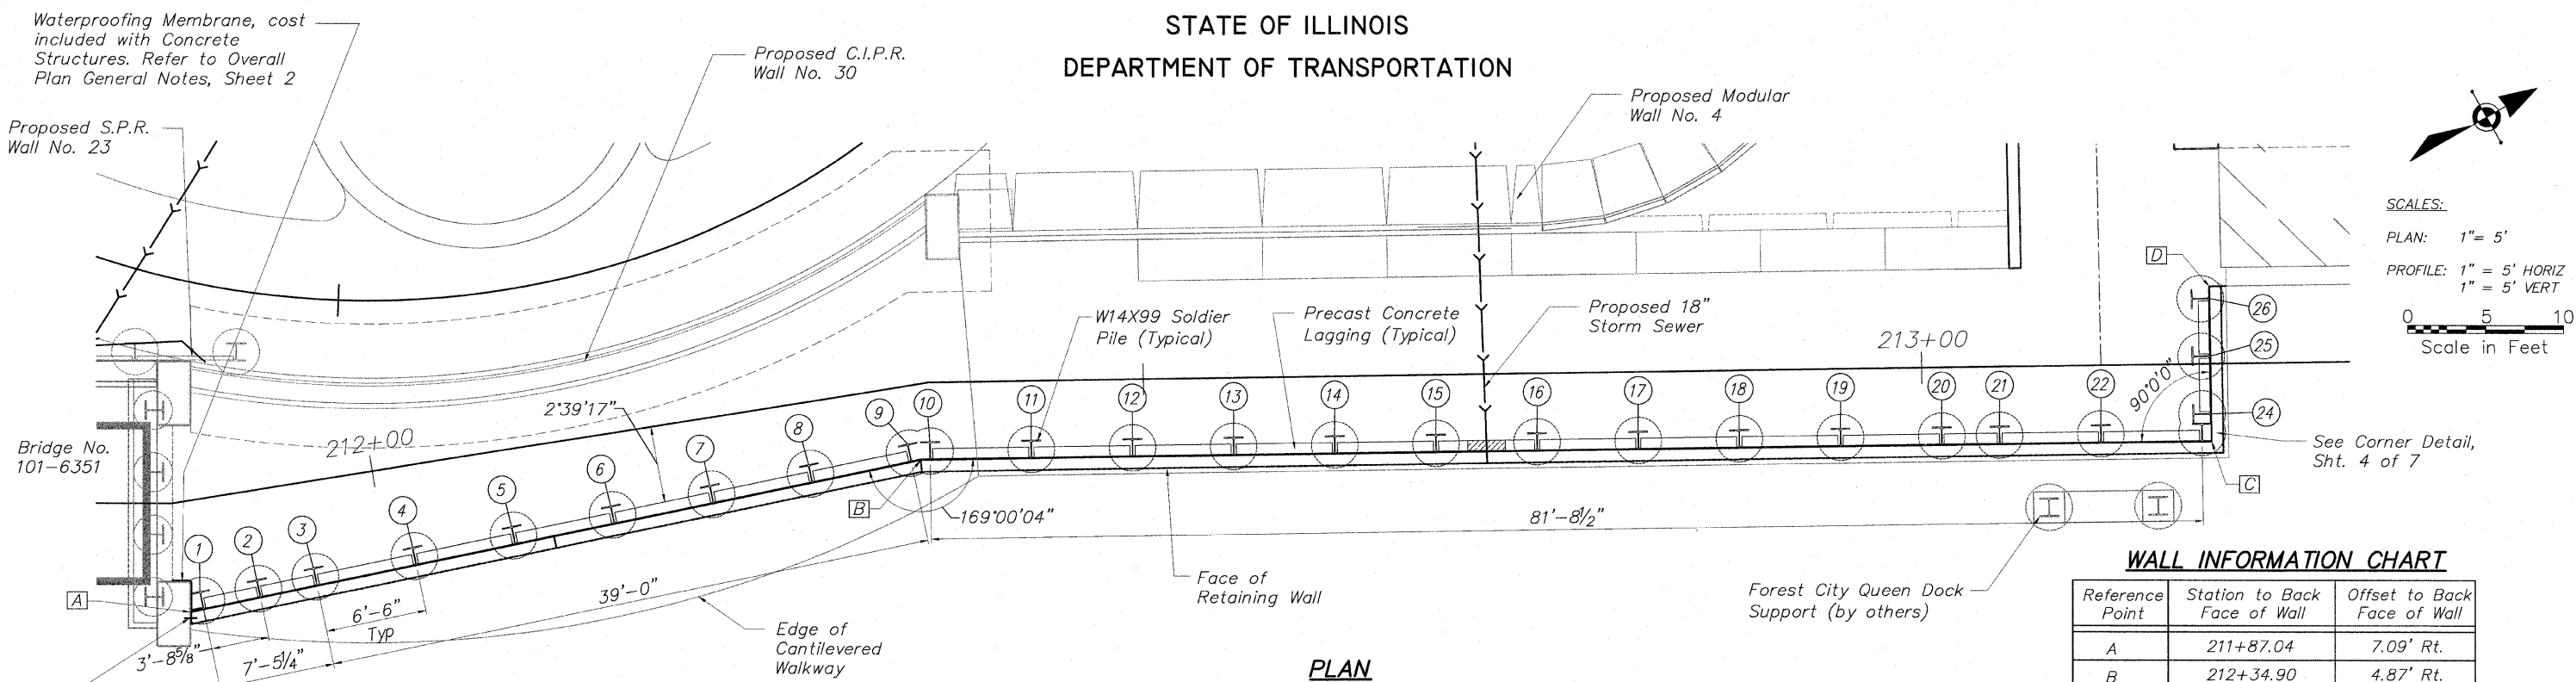


SCALES:  
PLAN: 1" = 5'  
PROFILE: 1" = 5' HORIZ  
1" = 5' VERT  
0 5 10  
Scale in Feet

**WALL INFORMATION CHART**

Reference Point	Station to Back Face of Wall	Offset to Back Face of Wall
A	211+87.04	7.09' Rt.
B	212+34.90	4.87' Rt.
C	213+18.55	5.00' Rt.
D	213+18.55	5.00' Lt.

**PLAN**

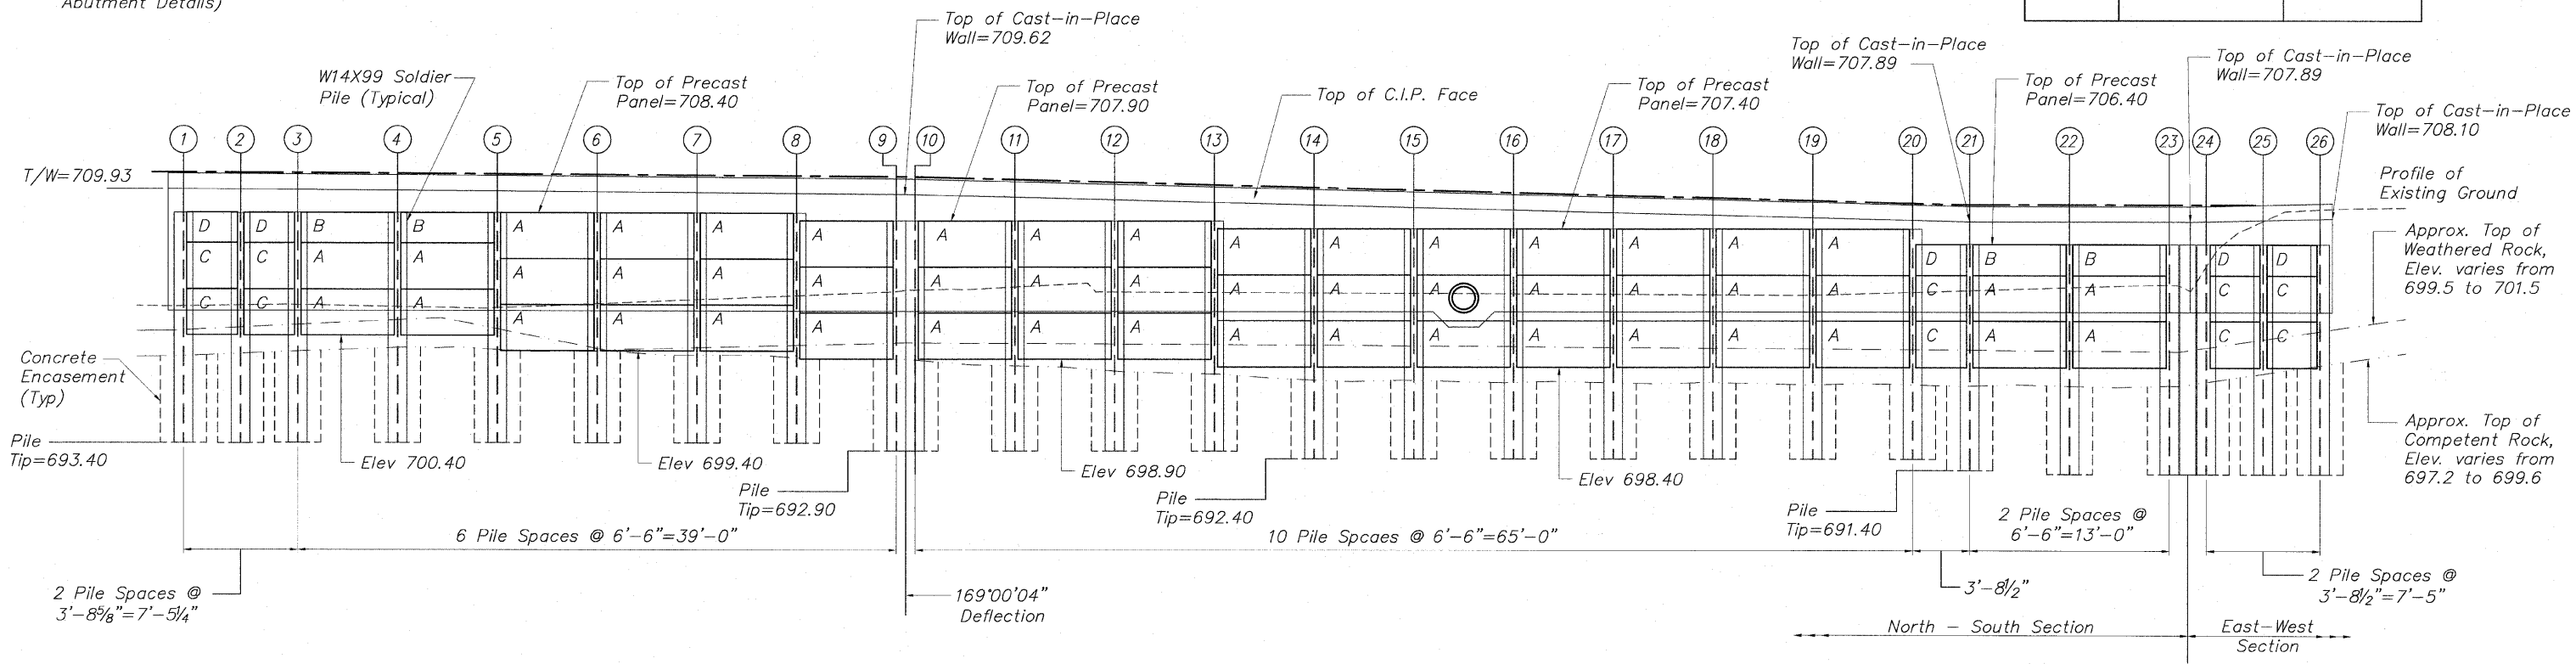

**ELEVATION (Showing Precast Panels)**  
(Looking @ Front Face of Wall)

**PRECAST PANEL SCHEDULE**

PANEL	NOMINAL SIZE	No.	Sq. Ft. PANELS
A	3' x 6'	50	900
B	2' x 6'	4	48
C	3' x 3'-3"	10	97.5
D	2' x 3'-3"	5	32.5
Total			1078

**SP WALL No. 24 DETAILS  
PLAN AND PRECAST ELEVATION  
PEDESTRIAN RIVERWALK  
WINNEBAGO COUNTY  
SECTION NO. 06-00543-00-BT  
STATION 211+87.04 TO  
STATION 213+18.55**

DESIGNED	CTB
CHECKED	AAG
DRAWN	JAW
CHECKED	JWH

**McClure**  
Engineering Associates, Inc.  
7282 Argus Drive  
(815) 398-2332  
Rockford, Illinois 61107-5837  
Fax (815) 398-2496  
Design Firm License: #184-000816  
Copyright 2009 by McClure Engineering Associates, Inc.

SHEET NO. 2  
7 SHEETS

F.A. RTE.	SECTION	COUNTY	TOTAL SHEETS	SHEET NO.
	06-00543-00-BT	WINNEBAGO	148	100
FED. ROAD DIST. NO.	ILLINOIS	FED. AID PROJECT	CONTRACT NO. 85521	

H:\06\_08 RIVERWALK MUSEUM\DESIGN\DRAWINGS\STRUCTURAL\GP&E\06-08 SP-WALL 24.DWG, DET-24 (0), 10/26/2010 4:13:17 PM, 1:1, JWH