
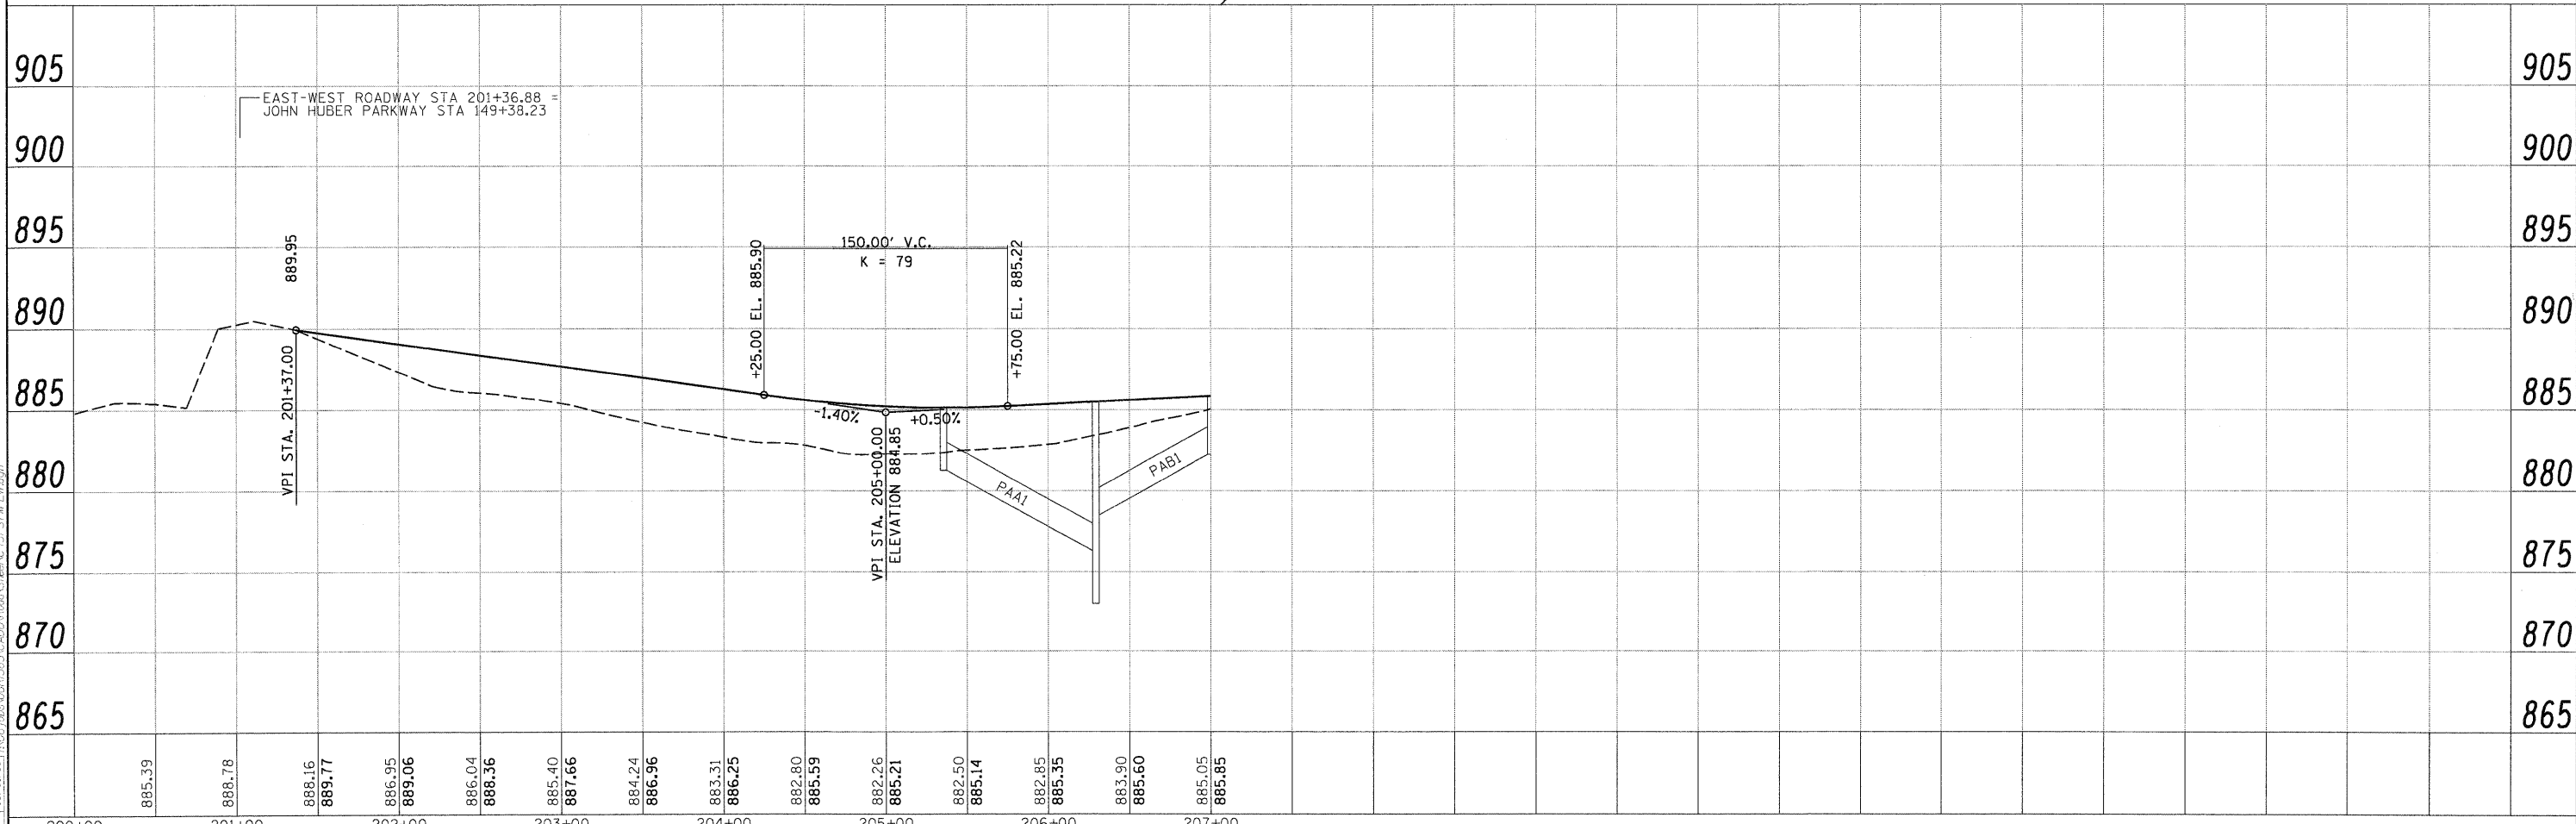
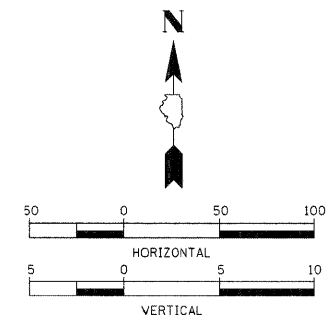


SEE DRAINAGE SCHEDULE ②

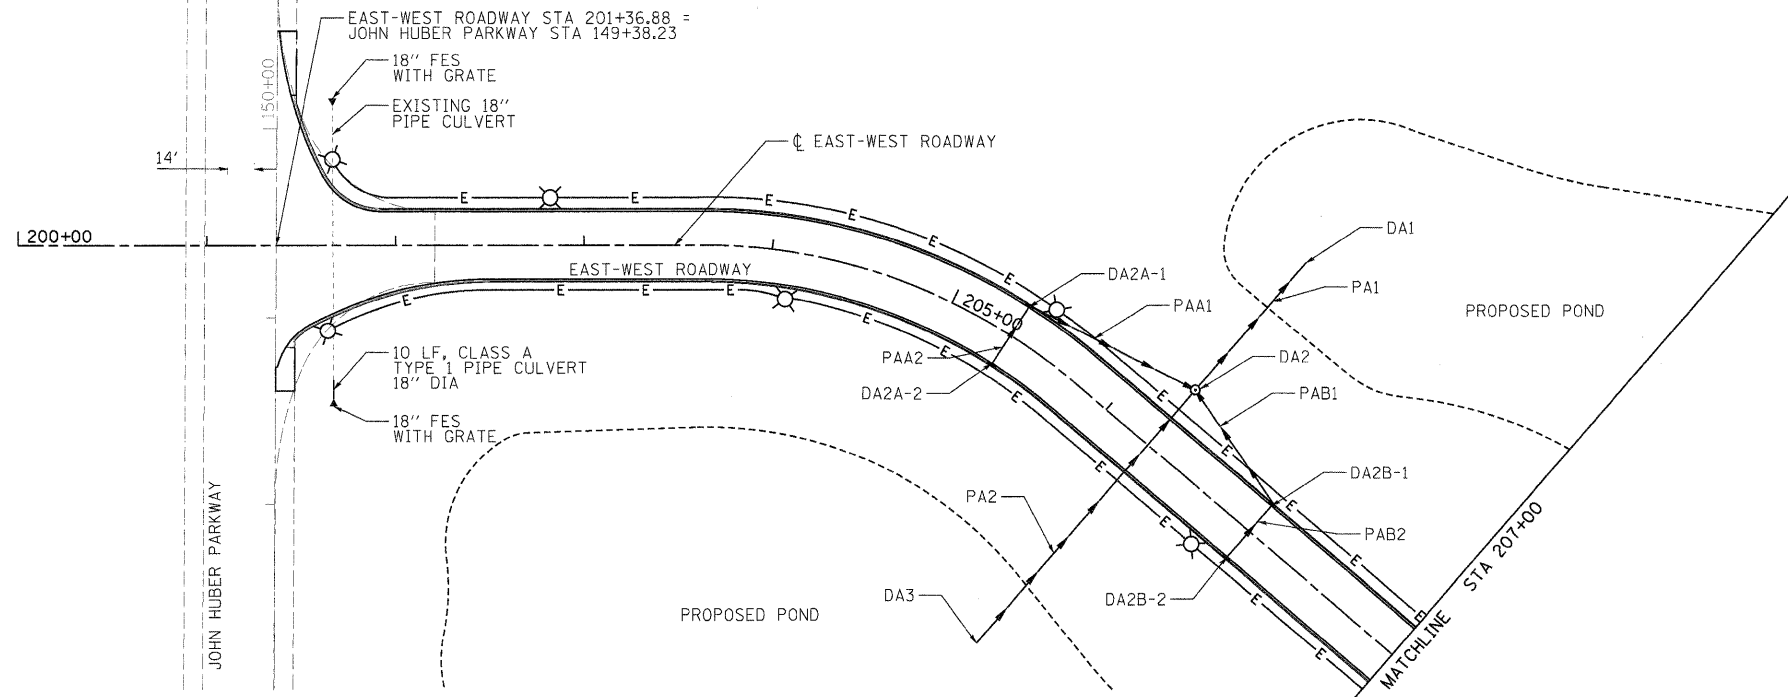

LAYOUT: MWH 08/05/09 HUS00041
 DRAWN: MWH 10/01/10 HUS00041
 REVIEWED: DCA 10/01/10 HUS00041

FILE NAME: D:\131 STM-EW.dgn		USER NAME: HUS00041	DESIGNED: CRC	REVISED: -	STATE OF ILLINOIS DEPARTMENT OF TRANSPORTATION	NORTHERN ILLINOIS UNIVERSITY FAR WEST CAMPUS EXPANSION EAST-WEST ROADWAY DRAINAGE PLAN AND PROFILE			F.A.P. RTE.: 567	SECTION: 06-00002-00-PV	COUNTY: DEKALB	TOTAL SHEETS: 148	SHEET NO.: 56
		PLOT SCALE: 50.000' / 1"	CHECKED: CRC	REVISED: -		SCALE: 1" = 50'	SHEET NO.:	OF SHEETS:	STA. 200+00 TO STA. 207+00	CONTRACT NO. 87476			
		PLOT DATE: 11/05/2010	DATE: 11/04/10	REVISED: -		ILLINOIS FED. AID PROJECT							