


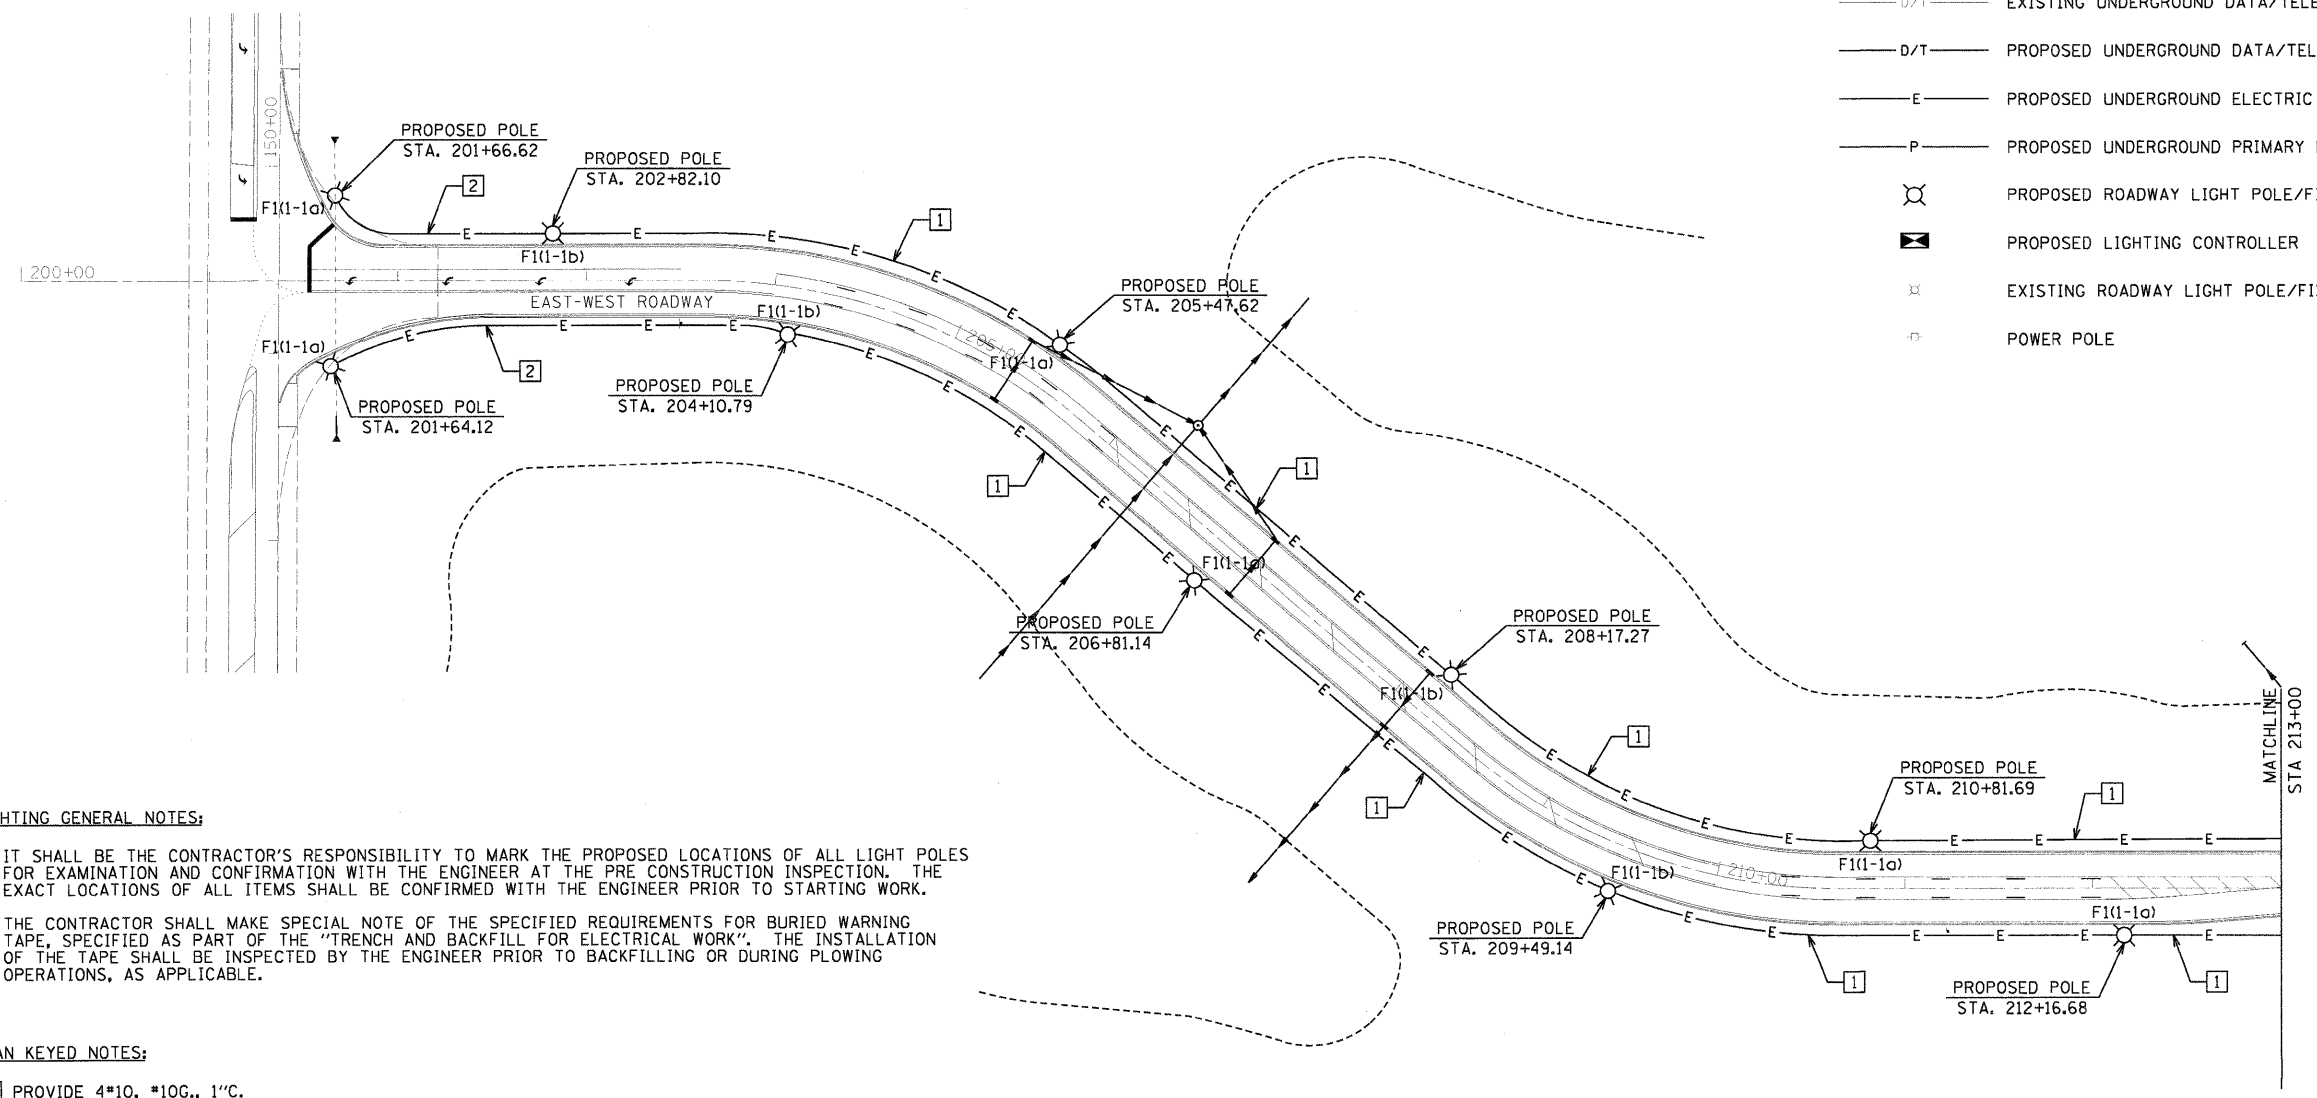

LEGEND

- E— EXISTING UNDERGROUND ELECTRIC LINE
- - - - - US - - - - - EXISTING UNDERGROUND SECONDARY ELECTRIC
- - - - - UP - - - - - EXISTING UNDERGROUND PRIMARY ELECTRIC
- - - - - D/T - - - - - EXISTING UNDERGROUND DATA/TELEPHONE LINE
- D/T— PROPOSED UNDERGROUND DATA/TELEPHONE LINE
- E— PROPOSED UNDERGROUND ELECTRIC LINE
- P— PROPOSED UNDERGROUND PRIMARY ELECTRIC LINE
- ⊗ PROPOSED ROADWAY LIGHT POLE/FIXTURE
- ⊠ PROPOSED LIGHTING CONTROLLER
- ⊗ EXISTING ROADWAY LIGHT POLE/FIXTURE
- ⊠ POWER POLE



LIGHTING GENERAL NOTES:


1. IT SHALL BE THE CONTRACTOR'S RESPONSIBILITY TO MARK THE PROPOSED LOCATIONS OF ALL LIGHT POLES FOR EXAMINATION AND CONFIRMATION WITH THE ENGINEER AT THE PRE CONSTRUCTION INSPECTION. THE EXACT LOCATIONS OF ALL ITEMS SHALL BE CONFIRMED WITH THE ENGINEER PRIOR TO STARTING WORK.
2. THE CONTRACTOR SHALL MAKE SPECIAL NOTE OF THE SPECIFIED REQUIREMENTS FOR BURIED WARNING TAPE, SPECIFIED AS PART OF THE "TRENCH AND BACKFILL FOR ELECTRICAL WORK". THE INSTALLATION OF THE TAPE SHALL BE INSPECTED BY THE ENGINEER PRIOR TO BACKFILLING OR DURING PLOWING OPERATIONS, AS APPLICABLE.

PLAN KEYED NOTES:

- 1 PROVIDE 4*10, #10G., 1"C.
- 2 PROVIDE 2*10, #10G., 1"C.

THE LOCATION, SIZE AND TYPE OF MATERIAL OF EXISTING UNDERGROUND UTILITIES INDICATED ON THE PLANS IS NOT REPRESENTED AS BEING ACCURATE, SUFFICIENT OR COMPLETE. IT SHALL BE THE CONTRACTOR'S RESPONSIBILITY TO DETERMINE THE ACTUAL LOCATION OF ALL SUCH FACILITIES, INCLUDING THE SERVICE CONNECTIONS TO UNDERGROUND UTILITIES. PRIOR TO CONSTRUCTION THE CONTRACTOR SHALL NOTIFY THE UTILITY COMPANIES OF HIS OPERATIONAL PLANS AND SHALL OBTAIN FROM THE RESPECTIVE UTILITY COMPANIES DETAILED INFORMATION AND ASSISTANCE RELATIVE TO THE LOCATION OF THEIR FACILITIES AND THE WORKING SCHEDULE OF THE COMPANIES FOR REMOVAL OR ADJUSTMENT WHERE REQUIRED. IN THE EVENT AN UNEXPECTED UTILITY INTERFERENCE IS ENCOUNTERED DURING CONSTRUCTION, THE CONTRACTOR SHALL IMMEDIATELY NOTIFY THE UTILITY COMPANY OF JURISDICTION. THE ENGINEER SHALL ALSO BE IMMEDIATELY NOTIFIED. ANY SUCH MAINS AND SERVICES SHALL BE RESTORED TO SERVICE AT ONCE AND PAID FOR BY THE CONTRACTOR AT NO ADDITIONAL COST TO THE CONTRACT.

CONTACT JOINT UTILITY LOCATING INFORMATION FOR EXCAVATING (JULIE) 1-800-892-0123 FOR UTILITY INFORMATION.

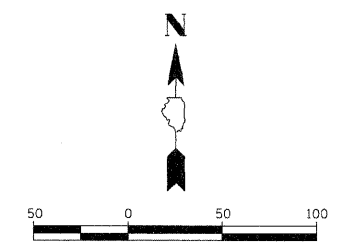

PLOT DATE = 11/04/10
 DRAWN BY = JCT
 CHECKED BY = PJT
 DESIGNED BY = PJT
 USER NAME = MWH
 FILE NAME = \\1186_sbs\12671582\CADD\Road\Sheet\1E-103.dgn
 PLOT SCALE = AS SHOWN
 PLOT DATE = 11/04/10

FILE NAME = \\1186_sbs\12671582\CADD\Road\Sheet\1E-103.dgn PLOT SCALE = AS SHOWN PLOT DATE = 11/04/10		USER NAME = MWH DESIGNED - PJT DRAWN - ANC CHECKED - PJT DATE - 11/04/10		REVISED - REVISED - REVISED - REVISED -		STATE OF ILLINOIS DEPARTMENT OF TRANSPORTATION		NORTHERN ILLINOIS UNIVERSITY FAR WEST CAMPUS EXPANSION ROADWAY LIGHTING PLAN		F.A.P. RTE. 567	SECTION 06-00002-00-PV	COUNTY DEKALB	TOTAL SHEETS 148	SHEET NO. 81
SCALE: AS SHOWN SHEET NO. 3 OF X SHEETS STA. TO STA.								FED. ROAD DIST. NO. [ILLINOIS] FED. AID PROJECT						

L3