


PIPE CULVERT REMOVAL

LOCATION	SIZE	TYPE	LENGTH	T.B., (SPECIAL)
LT. STA. 24+95 (INCL. END SECTION)	15"	RCP	14'	0 C.Y.
LT. STA. 26+60	18"	CMP	39'	13 C.Y.
LT. STA. 28+82	15"	CMP	66'	14 C.Y.
SHEET TOTALS			105'	27 C.Y.

PLAN VIEW

SCALE: 1" = 20'

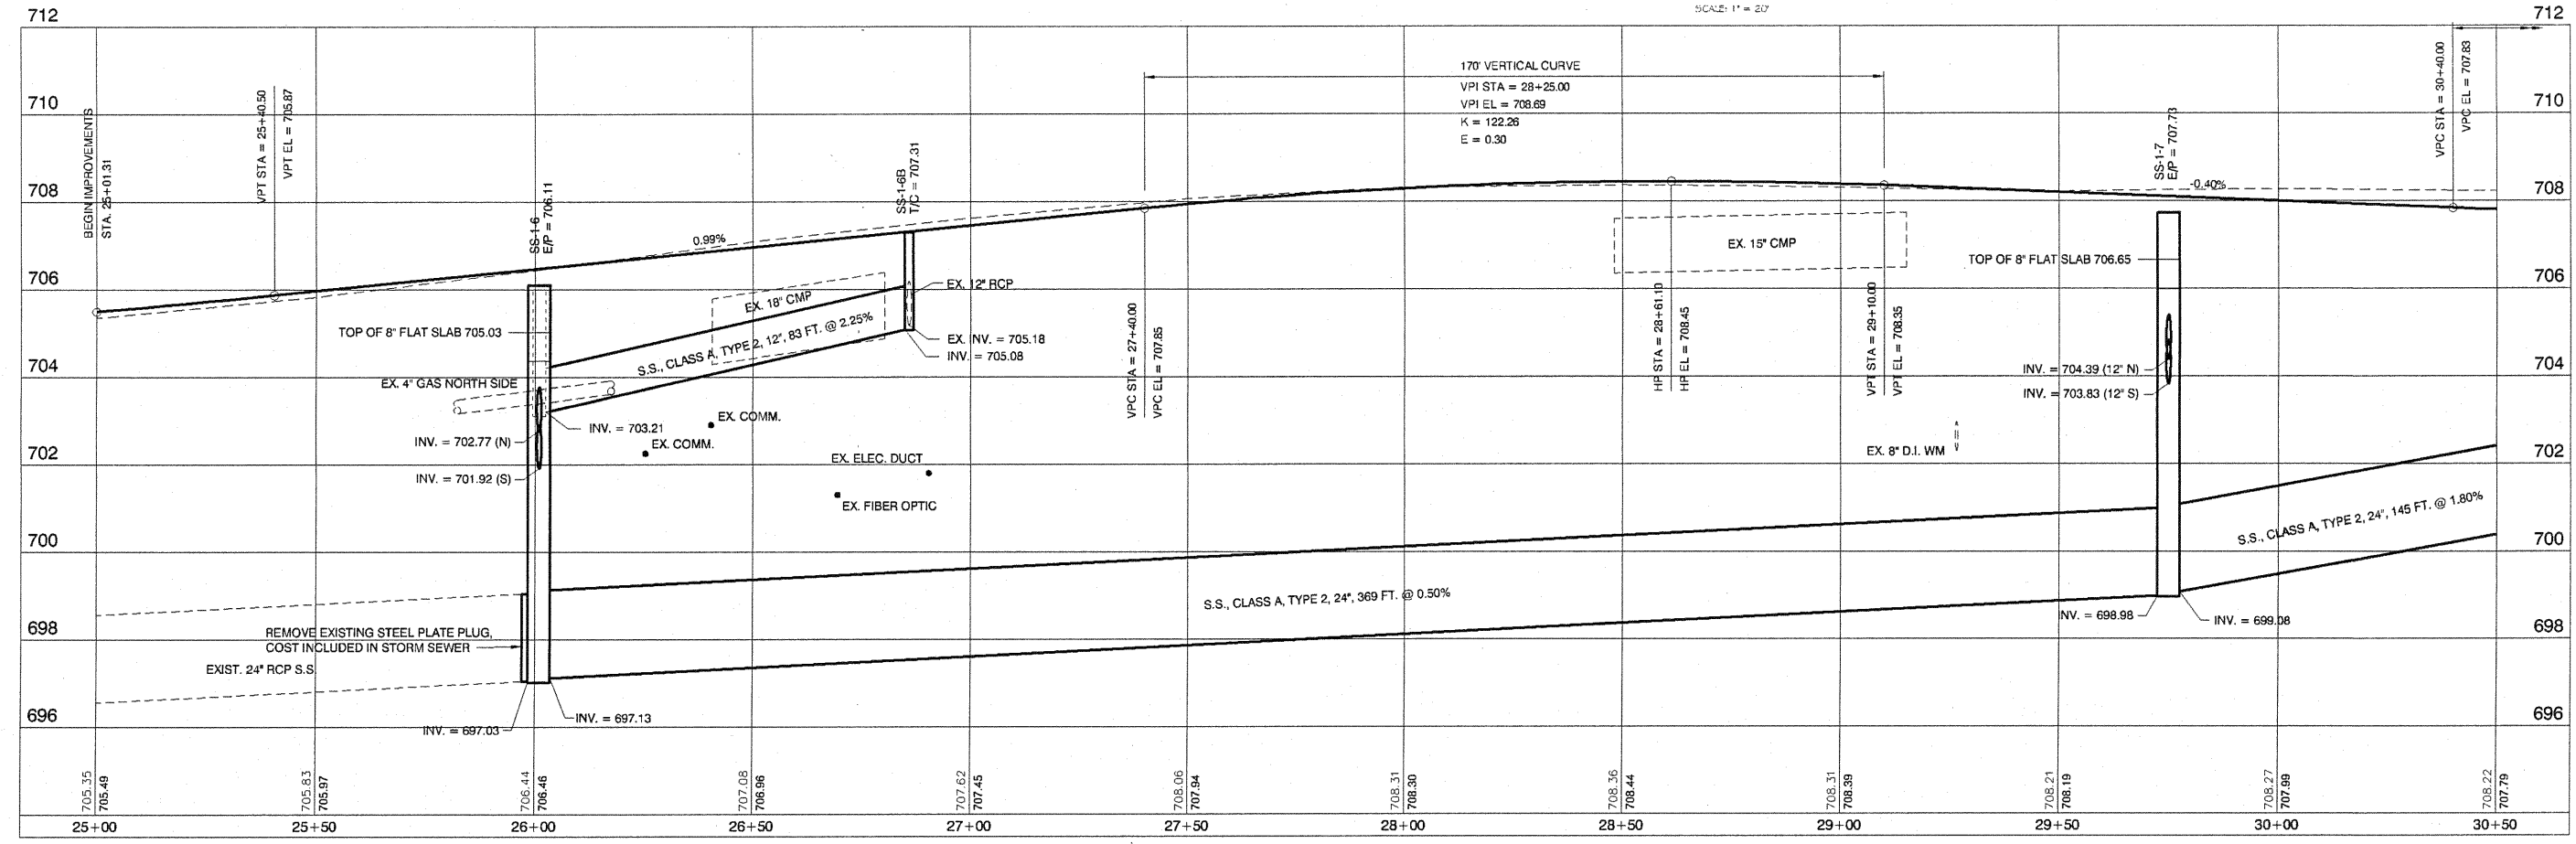

PROFILE VIEW

SCALE: 1" = 20' HOR
1" = 2' VER

MOHR & KERR ENGINEERING & LAND SURVEYING, P.C.
 7336 N. University Ave. Office: (309) 692-8500
 Peoria, Illinois 61614 Fax: (309) 692-8501
 www.mohrandkerr.com Professional Design Firm #184.005091

DESIGNED	WFS	REVISED
DRAWN	DEH	REVISED
CHECKED	WFS	REVISED
DATE	10-25-10	REVISED

STATE OF ILLINOIS
DEPARTMENT OF TRANSPORTATION

STREET IMPROVEMENTS EAST JEFFERSON STREET MORTON, ILLINOIS
PLAN AND PROFILE SHEET

F.A. ROUTE	SECTION	COUNTY	TOTAL SHEETS	SHEET NO.
6721	07-00116-01-PP	TAZEWELL	20	4
CONTRACT NO. 89490				
ILLINOIS FEDERAL ROAD DIST NO. 7				

SCALE: 1" = 20' SHEET NO. 4 OF 20 SHEETS STA. 25+00 TO STA. 30+50