

ROUTE NO.	SECTION	CITY	TOTAL SHEETS	SHEET NO.
	05-00001-00-RP	OREANA	46	9
FED. ROAD DIST. NO.	ILLINOIS		PROJECT	HPP-0813 (001)
CONTRACT NUMBER 95537			DESIGNED	

NO.	BY	DATE
1	MHP	1-30-07
2	MHP	1-30-07


DESIGNED
MHP
DRAWN
Les Jenkins
FIELD BOOK
/17B

DATE
May 2008
JOB NO.
06-040A

BRIDGE & ASSOCIATES, INC.
Consulting Engineers
1870 SOUTH TAYLORVILLE ROAD
DECATUR ILLINOIS
Illinois License 184-001285

VILLAGE OF OREANA, ILLINOIS
SAFE TEA-LU PROJECT
PLAN AND PROFILE
CLAY STREET
STATION 605+25.00 TO 608+28.47

SHEET NO.
9
OF
46

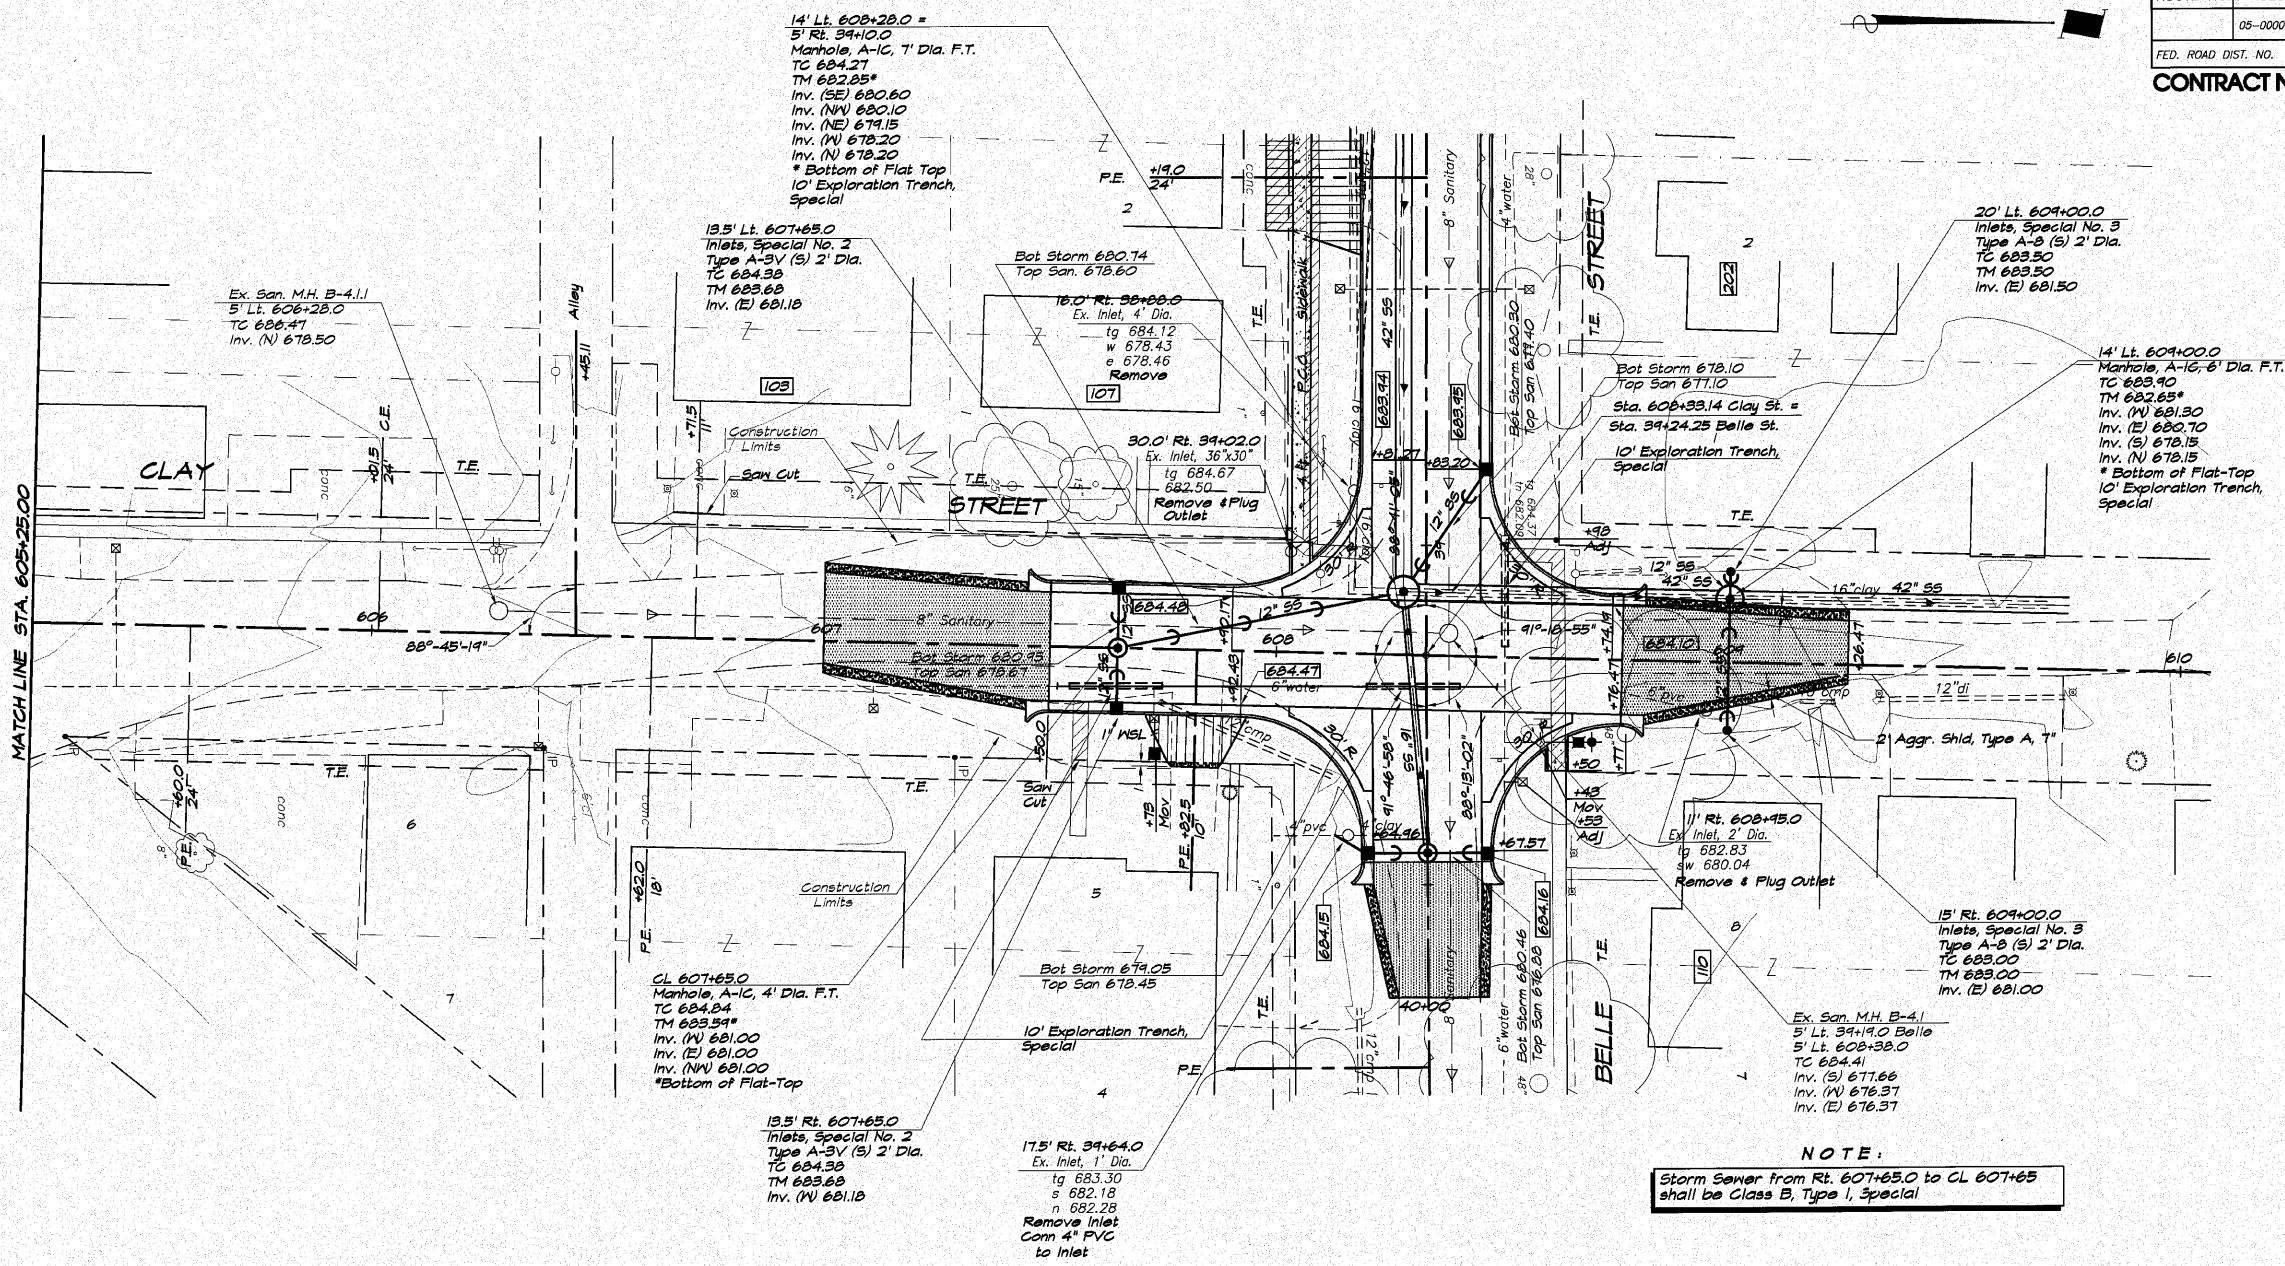

NOTE:
Storm Sewer from Rt. 607+65.0 to CL 607+65 shall be Class B, Type 1, Special

