


SIGN DETAIL  
1:75

EB-CL-34  
STA. 394+40

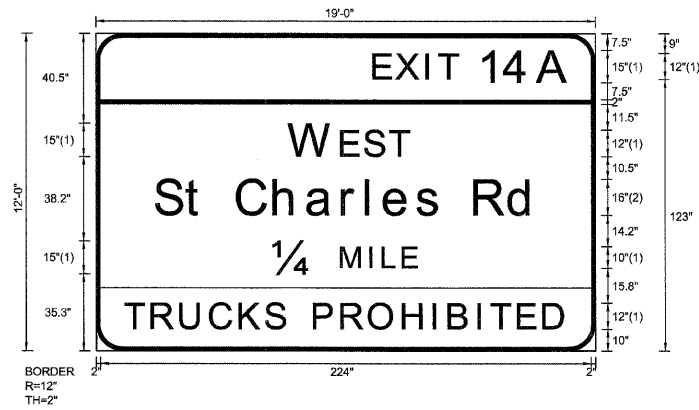

SIGN NUMBER	name
WIDTH x HGHT.	19'-0" x 12'-0"
BORDER WIDTH	2"
CORNER RADIUS	12"
MOUNTING	Overhead
BACKGROUND	TYPE: Reflective COLOR: Green
LEGEND/BORDER	TYPE: Reflective COLOR: Black,WhiteWhite

SYMBOL	ROT	X	Y	WID	HT

Panel Style: sign\_default.ssi  
Dimensions are in inches.tenths

FONT:  
(1) ClearviewHwy-S-W  
(2) ClearviewHwy-S-W-R

Letter locations are panel edge to lower left corner

LETTER POSITIONS (X)

																	LENGTH	SERIESSIZE
E	X	I	T	1	4	A											89.1	12,15
127.3	137.6	151.2	157.2	175.8	187.3	202.4												
W	E	S	T														54.5	15,12
88.8	112.5	123.2	134.6															
S	t		C	h	a	r	l	e	s		R	d					173.1	16,13
27.4	41.5	49.4	64.8	81.6	96.9	112.8	123.8	132.1	146.8	157	173.3	189						
14	M	I	L	E													65.5	15,10
81.3	112.3	125.4	131.3	140.4														
T	R	U	C	K	S		P	R	O	H	I	B	I	T	E	D	200.8	12
13.6	25.9	39	52.6	66	77.8	86.5	100	112.5	125.1	140.5	154.5	161.6	174.9	180.8	193.1	204.8		

FILE NAME =	DESIGNED - SEW	REVISED -
*FILEL*	DRAWN - SEW	REVISED -
USER NAME = #USER*	CHECKED - FML	REVISED -
PLOT DATE = #DATE*	DATE - 12/2009	REVISED -



STATE OF ILLINOIS  
DEPARTMENT OF TRANSPORTATION

SIGNING DETAILS

SCALE: N.T.S. SHEET NO. 11 OF 58 SHEETS STA. TO STA.

F.A.I. RTE.	SECTION	COUNTY	TOTAL SHEETS	SHEET NO.
290	2009-099BR	COOK/DUPAGE	394	339
FED. ROAD DIST. NO. ILLINOIS/FED. AID PROJECT			CONTRACT NO. 60157	