


SIGN DETAIL
1:75

WB-TR-25
STA. 290+40

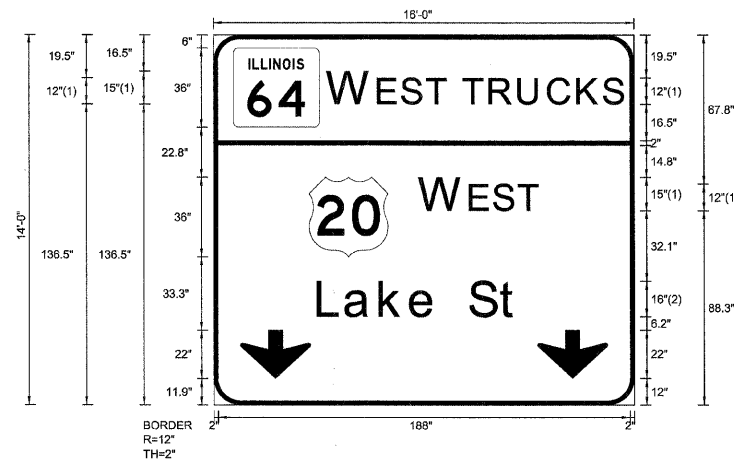

SIGN NUMBER	name
WIDTH x HGHT.	16'-0" x 14'-0"
BORDER WIDTH	2"
CORNER RADIUS	12"
MOUNTING	Overhead
BACKGROUND	TYPE: Reflective COLOR: Green
LEGEND/BORDER	TYPE: Reflective COLOR: White/White

SYMBOL	ROT	X	Y	WID	HT
M1-1100A-2-22-10D		9	126	39.3	36
M1_4	0	43.6	67.3	36	36
ARROWDOWN	0	12.2	11.9	32	22
ARROWDOWN	0	147.8	12	32	22

Panel Style: sign_default.ssi
Dimensions are in inches, tenths

FONT:
(1) ClearviewHwy-5-W
(2) ClearviewHwy-5-W-R

Letter locations are panel edge to lower left corner

LETTER POSITIONS (X)

										LENGTH	SERIESSIZE
W	E	S	T								ClearviewHwy-5-W
52.7	75.7	86.4	97.8							53.8	15,12
T	R	U	C	K	S						ClearviewHwy-5-W
114.5	126.7	139.8	153.4	166.8	178.7					72.9	12
W	E	S	T								ClearviewHwy-5-W
94.6	117.6	128.4	139.8							53.8	15,12
L	a	k	e	S	t						ClearviewHwy-5-W-R
48	60.4	76.3	90.2	101.9	117.2	131.3				91.2	16,13

FILE NAME =	DESIGNED - SEW	REVISED -
#FILEL#	DRAWN - SEW	REVISED -
USER NAME = #USER#	CHECKED - FML	REVISED -
PLOT DATE = #DATE#	DATE - 12/2009	REVISED -



STATE OF ILLINOIS
DEPARTMENT OF TRANSPORTATION

SIGNING DETAILS

SCALE: N.T.S. SHEET NO. 22 OF 58 SHEETS STA. TO STA.

F.A.I. RTE.	SECTION	COUNTY	TOTAL SHEETS	SHEET NO.
290	2009-099BR	COOK/DUPAGE	394	350
FED. ROAD DIST. NO. [ILLINOIS] FED. AID PROJECT			CONTRACT NO. 60157	