


SIGN DETAIL  
1:75

WB-TR-37  
STA. 354+50

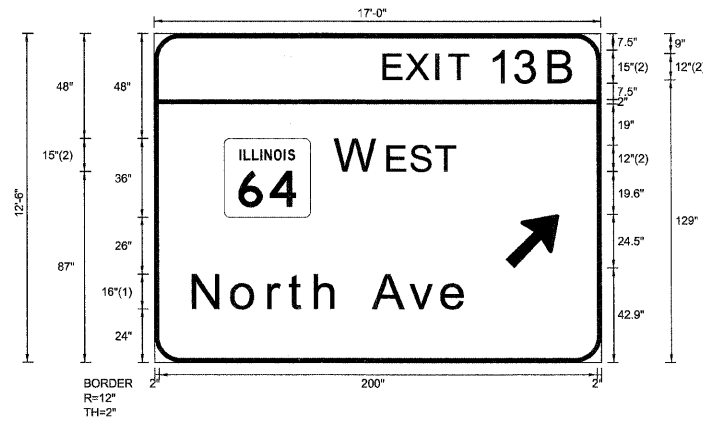

Panel Style: sign\_default.ssi  
Dimensions are in inches.tenths

FONT:  
(1) ClearviewHwy-5-W-R  
(2) ClearviewHwy-5-W

Letter locations are panel edge to lower left corner

SIGN NUMBER	name
WIDTH x HGHT.	17'-0" x 12'-6"
BORDER WIDTH	2"
CORNER RADIUS	12"
MOUNTING	Overhead
BACKGROUND	TYPE: Reflective
	COLOR: Green
LEGEND/BORDER	TYPE: Reflective
	COLOR: White/White

SYMBOL	ROT	X	Y	WID	HT
MI-1100A-2-22-100	0	32	66	39.3	36
ARMED	45	160.4	42.9	20	31.5

LETTER POSITIONS (X)								LENGTH	SERIESSIZE
E	X	I	T	1	3	B			ClearviewHwy-5-W
105.4	113.9	125.3	130.3	147.5	158.8	174.6		80.6	10,15
W	E	S	T						ClearviewHwy-5-W
83.3	103	113.8	125.2					50.5	12
N	o	r	t	h		A	v	e	ClearviewHwy-5-W-R
18	35.7	52.5	61.9	73.7	84.8	100.3	116.8	131.5	125.3

FILE NAME =	DESIGNED - SEW	REVISED -
\$FILEL\$	DRAWN - SEW	REVISED -
USER NAME = #USER#	CHECKED - FML	REVISED -
PLOT DATE = #DATE#	DATE - 12/2009	REVISED -

**E** LIN ENGINEERING,LTD.  
Consulting Engineers  
Channah, Illinois Westmont, Illinois

STATE OF ILLINOIS  
DEPARTMENT OF TRANSPORTATION

SIGNING DETAILS			
SCALE: N.T.S.	SHEET NO. 31 OF 58 SHEETS	STA.	TO STA.

F.A.I. RTE.	SECTION	COUNTY	TOTAL SHEETS	SHEET NO.
290	2009-099BR	COOK/DUPAGE	394	359
FED. ROAD DIST. NO.			ILLINOIS FED. AID PROJECT	
			CONTRACT NO. 60157	