


SIGN DETAIL
1:75

EB-BM-95
STA. 916+10

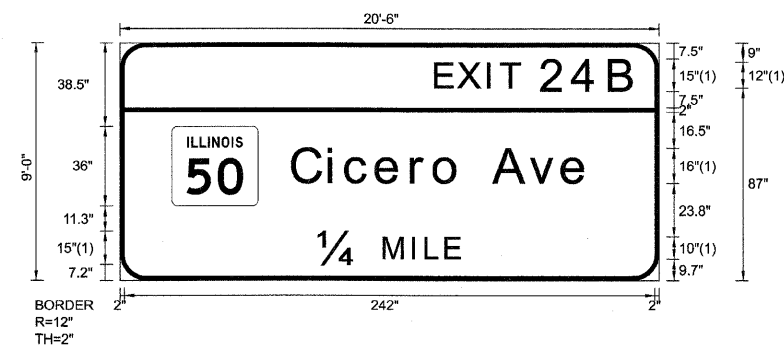

SIGN NUMBER	name
WIDTH x HGHT.	20'-6" x 9'-0"
BORDER WIDTH	2"
CORNER RADIUS	12"
MOUNTING	Overhead
BACKGROUND	TYPE: Reflective COLOR: Green
LEGEND/BORDER	TYPE: Reflective COLOR: White/White


SYMBOL	ROT	X	Y	WID	HT
M1-H00A-2-22-10D	0	23.7	33.5	39.3	36

Panel Style: sign_default.ssi
Dimensions are in inches.tenths

Letter locations are panel edge to lower left corner

LETTER POSITIONS (X)															LENGTH	SERIESSIZE				
E	X	I	T	2	4	B												ClearviewHwy-5-W		
144.4	154.7	168.3	174.2	192.9	207.4	224.1												91	12.15	
C	i	c	e	r	o	A	v	e											ClearviewHwy-5-W-R	
79	95.5	103.3	117.2	133.4	143.7	156	170.9	187.4	202.1									134.9	16/13	
1/4	M	I	L	E															ClearviewHwy-5-W	
90.8	120.8	133.9	139.8	148.9															64.5	15.10

FILE NAME =	DESIGNED - SEW	REVISED -
#FILE#	DRAWN - SEW	REVISED -
USER NAME = #USER#	CHECKED - SEW	REVISED -
PLOT DATE = #DATE#	DATE - 1/25/10	REVISED -

 

STATE OF ILLINOIS
DEPARTMENT OF TRANSPORTATION

SIGNING DETAILS
SCALE: N.T.S. SHEET NO. 2 OF 34 SHEETS STA. TO STA.

F.A.I. RTE.	SECTION	COUNTY	TOTAL SHEETS	SHEET NO.
290	(2727, ETC., 3131)RS-7	COOK	216	126
CONTRACT NO. 60G53				
FED. ROAD DIST. NO. ILLINOIS FED. AID PROJECT				