


SIGN DETAIL

1:75

EB-BM-96
STA. 931+80

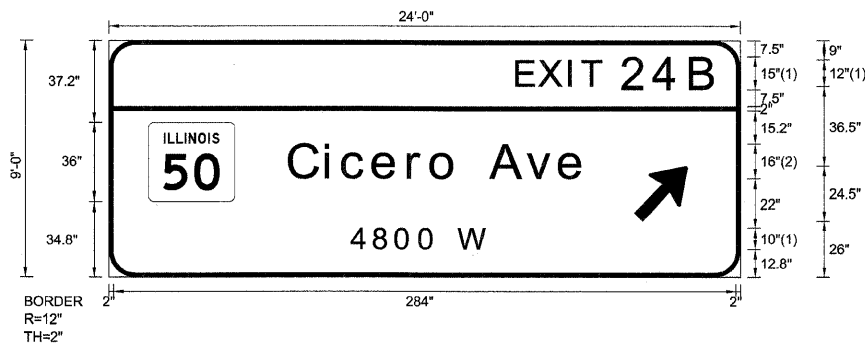

FONT:
(1) ClearviewHwy-5-W
(2) ClearviewHwy-5-W-R

Panel Style: sign_default.ssi
Dimensions are in inches.tenths

Letter locations are paneledge to lower left corner

SIGN NUMBER	name
WIDTH x HGHT.	24'-0" x 9'-0"
BORDER WIDTH	2"
CORNER RADIUS	12"
MOUNTING	Overhead
BACKGROUND	TYPE: Reflective COLOR: Green
LEGEND/BORDER	TYPE: Reflective COLOR: WhiteWhite

SYMBOL	ROT	X	Y	WID	HT
M1-1100A-2-22-10D	0	18	34.8	39.3	36
ARMED	45	239.5	26	20	31.5

LETTER POSITIONS (X)

											LENGTH	SERIESSIZE
E	X	I	T	2	4	B						ClearviewHwy-5-W
186.4	196.7	210.3	216.2	234.9	249.4	266.1					91	12,15
C	i	c	e	r	o	A	v	e				ClearviewHwy-5-W-R
82.6	99.1	106.9	120.8	137	147.3	159.6	174.5	191	205.8		134.9	1613
4	8	0	0	W								ClearviewHwy-5-W-R
110.8	121	131	141.9	150	159.5						61.9	10

FILE NAME =	DESIGNED - SEW	REVISED -
#FILEL#	DRAWN - SEW	REVISED -
USER NAME = #USER#	CHECKED - SEW	REVISED -
PLOT DATE = #DATE#	DATE - 1/25/10	REVISED -



STATE OF ILLINOIS
DEPARTMENT OF TRANSPORTATION

SIGNING DETAILS

SCALE: N.T.S. SHEET NO. 3 OF 34 SHEETS STA. TO STA.

F.A.I. RTE.	SECTION	COUNTY	TOTAL SHEETS	SHEET NO.
290	(2727, ETC., 3131)RS-7	COOK	216	127
FED. ROAD DIST. NO.		ILLINOIS FED. AID PROJECT		
CONTRACT NO. 60C53				