


SIGN DETAIL  
1:75

EB-BM-108  
STA. 1064+30

SIGN NUMBER	name
WIDTH x HGHT.	17'-0" x 8'-0"
BORDER WIDTH	2"
CORNER RADIUS	12"
MOUNTING	Overhead
BACKGROUND	TYPE: Reflective
	COLOR: Green
LEGEND/BORDER	TYPE: Reflective
	COLOR: White/White

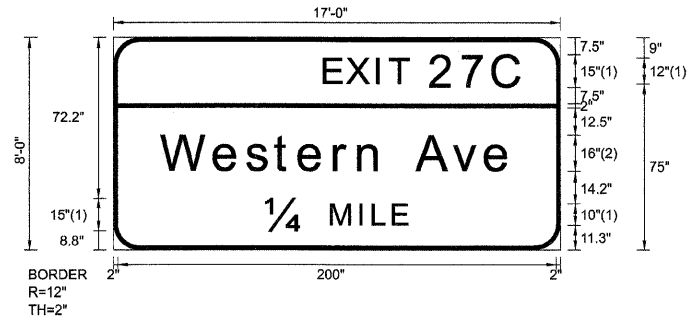

FONT:  
(1) ClearviewHwy-5-W  
(2) ClearviewHwy-5-W-R

Panel Style: sign\_default.ssi  
Dimensions are in inches.tenths

Letter locations are panel edge to lower left corner

SYMBOL	ROT	X	Y	WID	HT

LETTER POSITIONS (X)

		LETTER POSITIONS (X)										LENGTH	SERIESSIZE
E	X	I	T	2	7	C							ClearviewHwy-5-W
96.7	107	120.7	126.6	145.2	159.4	173.8							89.3 12,15
W	e	s	t	e	r	n	A	v	e				ClearviewHwy-5-W-R
22.2	46.4	61.1	73.9	85.1	101.3	112.3	123.3	138.8	155.4	170.1			159.6 1613
14	M	I	L	E									ClearviewHwy-5-W
69.8	99.8	112.9	118.8	127.9									64.5 15,10

FILE NAME =	DESIGNED - SEW	REVISED -
*FILEL*	DRAWN - SEW	REVISED -
USER NAME = *USER*	CHECKED - SEW	REVISED -
PLOT DATE = *DATE*	DATE - 1/25/10	REVISED -



STATE OF ILLINOIS  
DEPARTMENT OF TRANSPORTATION

SIGNING DETAILS			
SCALE: N.T.S.	SHEET NO. 11 OF 34 SHEETS	STA.	TO STA.

F.A.I. RTE.	SECTION	COUNTY	TOTAL SHEETS	SHEET NO.
290	(2727, ETC., 3131)RS-7	COOK	216	135
CONTRACT NO. 60G53				
FED. ROAD DIST. NO. ILLINOIS FED. AID PROJECT				