 


 



 

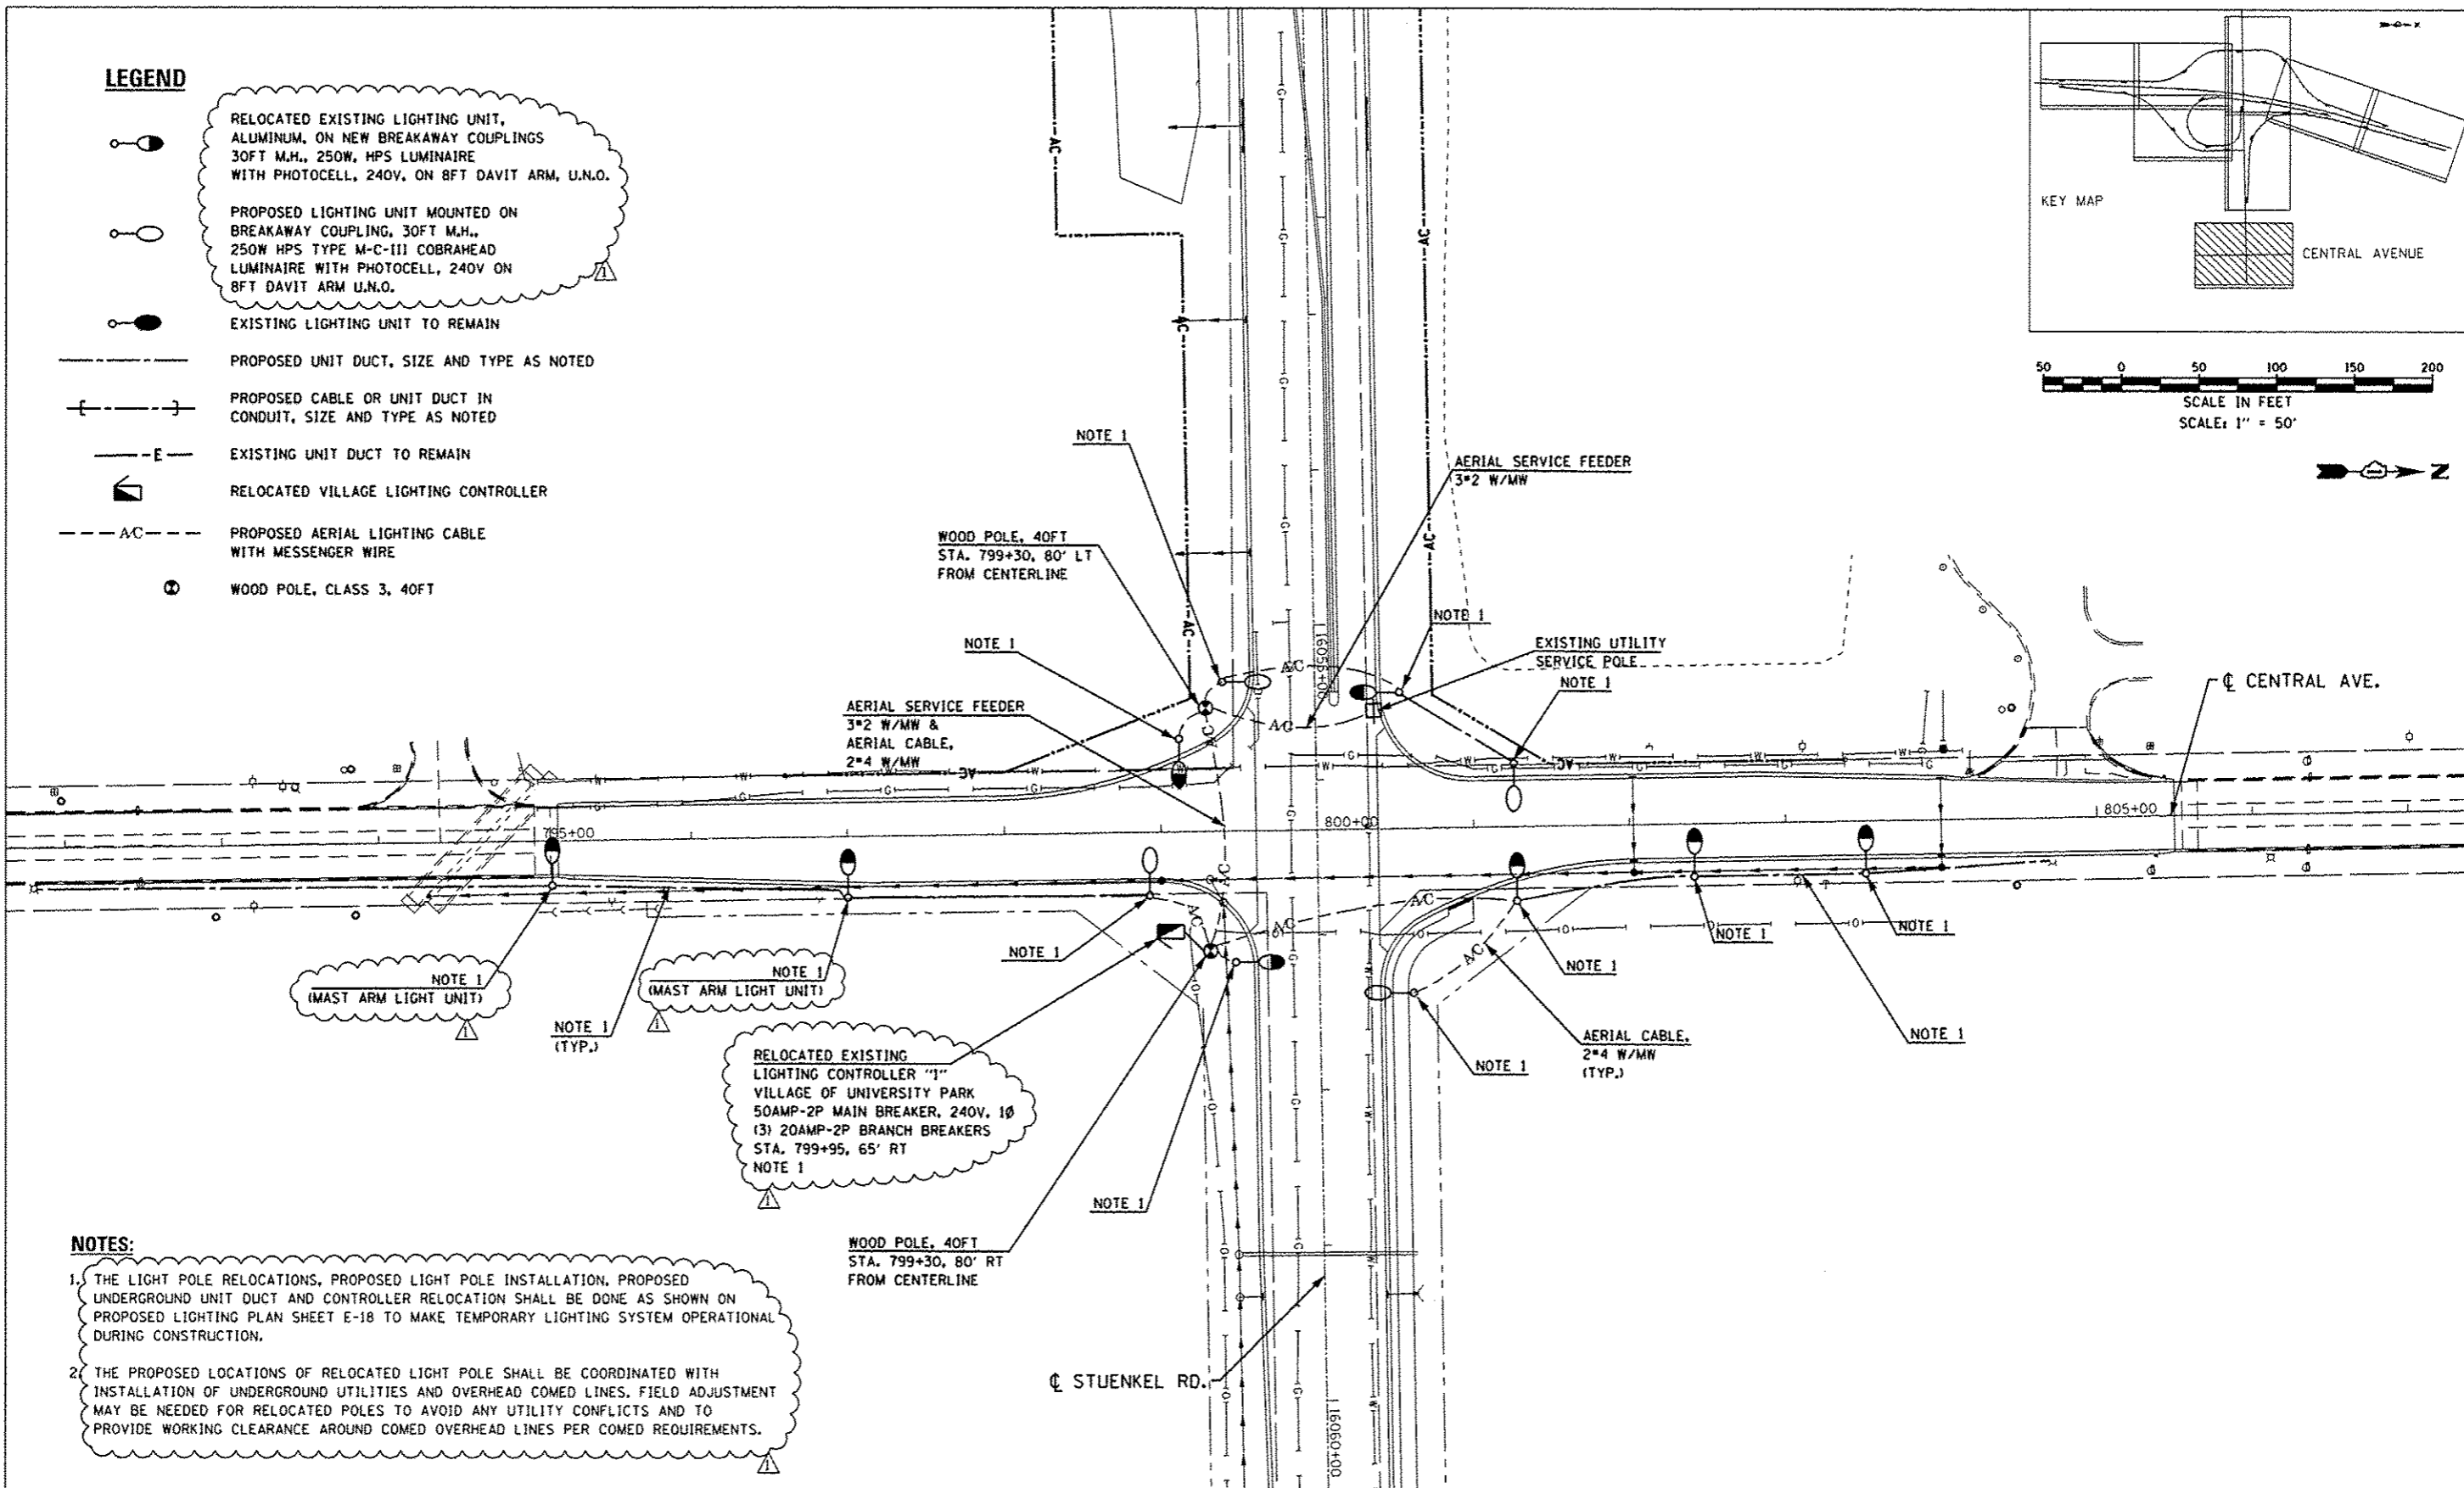
 
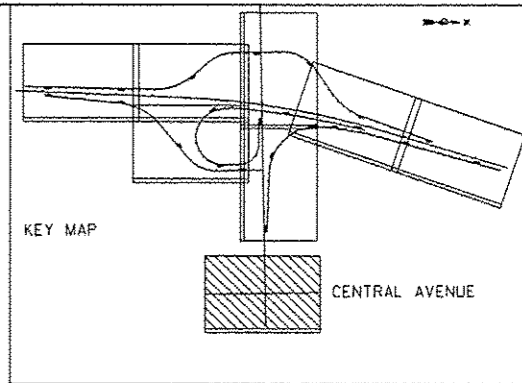


**LEGEND**

-  RELOCATED EXISTING LIGHTING UNIT, ALUMINUM, ON NEW BREAKAWAY COUPLINGS 30FT M.H., 250W, HPS LUMINAIRE WITH PHOTOCELL, 240V, ON 8FT DAVIT ARM, U.N.O.
-  PROPOSED LIGHTING UNIT MOUNTED ON BREAKAWAY COUPLING, 30FT M.H., 250W HPS TYPE M-C-III COBRAHEAD LUMINAIRE WITH PHOTOCELL, 240V ON 8FT DAVIT ARM U.N.O.
-  EXISTING LIGHTING UNIT TO REMAIN
-  PROPOSED UNIT DUCT, SIZE AND TYPE AS NOTED
-  PROPOSED CABLE OR UNIT DUCT IN CONDUIT, SIZE AND TYPE AS NOTED
-  EXISTING UNIT DUCT TO REMAIN
-  RELOCATED VILLAGE LIGHTING CONTROLLER
-  PROPOSED AERIAL LIGHTING CABLE WITH MESSENGER WIRE
-  WOOD POLE, CLASS 3, 40FT



NOTE 1  
(MAST ARM LIGHT UNIT)

NOTE 1  
(MAST ARM LIGHT UNIT)

RELOCATED EXISTING LIGHTING CONTROLLER "1" VILLAGE OF UNIVERSITY PARK 50AMP-2P MAIN BREAKER, 240V, 1Ø (3) 20AMP-2P BRANCH BREAKERS STA. 799+95, 65' RT  
NOTE 1

WOOD POLE, 40FT STA. 799+30, 80' RT FROM CENTERLINE

**NOTES:**

1. THE LIGHT POLE RELOCATIONS, PROPOSED LIGHT POLE INSTALLATION, PROPOSED UNDERGROUND UNIT DUCT AND CONTROLLER RELOCATION SHALL BE DONE AS SHOWN ON PROPOSED LIGHTING PLAN SHEET E-18 TO MAKE TEMPORARY LIGHTING SYSTEM OPERATIONAL DURING CONSTRUCTION.
2. THE PROPOSED LOCATIONS OF RELOCATED LIGHT POLE SHALL BE COORDINATED WITH INSTALLATION OF UNDERGROUND UTILITIES AND OVERHEAD COMED LINES. FIELD ADJUSTMENT MAY BE NEEDED FOR RELOCATED POLES TO AVOID ANY UTILITY CONFLICTS AND TO PROVIDE WORKING CLEARANCE AROUND COMED OVERHEAD LINES PER COMED REQUIREMENTS.

J:\3271.DGN\CADD\_Sheets\60L69-shr-light-18.dgn 26-DEC-2013 15:02 TIME



USER NAME = kprajapati	DESIGNED - RDP	REVISED 6/18/2013
	DRAWN - MG/WC	REVISED 8/22/2013
PLOT SCALE = 100.000000/1.000000	CHECKED - KGP	REVISED 10/18/2013
PLOT DATE = 26-DEC-2013 15:02	DATE - 8/22/2013	REVISED 12/04/2013

STATE OF ILLINOIS  
DEPARTMENT OF TRANSPORTATION

STUENKEL ROAD OVER I-57  
TEMPORARY LIGHTING PLANS STUENKEL RD AT CENTRAL AVE.

F.A.I. RTE. 57	SECTION 99-1HB-R	COUNTY WILL	TOTAL SHEETS 679	SHEET NO. 342
				CONTRACT NO. 60L69
ILLINOIS FED. AID PROJECT				