
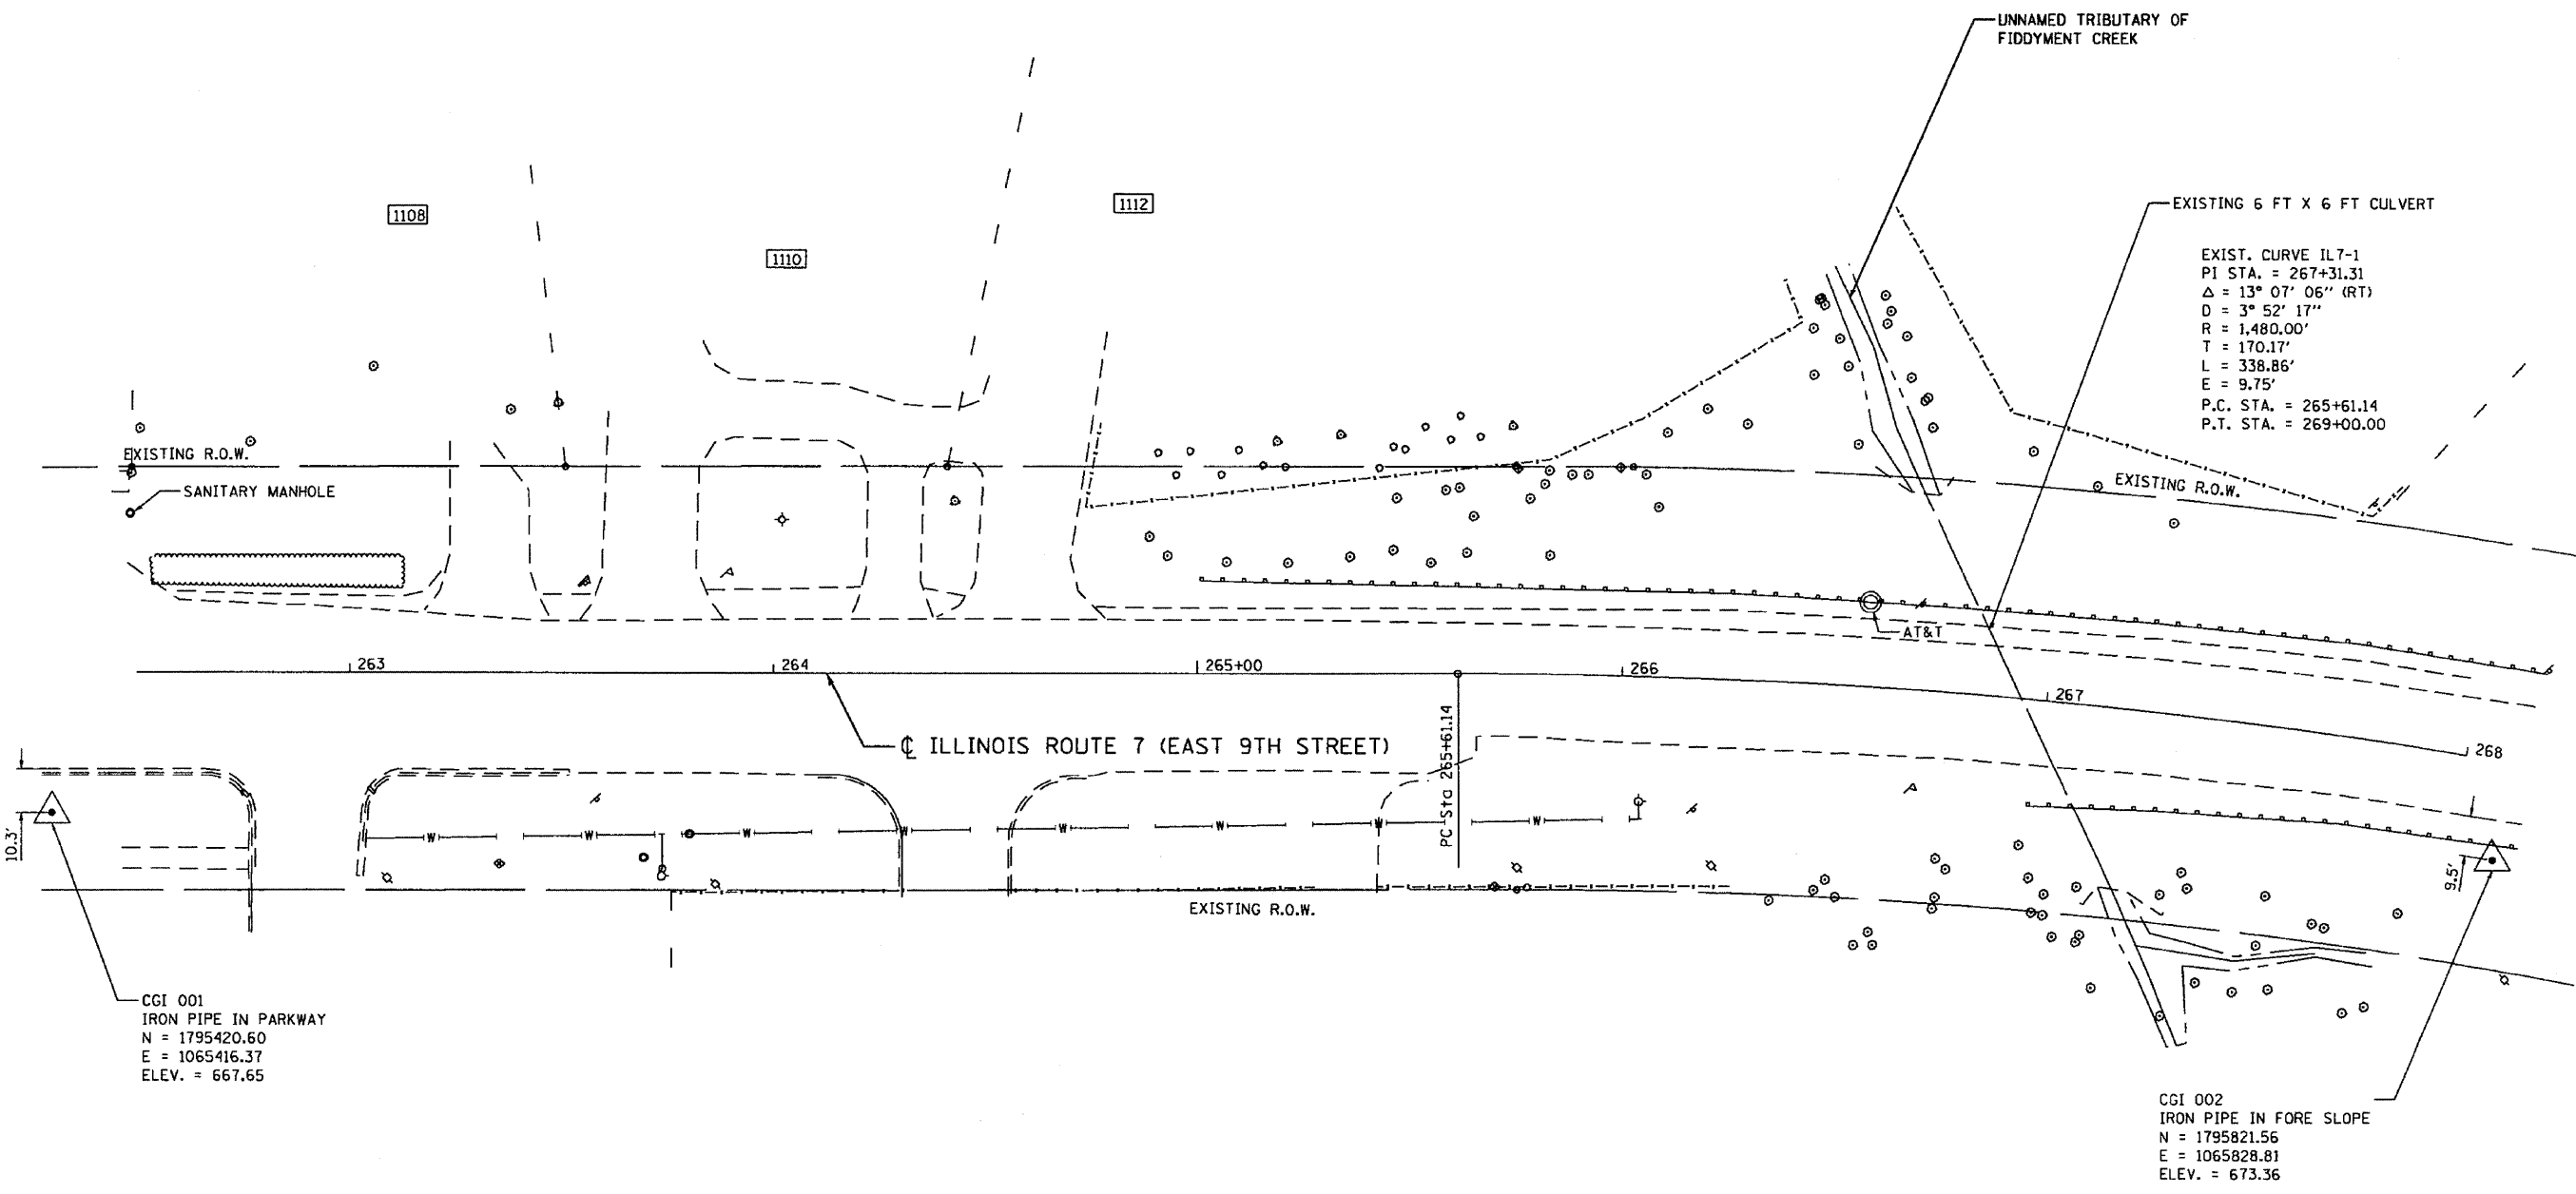


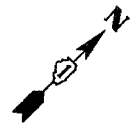

ILLINOIS ROUTE 7 (EAST 9TH STREET) ALIGNMENT

STATION	NORTHING	EASTING
POT 263+00.00	1,795,493.73	1,065,442.12
PC 265+61.14	1,795,679.26	1,065,625.89
PT 269+00.00	1,795,890.73	1,065,889.72

LEGEND

XXXX ADDRESS

NOTE:
SEE DRAINAGE PLAN AND PROFILE
FOR DRAINAGE ITEMS.

FILE NAME: s:\projects\3368\3368-37\Drawings\Proposed\Plan\3368-37-46-1-PLAN2.dwg



Ciorba Group, Inc.
CONSULTING ENGINEERS
5507 North Cumberland Avenue, Suite 402
Chicago, Illinois 60658
Tel. 773.778.4009 Fax 773.778.4014

USER NAME = wloncastar	DESIGNED - AL	REVISED -
	DRAWN - AL	REVISED -
PLOT SCALE = 48.0000' / IN.	CHECKED - DMM	REVISED -
PLOT DATE = 12/3/2009	DATE = 12/11/09	REVISED -

**STATE OF ILLINOIS
DEPARTMENT OF TRANSPORTATION**

**IL 7 / 159TH STREET
IL 53 (INDEPENDENCE BLVD) TO I-355 (VETERANS MEMORIAL TOLLWAY)
EXISTING ROADWAY PLAN**

SCALE: 1" = 20' SHEET NO. 14 OF 35 SHEETS STA. 263+50 TO STA. 268+00

F.A.P. RTE.	SECTION	COUNTY	TOTAL SHEETS	SHEET NO.
351	(535 B-6R & 536) RS-4	WILL	35	14
CONTRACT NO. 60H62				
FED. ROAD DIST. NO. 1 ILLINOIS FED. AID PROJECT				