
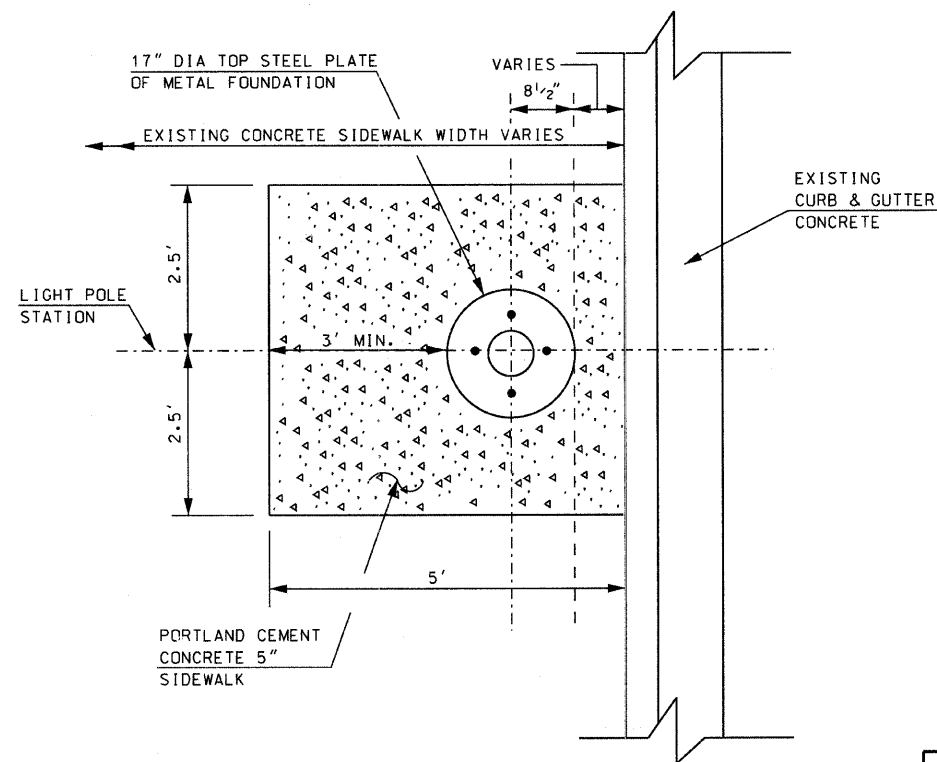


SAW CUT SIDEWALK REMOVAL DETAILS

SAW CUT AND SIDEWALK REMOVAL AT THE FOLLOWING STATIONS

PLAN SHEET #E-5	9+30 (RT), 10+05 (RT), 10+80 (RT), 11+55 (RT), 12+45 (LT & RT), 13+30 (LT & RT), 14+15 (LT & RT), 15+05 (LT & RT), 15+95 (LT & RT), 16+85 (LT & RT)
PLAN SHEET #E-6	17+75 (LT & RT), 18+65 (LT & RT), 19+50 (LT & RT), 20+35 (LT & RT), 21+20 (LT & RT), 21+90 (LT & RT), 22+75 (LT & RT), 23+60 (LT & RT), 24+50 (RT)

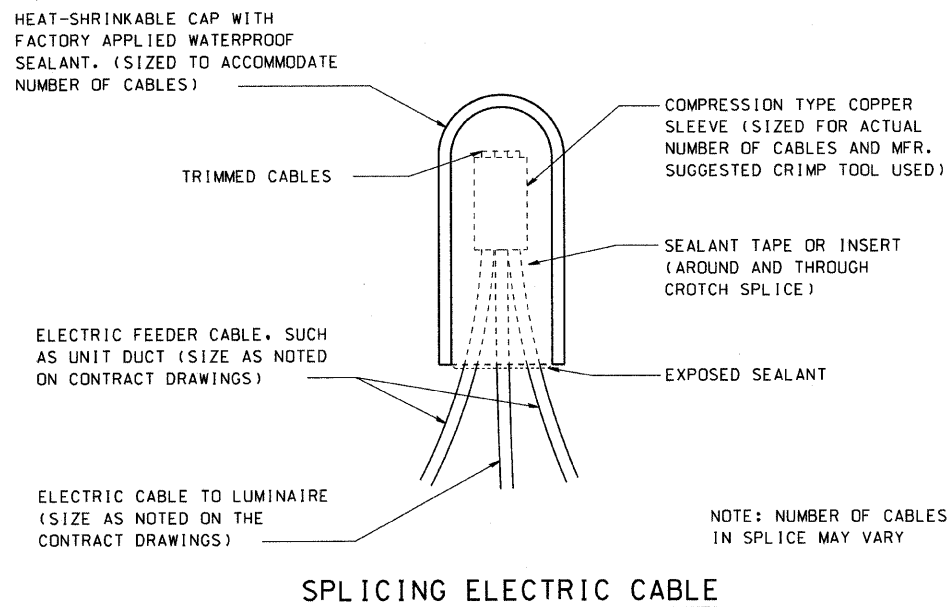

METAL FOUNDATION LOCATION AND PORTLAND CEMENT CONCRETE SIDEWALK DETAILS

REVISED 11-22-09

Sunjoy Inc.
Area Lighting
Consulting Engineers
212 TIMBERCREST DRIVE
SCHAUMBURG, ILLINOIS
60193-1572

THIS DRAWING IS THE EXCLUSIVE PROPERTY OF SUNJOY INC. AND IS PROVIDED ONLY FOR THE PROJECT LISTED ON THIS DRAWING. THIS DRAWING SHALL NOT BE DUPLICATED, USED OR DISCLOSED, IN WHOLE OR IN PART, FOR ANY PURPOSE WHATSOEVER WITHOUT THE WRITTEN PERMISSION OF SUNJOY INC.

REVISIONS	
NAME	DATE

ILLINOIS DEPARTMENT OF TRANSPORTATION
CITY OF BRAIDWOOD, WILL COUNTY
ILLINOIS ROUTE 113 (MAIN STREET)
ORNAMENTAL LIGHTING IMPROVEMENT

ELECTRICAL DETAILS

SCALE: NTS
DATE: 10-15-09

DRAWN BY: HKQ
CHECKED BY: JS

