

 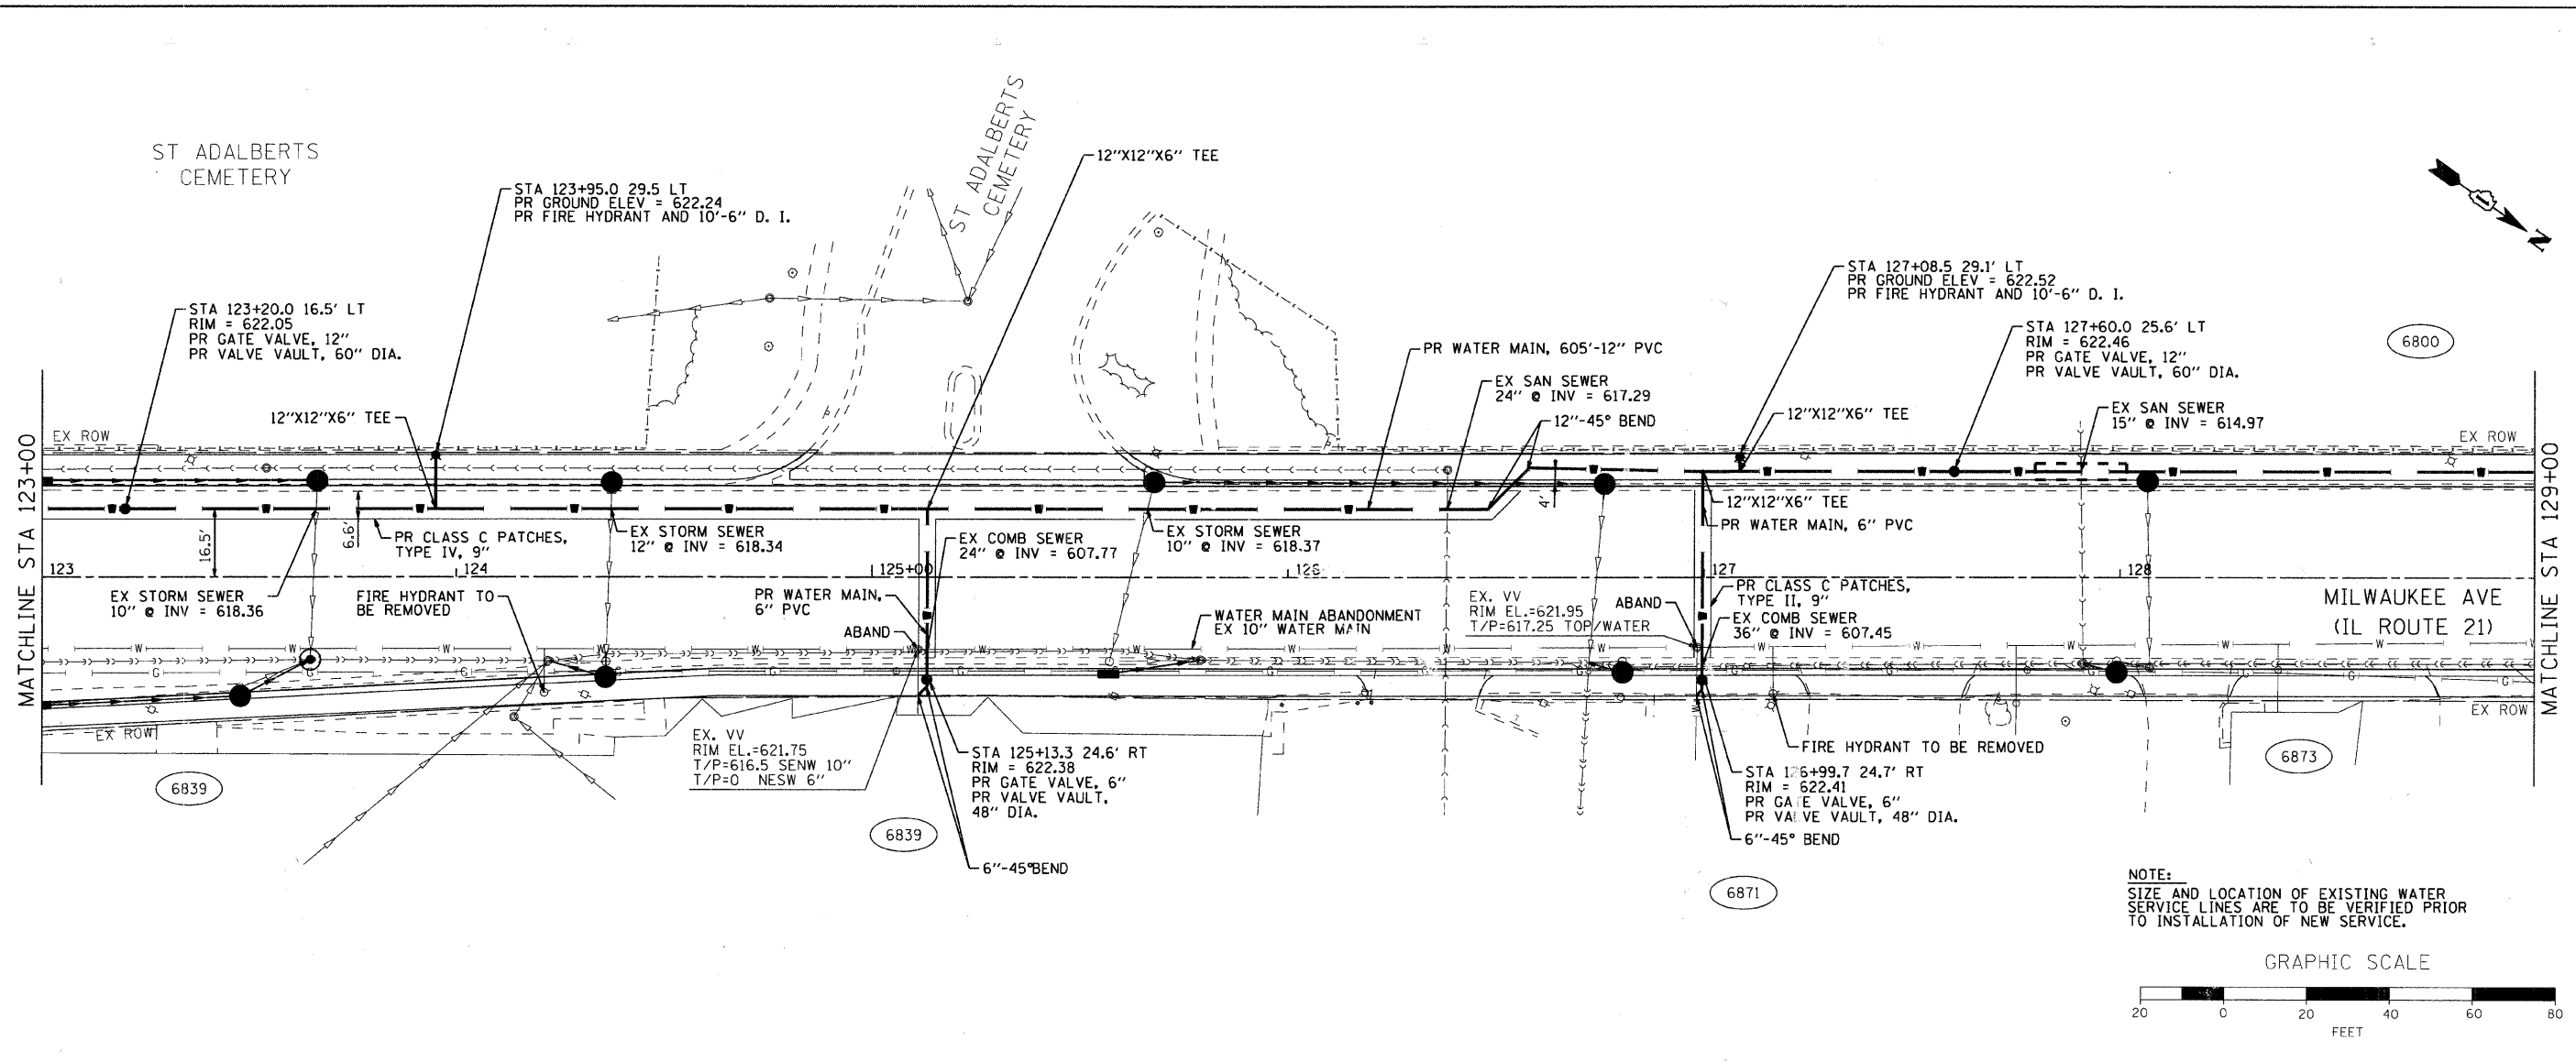


DATE	
BY	
DESIGNED	
CHECKED	
PLANNED	
NOTED	
NO.	

DATE	
BY	
DESIGNED	
CHECKED	
PLANNED	
NOTED	
NO.	

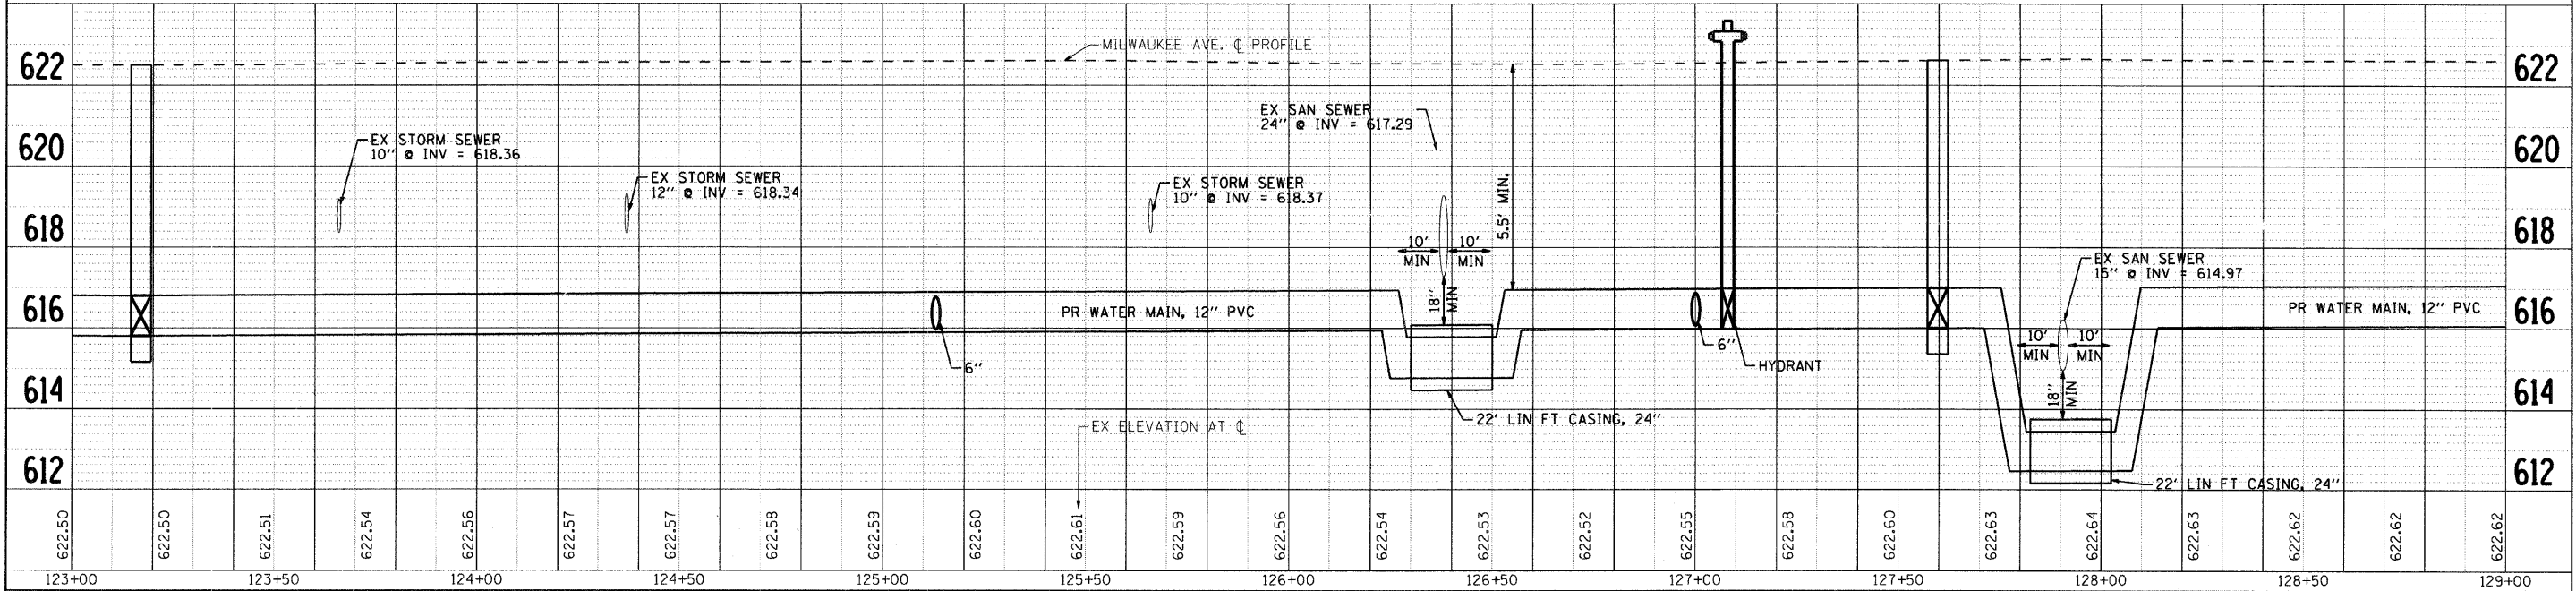

NOTE:  
 SIZE AND LOCATION OF EXISTING WATER  
 SERVICE LINES ARE TO BE VERIFIED PRIOR  
 TO INSTALLATION OF NEW SERVICE.



123+00	123+50	124+00	124+50	125+00	125+50	126+00	126+50	127+00	127+50	128+00	128+50	129+00
622.50	622.50	622.51	622.54	622.55	622.57	622.57	622.58	622.59	622.60	622.61	622.61	622.62

**SEC Group, Inc.**  
 Surveying  
 Planning  
 Landscape Architecture  
 Illinois • Texas • Georgia  
 www.secgroupinc.com

USER NAME = char tke	DESIGNED - JPA	REVISED -
PLOT SCALE = 1" = 20'	DRAWN - CMH	REVISED -
PLOT DATE = 1/16/2009	CHECKED - JLP	REVISED -
	DATE - 12/16/08	REVISED -

**VILLAGE OF NILES**

**PROPOSED WATER MAIN PLAN AND PROFILE**

SCALE: 1" = 20'    SHEET NO. 4 OF 10 SHEETS    STA. 123+00.00 TO STA. 129+00.00

F.A. RTE. 3513	SECTION 08-00107-01-PV	COUNTY COOK	TOTAL SHEETS 169	SHEET NO. 41
FED. ROAD DIST. NO.		ILLINOIS FED. AID PROJECT M-8003(723)		