


LEGEND

	EXISTING ELECTRIC CABLE
	FIBER OPTIC
	LIGHTING
	PROPOSED 3-1C No. 6, 1" UNIT DUCT
	PROPOSED CONDUIT INTERMEDIATE METAL
	PROPOSED LIGHT/LIGHTPOLE FOUNDATION

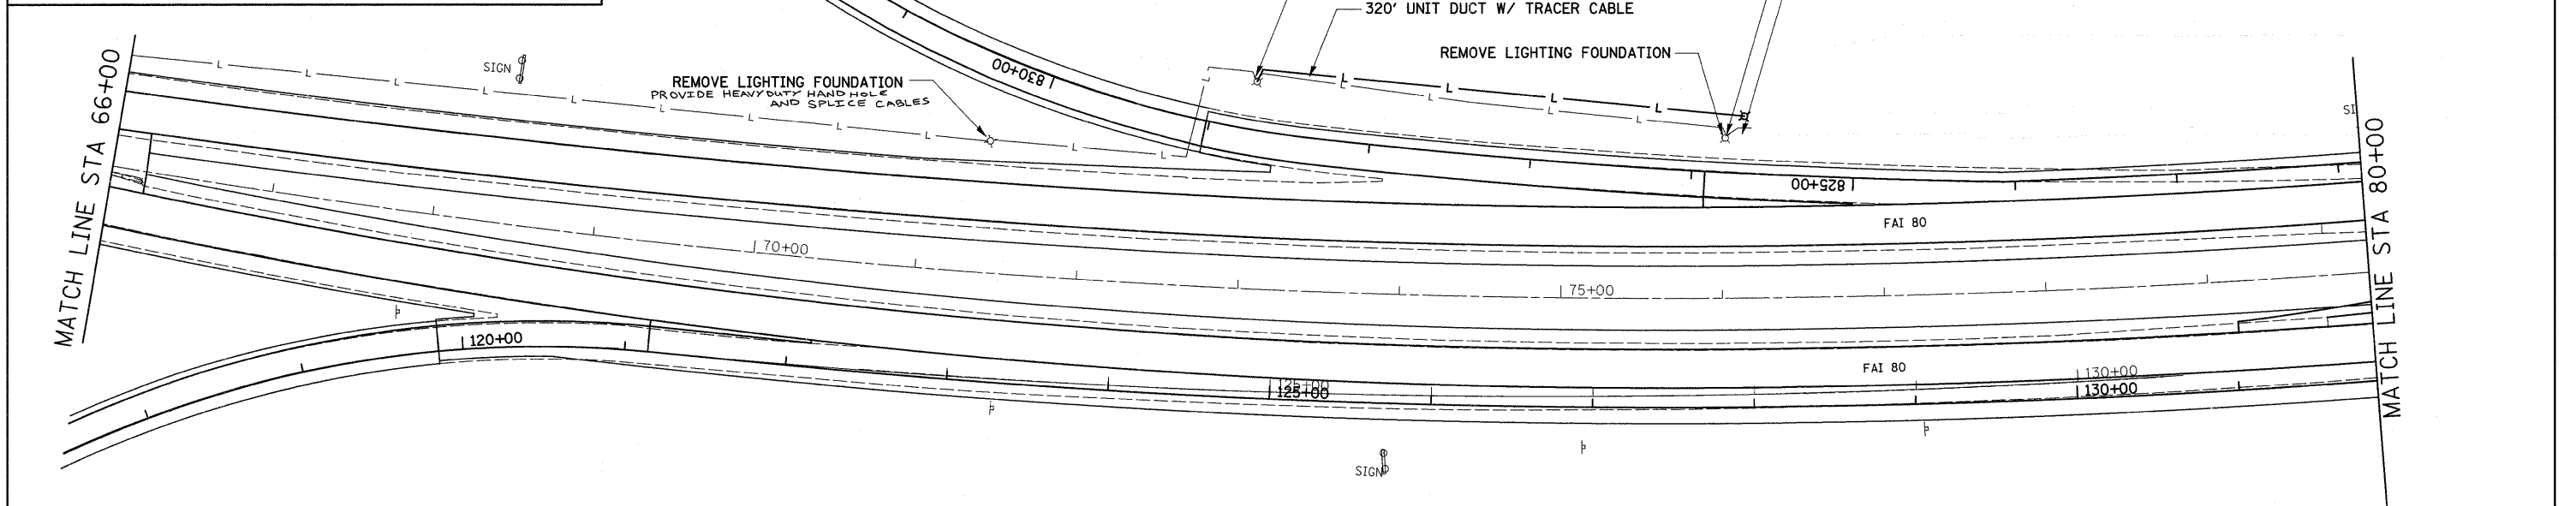

FILE NAME =	USER NAME = grantpm	DESIGNED -	REVISED -	STATE OF ILLINOIS DEPARTMENT OF TRANSPORTATION	I-80 ELECTRICAL DETAILS			F.A.I. RTE.	SECTION	COUNTY	TOTAL SHEETS	SHEET NO.
ct:\pw_work\pwidot\grantpm\dms34287\d084	33e1ecv.dgn	DRAWN -	REVISED -					80	(81-1)R-1	ROCK ISLAND	292	160
	PLOT SCALE = 50.0000' / IN.	CHECKED -	REVISED -					CONTRACT NO. 64933				
	PLOT DATE = Mon Dec 15 08:32:23 2008	DATE -	REVISED -					SCALE:	SHEET NO.	OF SHEETS	STA.	TO STA.