


F.A.D. RTE.	SECTION	COUNTY	TOTAL SHEETS	SHEET NO.
6713	05-00148-00-PV	TAZEWELL	74	30
STA. 145+50.00		TO STA. 156+60.00		
FED. ROAD DIST. NO. 4 ILLINOIS FED. AID PROJECT				

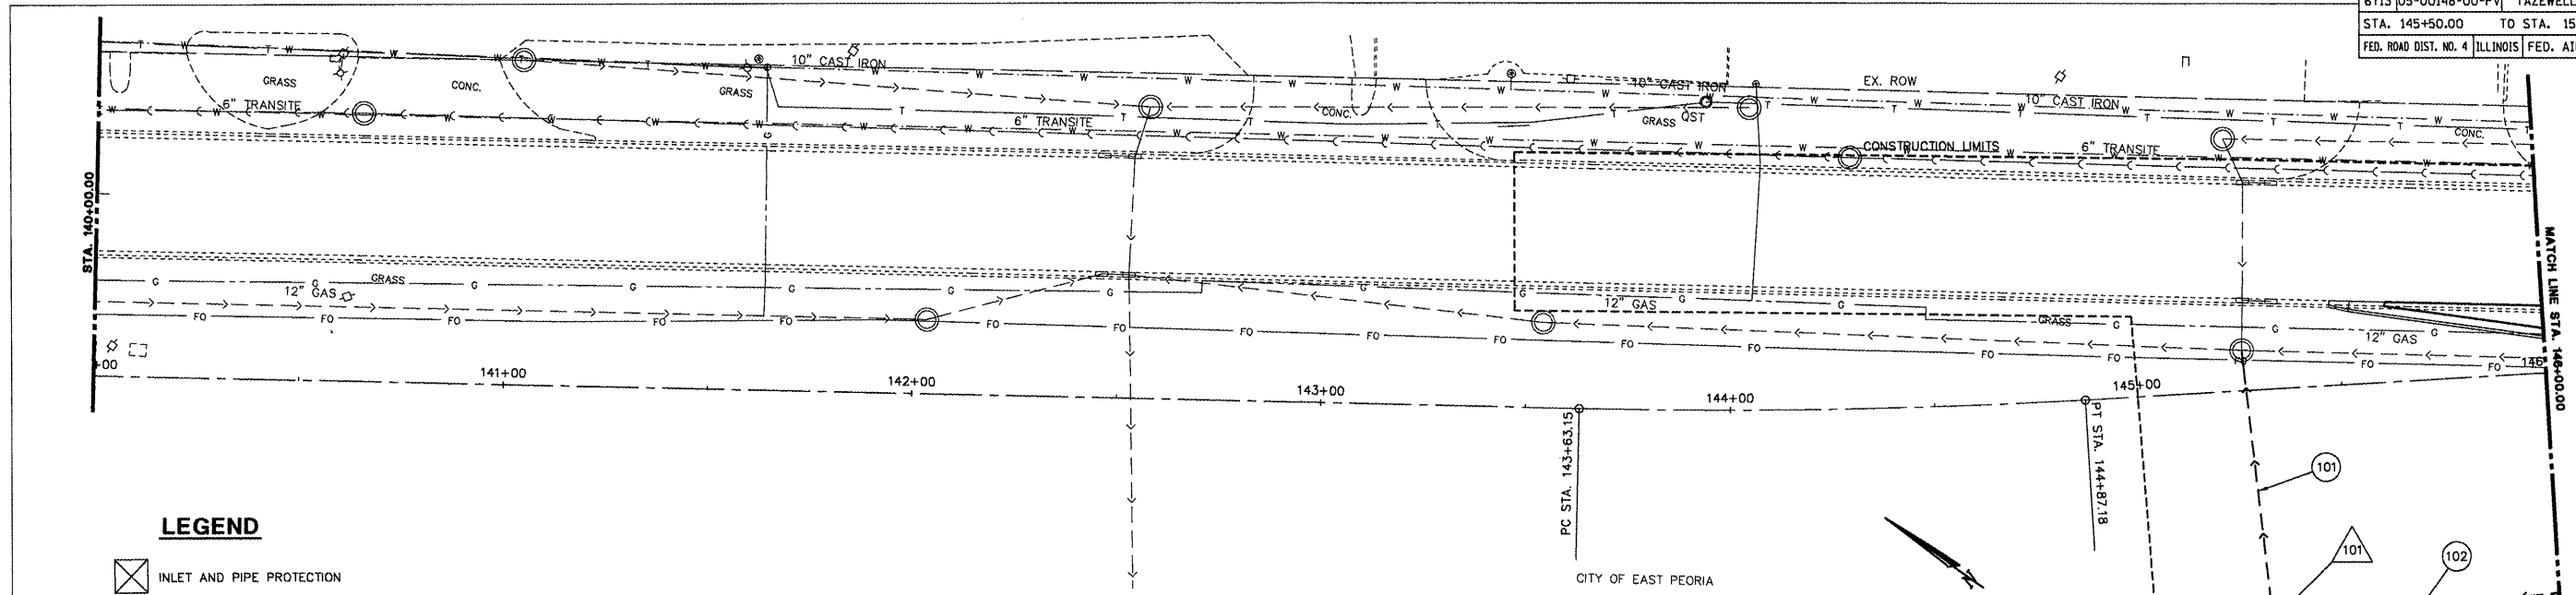

LEGEND

- INLET AND PIPE PROTECTION
- INLET FILTERS
- PERIMETER EROSION BARRIER
- STRUCTURE NUMBER
- PIPE NUMBER


PIPE SCHEDULE								
PIPE NO.	U/S - D/S	LENGTH (FT)	SIZE (IN)	CLASS/TYPE	U/S INV	D/S INV	SLOPE	REMARKS
101	101-EX. MH	65	30	SS CL A 2	449.52	449.24	0.43%	
102	102-101	166	27	SS CL A 2	450.00	449.52	0.29%	

STORM SEWER NOTE:
 PROVIDE A KNOCKOUT IN STRUCTURE 101 AT THE ELEVATION SHOWN ON THE SCHEDULE FOR A FUTURE 30" STORM SEWER. THE KNOCKOUT SHOULD BE 90' FROM PIPE 101 AND 180' FROM PIPE 102.



SPECIAL WASTE NOTE:
 WHEN WORKING IN AREAS LABELED "CONSTRUCTION WORKER CAUTION", THE WEARING OF LONG PANTS, LONG SLEEVE SHIRTS, GLOVES, SAFETY GLASSES, HATS OR HARD HATS (AS APPLICABLE) IS APPROPRIATE. ADDITIONALLY, NORMAL PERSONAL HYGIENE PROCEDURES SHOULD BE FOLLOWED I.E. THROUGH CLEANUP WITH SOAP AND WATER FOLLOWING WORK ACTIVITIES.

STRUCTURE SCHEDULE											
STR. NO.	STATION	OFFSET	RT/LT	TYPE	F&G	RIM E.	INV. N	INV. S	INV. E	INV. W	REMARKS
101	STA. 145+29.75	56.60	RT	MANHOLES, TYPE A, 5'-DIAMETER, TYPE 1 F&G, OPEN	TY 1 OPEN	457.50	449.52	449.52	449.52		INV. N = KNOCKOUT

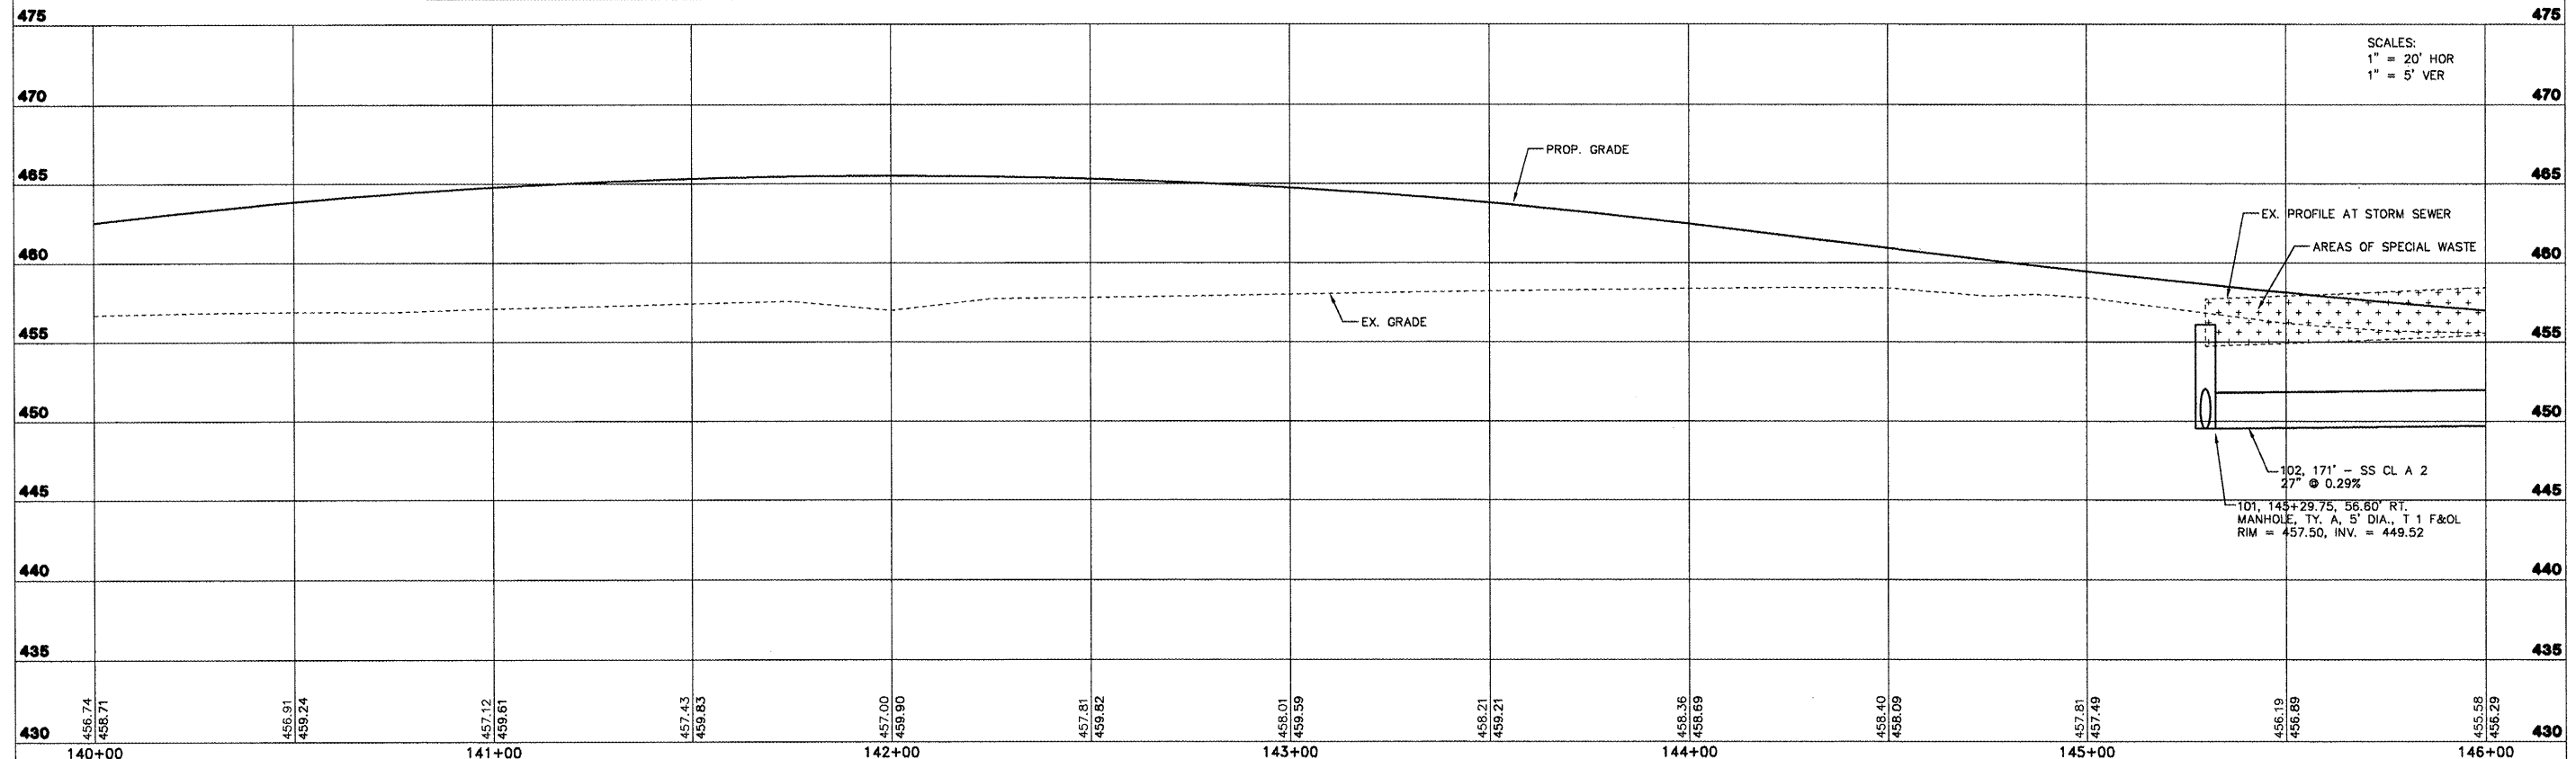

SCALES:
 1" = 20' HOR
 1" = 5' VER

CAMP STREET - DRAINAGE AND EROSION CONTROL PLAN AND PROFILE - STA. 140+00 TO STA. 146+00

L:\830218\89\08000001.dwg