
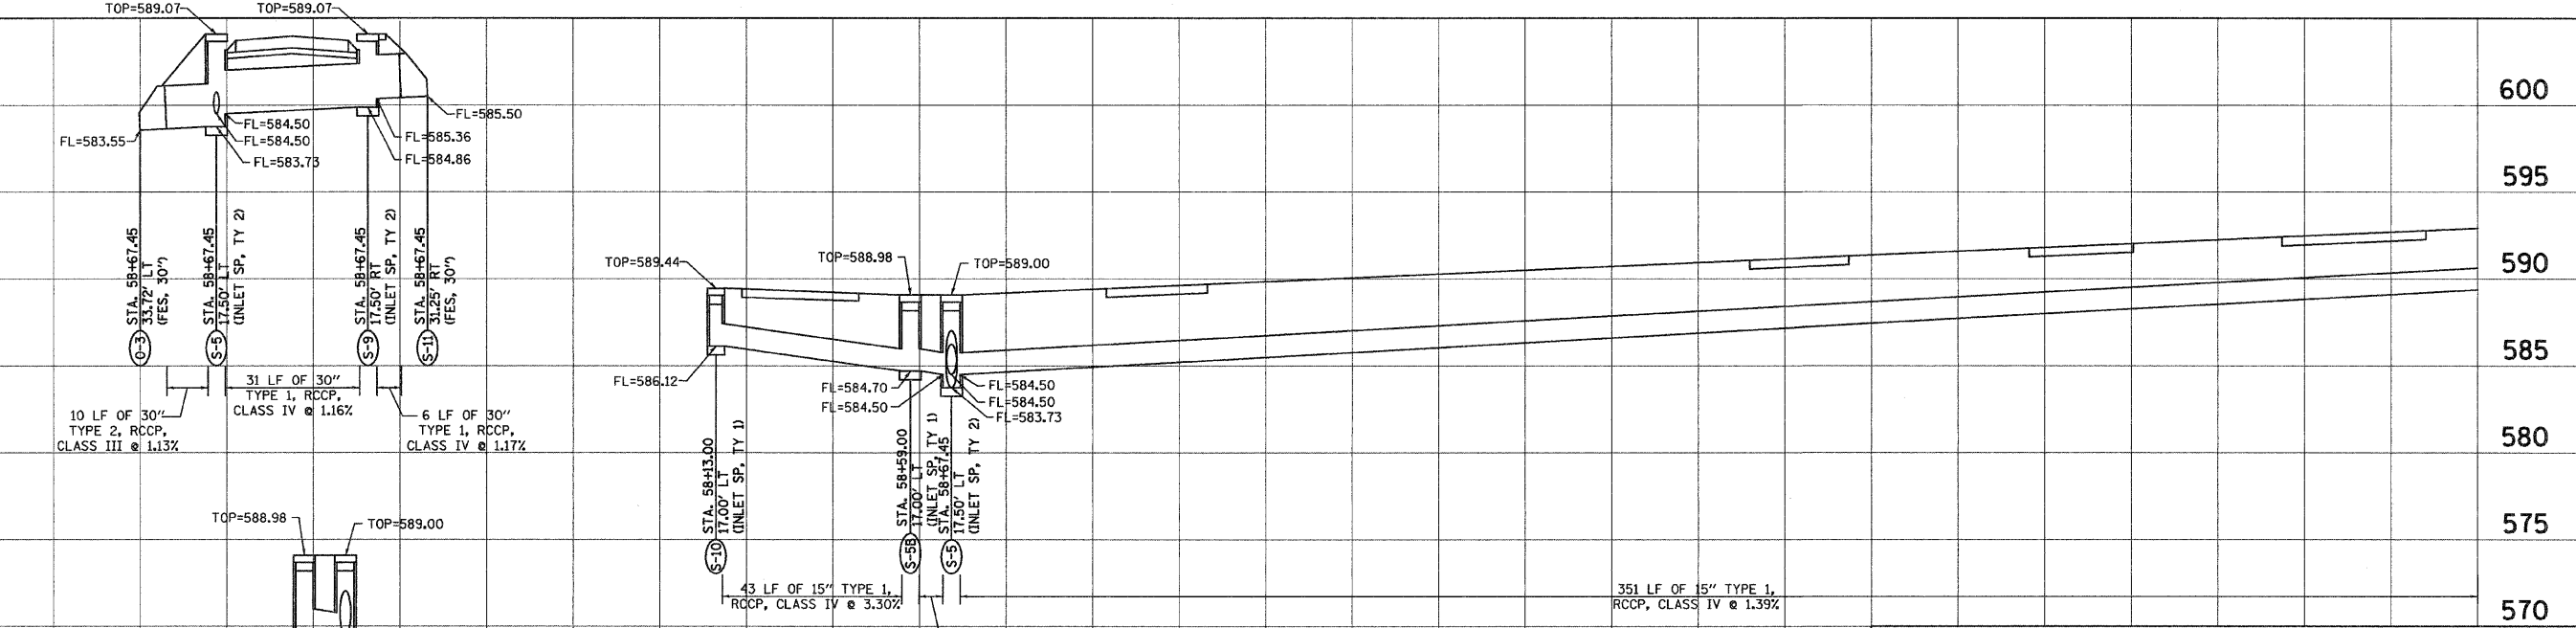


F.A.U. RTE.	SECTION	COUNTY	TOTAL SHEETS	SHEET NO.
8899	05-0026-01-RP	MADISON	81	38
FED. ROAD DIST. NO. ILLINOIS			FED. AID PROJECT	
CONTRACT NO. 87368				

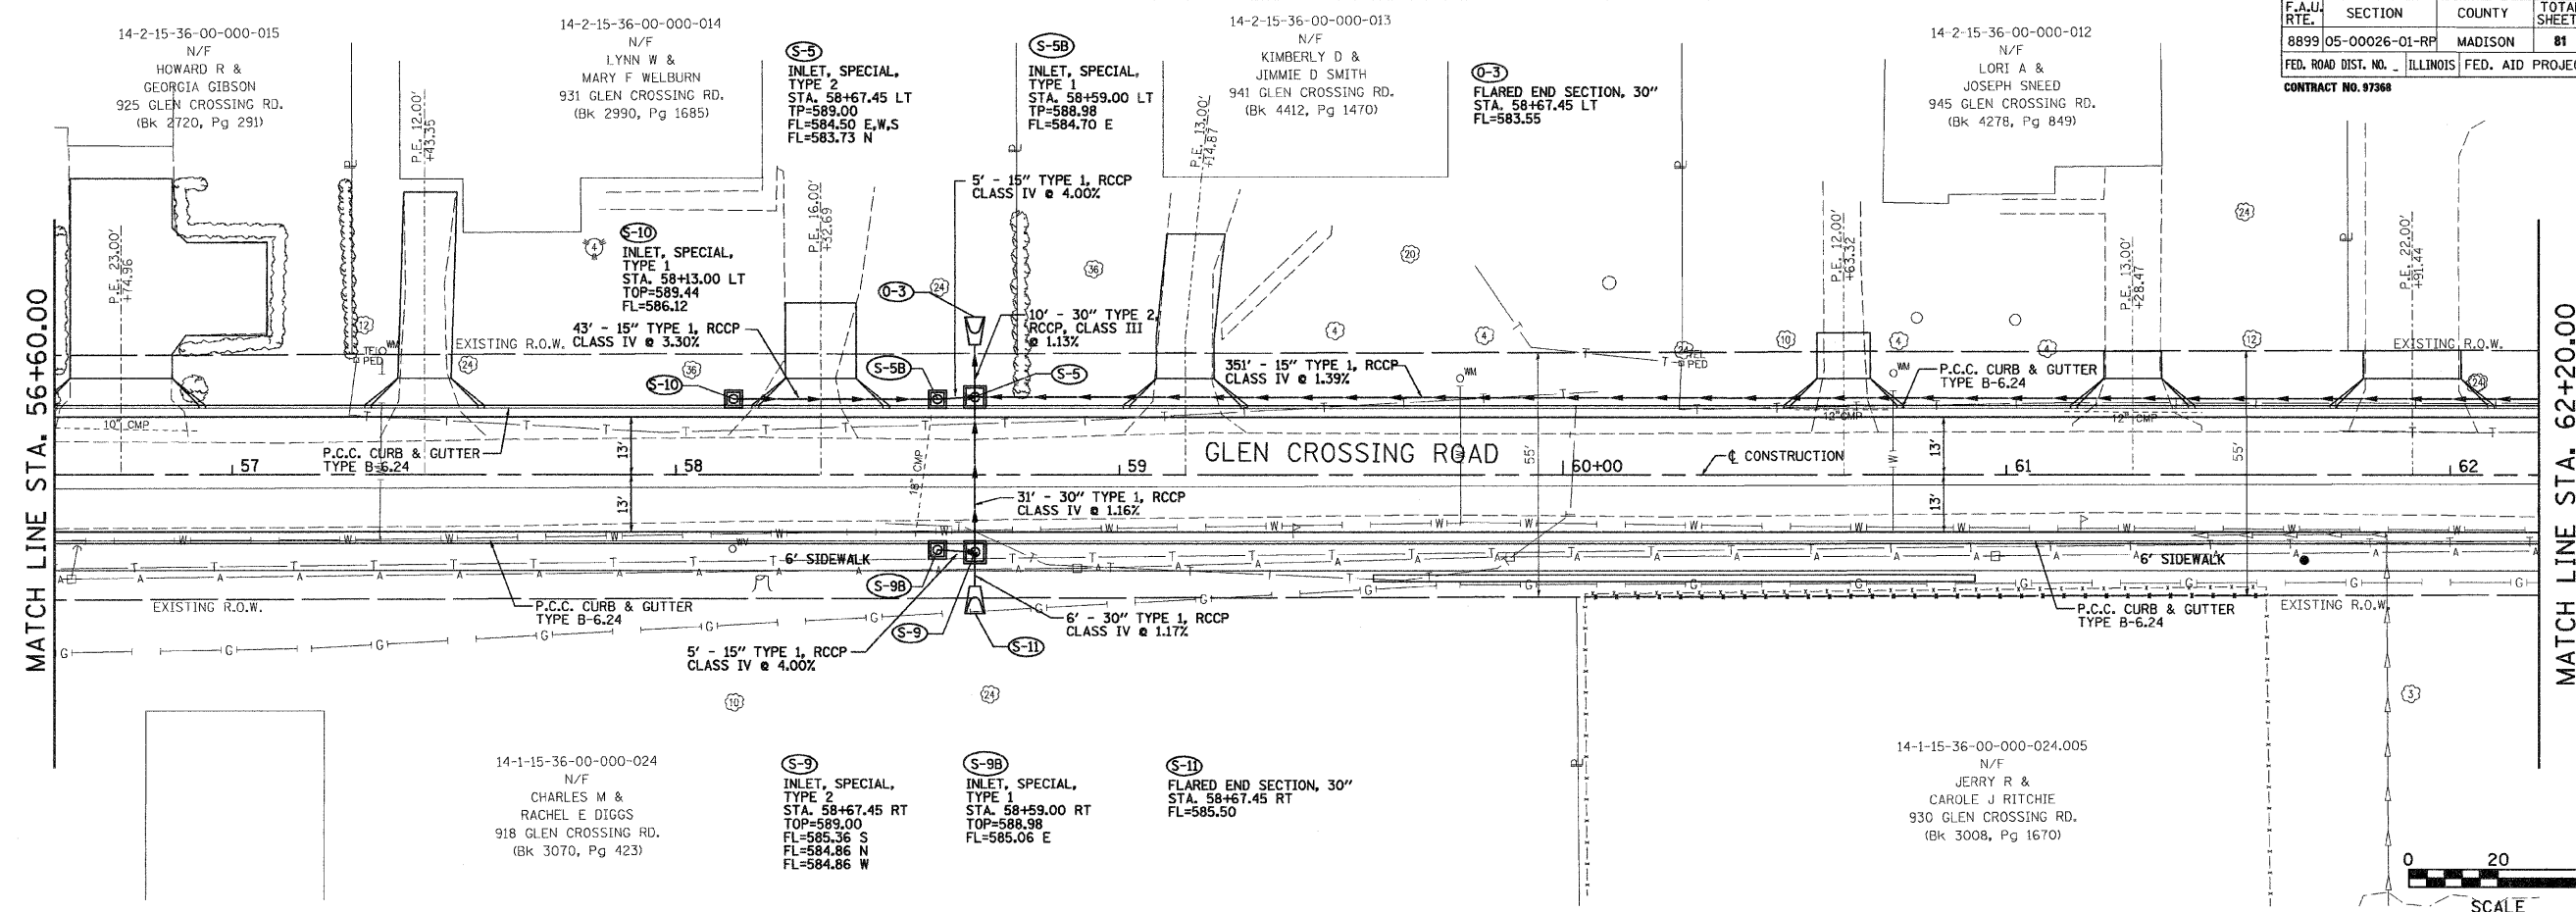

BY	DATE
FINAL SURVEYED SURVEY PLOTTED NOTE BOOK TEMPLATE AREAS CHECKED	
NO.	

BY	DATE
ORIGINAL SURVEYED SURVEY PLOTTED NOTE BOOK TEMPLATE	

Jureau Associates, Inc. P.C.
CONSULTING ENGINEERS AND LAND SURVEYORS
2100 State Street, P.O. Box 1325
Granite City, Illinois 62040
Phone: (618) 381-4400 / (618) 462-5633
Fax: (618) 462-5641

DRAINAGE PLAN AND PROFILE
F.A.U. ROUTE 8899
GLEN CROSSING ROAD PHASE 2
GLEN CARBON, ILLINOIS
SECTION No. 05-0026-01-RP

REVISIONS		
NO.	DATE	REMARKS

SCALE: 1 Inch = 20 feet		
DSN. BY: BFK	DATE: 4/30/08	SHEET 38
DWN. BY: JDH	DATE: 4/30/08	
CHK'D: BFK	DATE: 4/30/08	JOB NO. E070614B DGN. NAME: DRAIN_05 OF 81 SHTS
DWG. NO.		