 


LEGEND

- EXISTING BUILDING
- EXISTING CONTOUR
- EXISTING GAS LINE
- EXISTING ELECTRIC LINE
- EXISTING ELECTRICAL DUCT
- EXISTING LIGHT POLE
- EXISTING TELEPHONE LINE
- EXISTING TELEPHONE BOX/ELECTRICAL TRANSFORMER
- EXISTING SPLICE CAN
- EXISTING FAA CABLE
- EXISTING STORM SEWER
- EXISTING STORM SEWER STRUCTURE
- EXISTING SANITARY SEWER
- EXISTING FIRE HYDRANT
- EXISTING WATERMAIN
- NEW WATERMAIN
- NEW WATER VAULT

REVISIONS


NUMBER	BY	DATE



NOTES

- CONTRACTOR SHALL FIELD VERIFY EXISTING WELL LOCATION, AND EXISTING 2" WATER LINE LOCATION, SIZE AND INVERTS BEFORE BEGINNING 4" WATERMAIN INSTALLATION AND WELL ABANDONMENT (COST INCIDENTAL TO WATERMAIN).
- CONTRACTOR SHALL FIELD VERIFY LOCATION, SIZE, MATERIAL AND INVERTS OF EXISTING SANITARY SEWER (COST INCIDENTAL TO WATERMAIN). IF EXISTING SANITARY SEWER IS 18" OR GREATER BELOW NEW WATERMAIN OR IF VERTICAL BENDS AS NECESSARY WILL PROVIDE AT LEAST 18" OF VERTICAL SEPARATION BETWEEN EXISTING SANITARY SEWER AND NEW WATERMAIN, SANITARY SEWER REMOVAL AND REPLACEMENT WILL NOT BE REQUIRED.

THE INFORMATION SHOWN ON THESE PLANS HAS BEEN OBTAINED FROM AVAILABLE RECORDS AND FIELD SURVEYS. NEITHER THE OWNER NOR THE ENGINEER ASSUMES ANY RESPONSIBILITY WITH RESPECT TO THE ACCURACY OR SUFFICIENCY OF THE INFORMATION PRESENTED HEREIN AND THERE IS NO GUARANTEE, EITHER EXPRESSED OR IMPLIED, THAT THE CONDITIONS INDICATED ARE REPRESENTATIVE OF THOSE TO BE ENCOUNTERED IN THE FIELD. IT SHALL BE THE CONTRACTOR'S RESPONSIBILITY TO VISIT THE SITE AND ACQUAINT HIMSELF WITH THE EXISTING CONDITIONS.

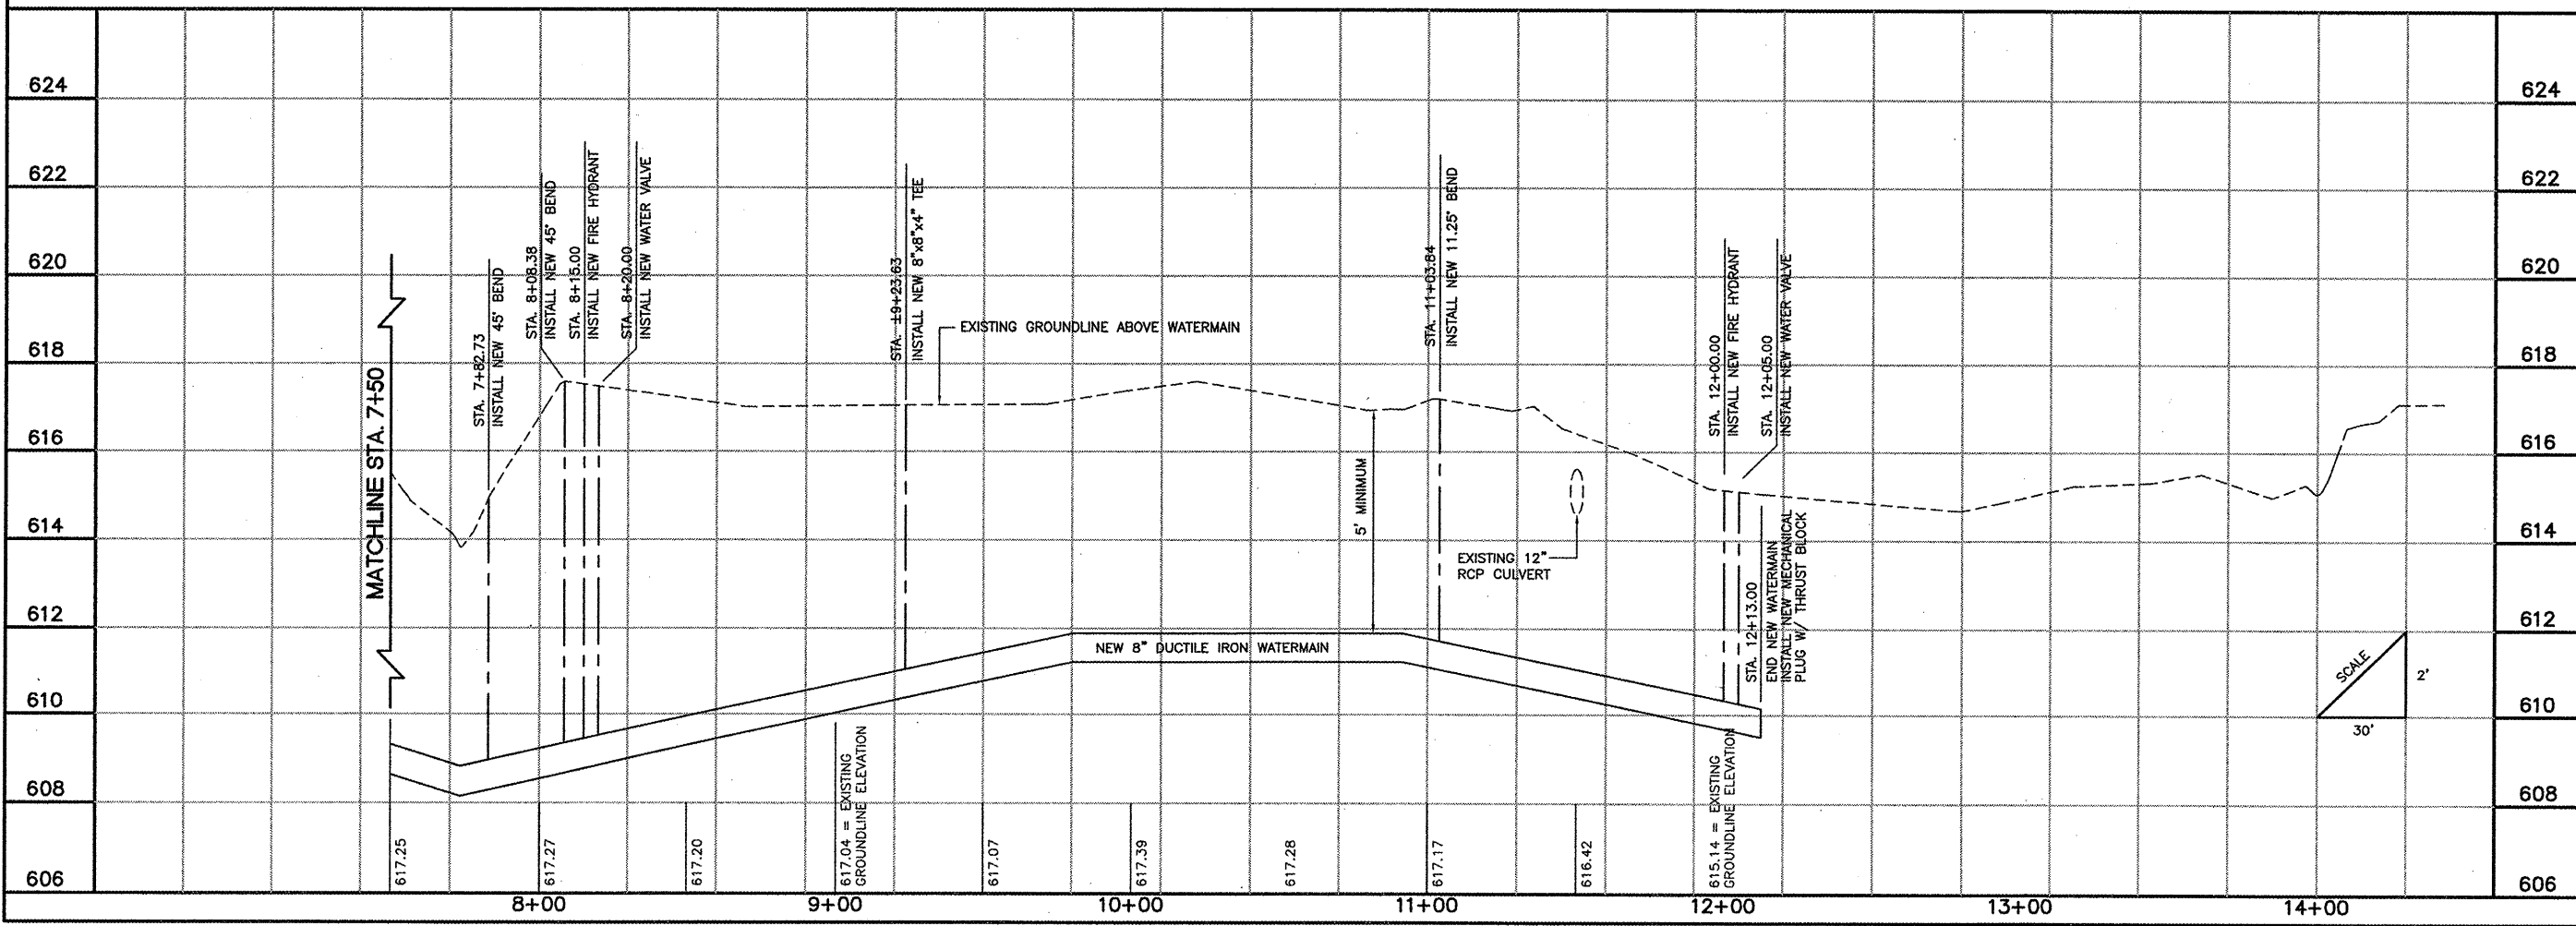

**GREATER KANKAKEE AIRPORT
KANKAKEE, ILLINOIS**

**CONSTRUCT SOUTHEAST QUADRANT FIRE PROTECTION
PLAN AND PROFILE
STA. 7+50 TO STA. 12+25.53**

© Copyright, CMT, Inc.
CMT
CRAWFORD, MURPHY & TILLY, INC.
CONSULTING ENGINEERS
License No. 184-00613

DESIGN BY:	CAL
DRAWN BY:	JRO
CHECKED BY:	CAL
APPROVED BY:	CAL
DATE:	01/26/07
JOB No:	06075-02
IL PROJECT: IKK-3661 A.I.P. PROJECT: 3-17-0057-813	

SHEET 5 OF 7 SHEETS