 


REVISIONS		
NUMBER	BY	DATE




SPARTA COMMUNITY AIRPORT  
 HUNTER FIELD  
 SPARTA, ILLINOIS

WIDEN AND OVERLAY RUNWAY 18/36  
 ELECTRICAL & LIGHTING PLAN 1

© copyright CMT, Inc.

**CMT**  
 CRAWFORD, MURPHY & TILLY, INC.  
 CONSULTING ENGINEERS  
 License No. 184-000613

DESIGN BY:	KLB
DRAWN BY:	CMT
CHECKED BY:	JEF
APPROVED BY:	JEF
DATE:	12/31/2008
JOB No:	0641203
IL PROJ. NO. SAR-3652 AIP PROJ. NO. 3-17-0094-89	
SHEET 08 OF 28 SHEETS	

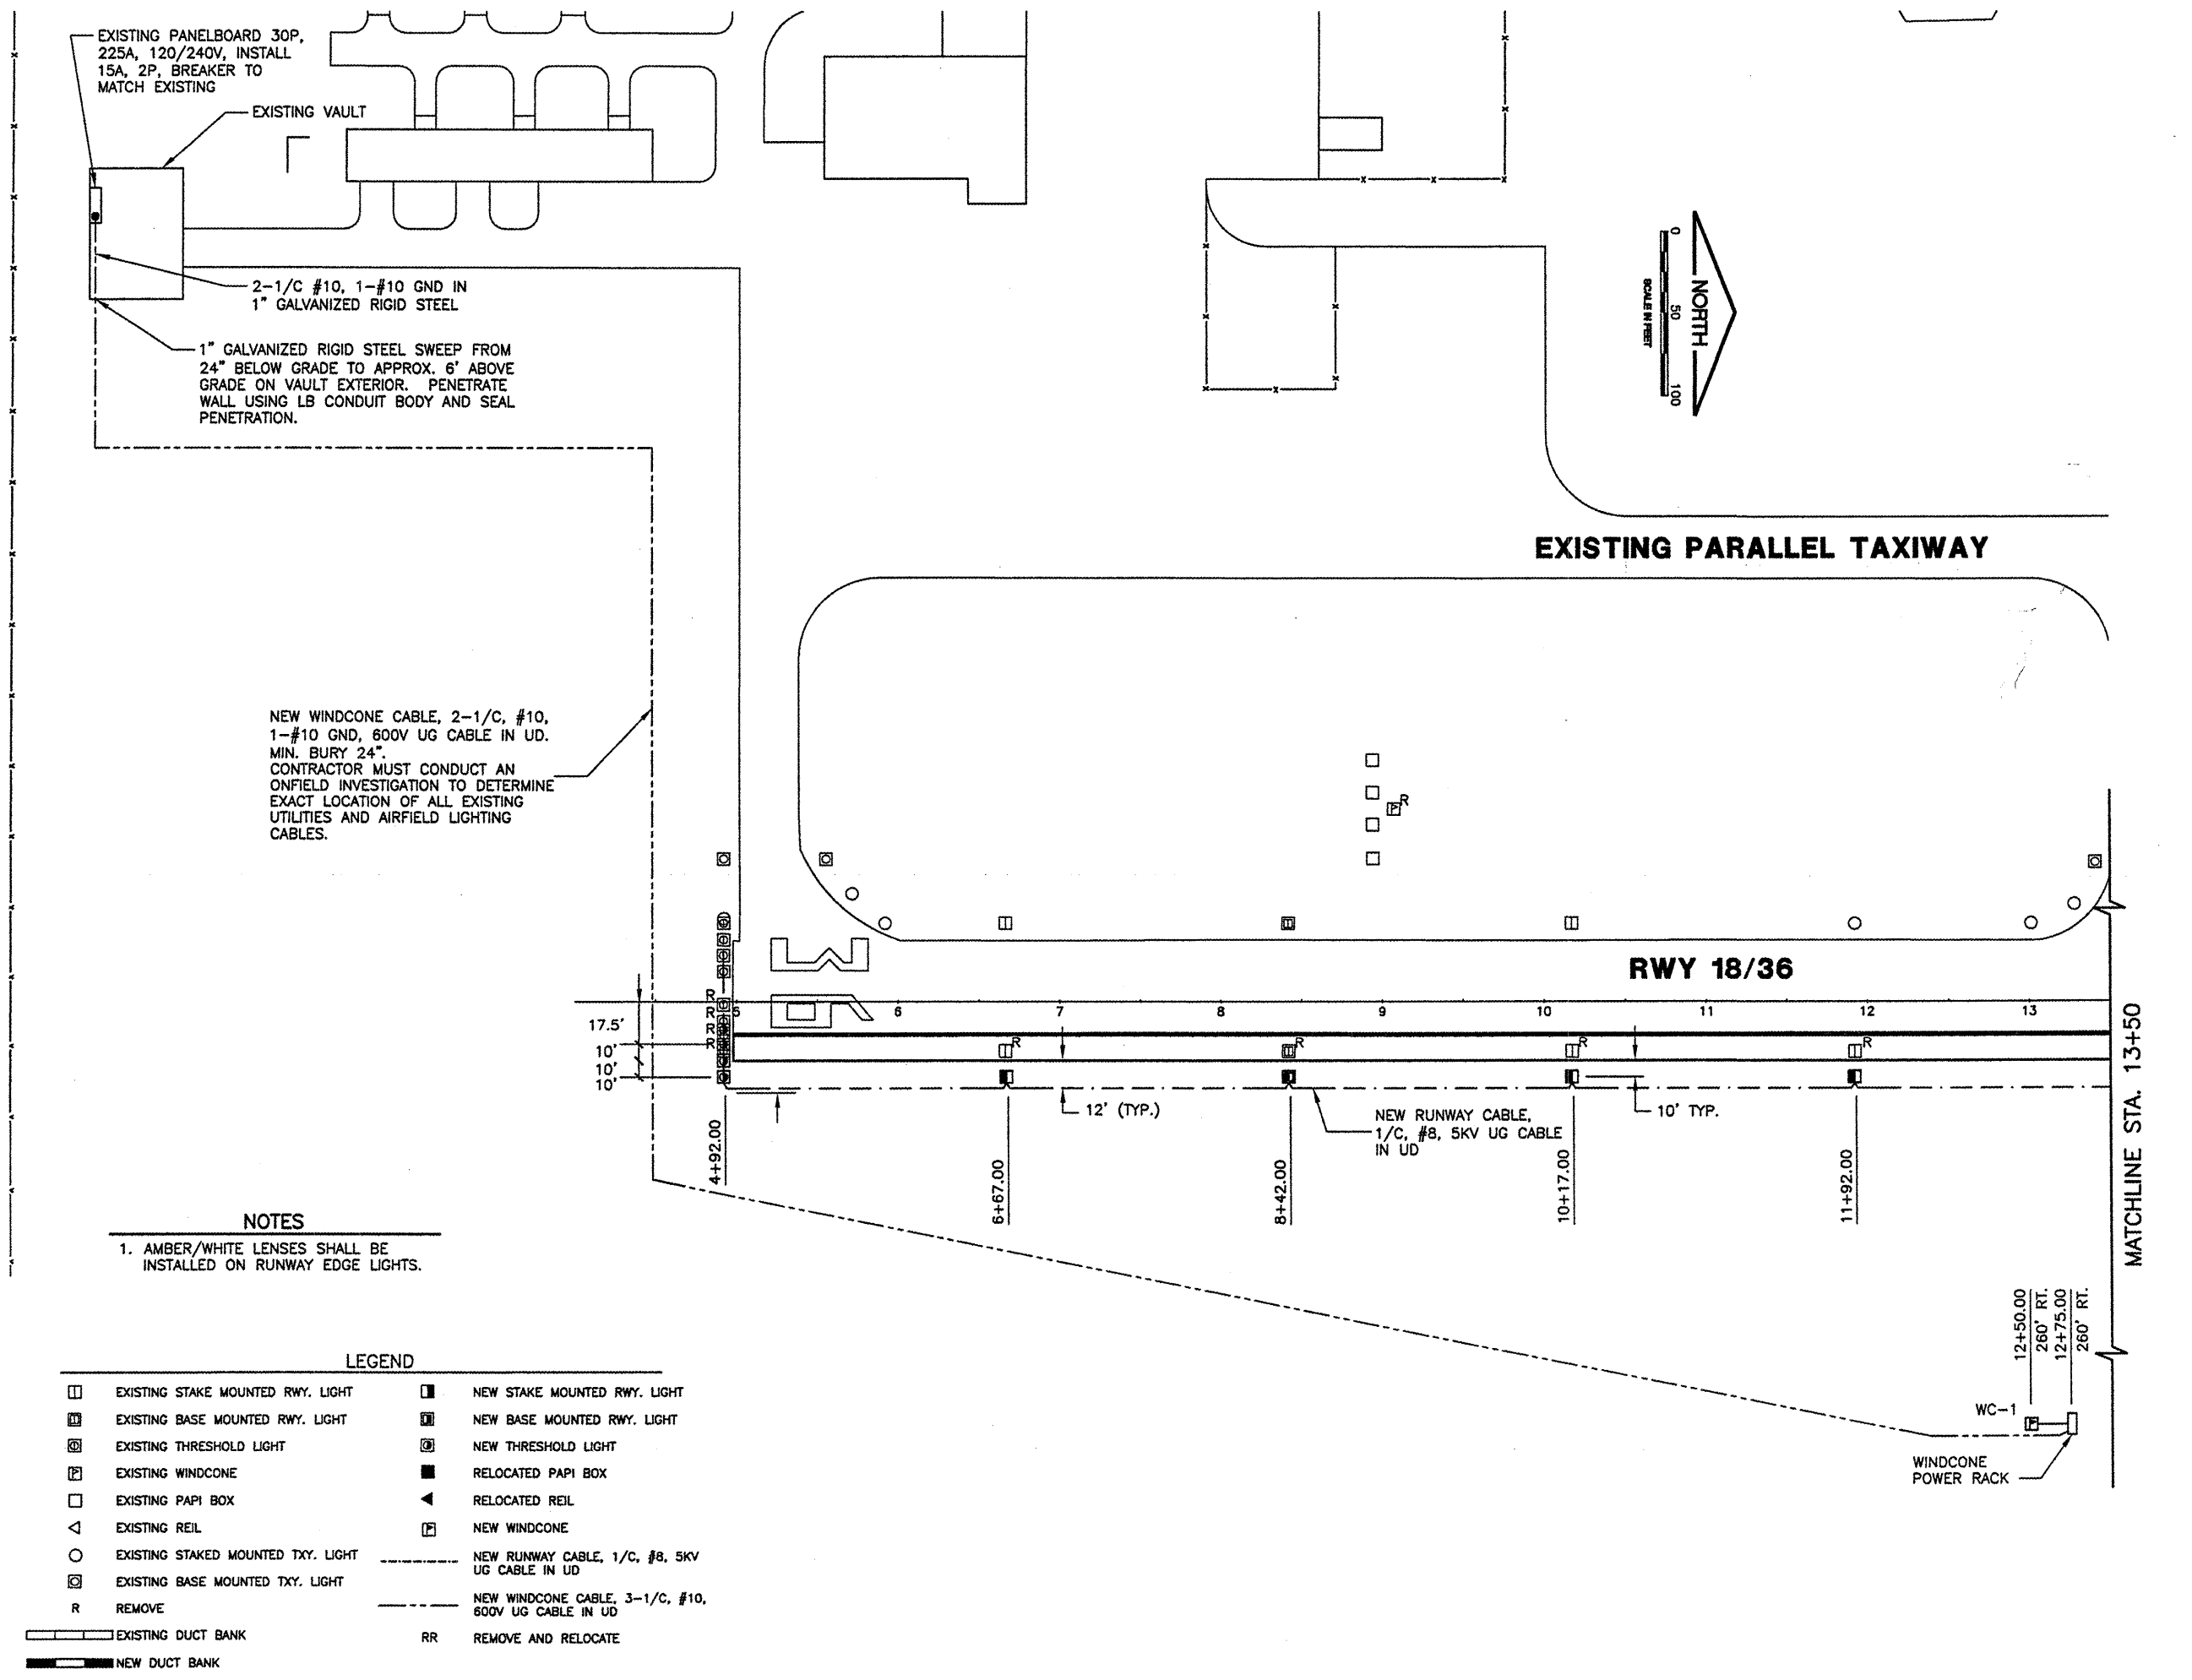

**NOTES**

1. AMBER/WHITE LENSES SHALL BE INSTALLED ON RUNWAY EDGE LIGHTS.

**LEGEND**

□	EXISTING STAKE MOUNTED RWY. LIGHT	■	NEW STAKE MOUNTED RWY. LIGHT
▣	EXISTING BASE MOUNTED RWY. LIGHT	▣	NEW BASE MOUNTED RWY. LIGHT
⊠	EXISTING THRESHOLD LIGHT	⊠	NEW THRESHOLD LIGHT
⊞	EXISTING WINDCONE	■	RELOCATED PAPI BOX
□	EXISTING PAPI BOX	◀	RELOCATED REIL
◁	EXISTING REIL	⊞	NEW WINDCONE
○	EXISTING STAKED MOUNTED TXY. LIGHT	---	NEW RUNWAY CABLE, 1/C, #8, 5KV UG CABLE IN UD
⊠	EXISTING BASE MOUNTED TXY. LIGHT	---	NEW WINDCONE CABLE, 3-1/C, #10, 600V UG CABLE IN UD
R	REMOVE	RR	REMOVE AND RELOCATE
▬	EXISTING DUCT BANK		
▬	NEW DUCT BANK		