 


REVISIONS		
NUMBER	BY	DATE






SPARTA COMMUNITY AIRPORT
 HUNTER FIELD
 SPARTA, ILLINOIS

WIDEN AND OVERLAY RUNWAY 18/36
 ELECTRICAL & LIGHTING PLAN 2

© Copyright CMT, Inc.
CMT
 CRAWFORD, MURPHY & TILLY, INC.
 CONSULTING ENGINEERS
 License No. 184-000613

DESIGN BY:	KLB
DRAWN BY:	CMT
CHECKED BY:	JEF
APPROVED BY:	JEF
DATE:	12/31/2008
JOB No:	0641203
IL PROJ. NO.	SAR-3652
AIP PROJ. NO.	3-17-0094-09
SHEET	09 OF 28 SHEETS

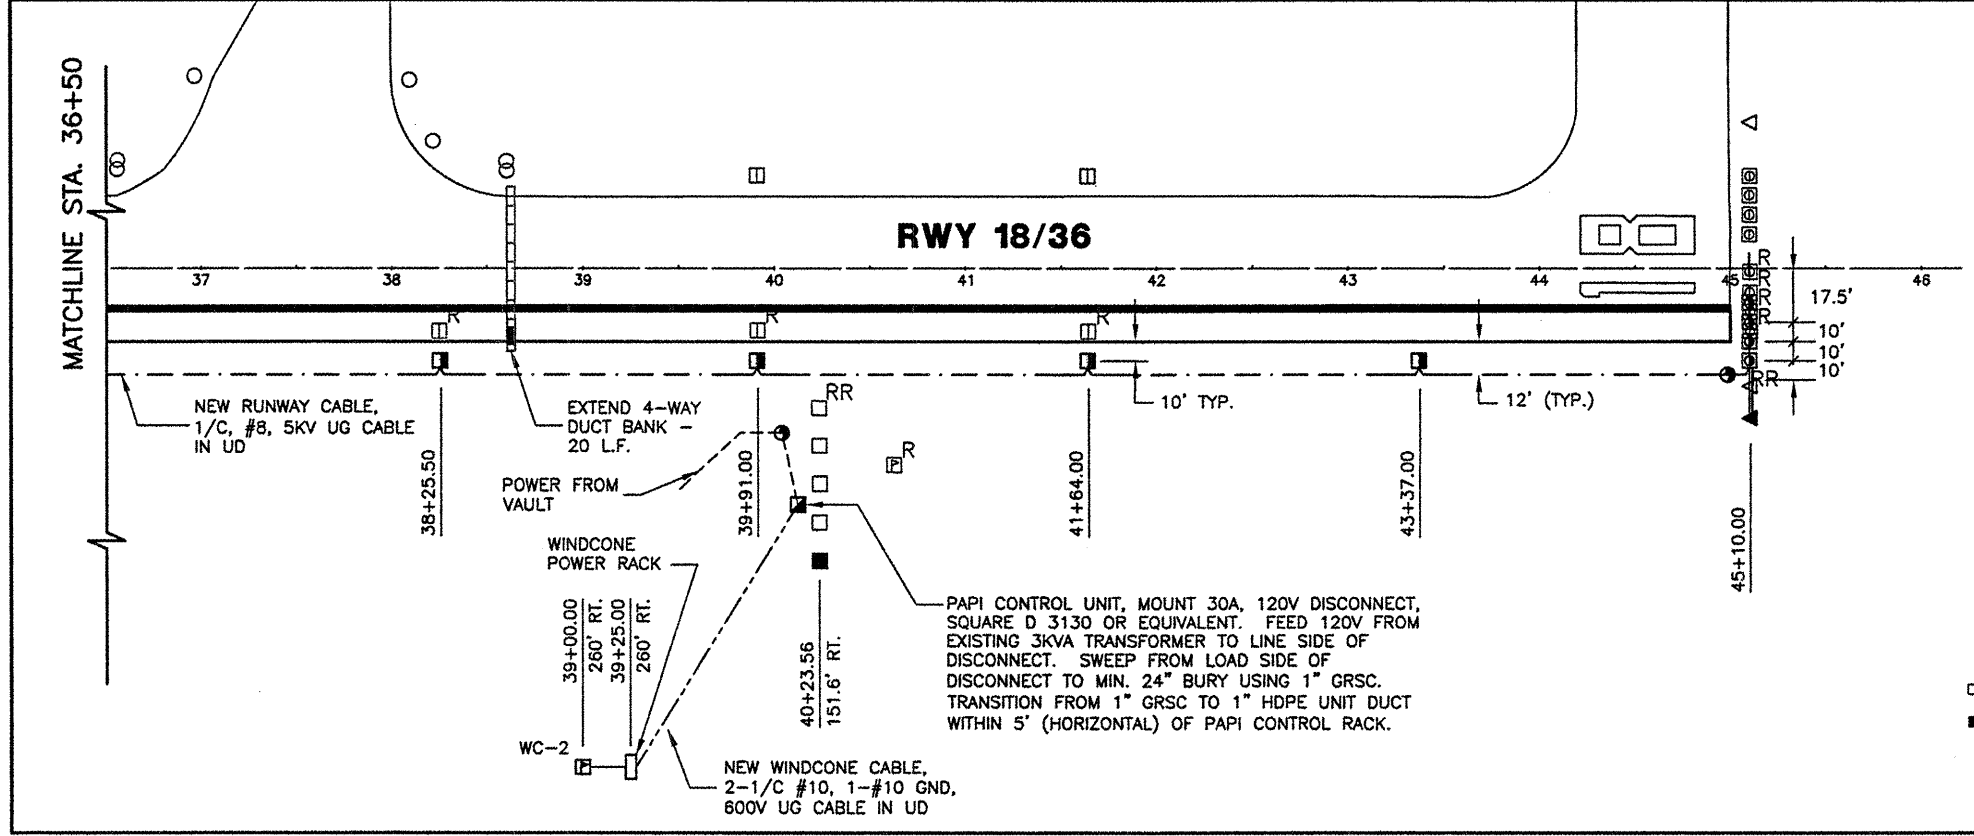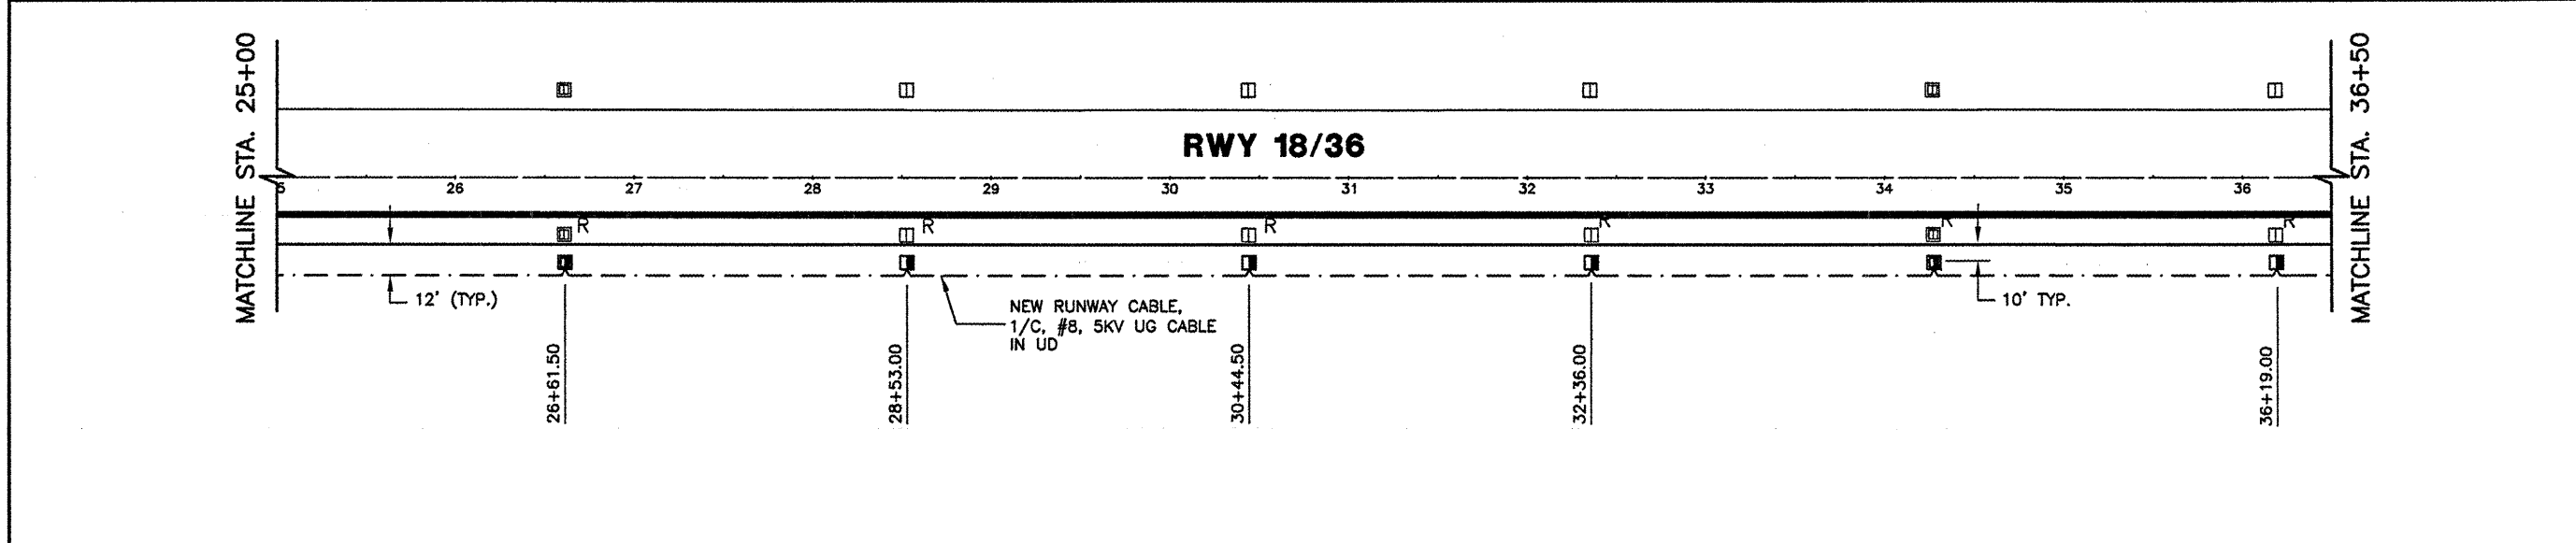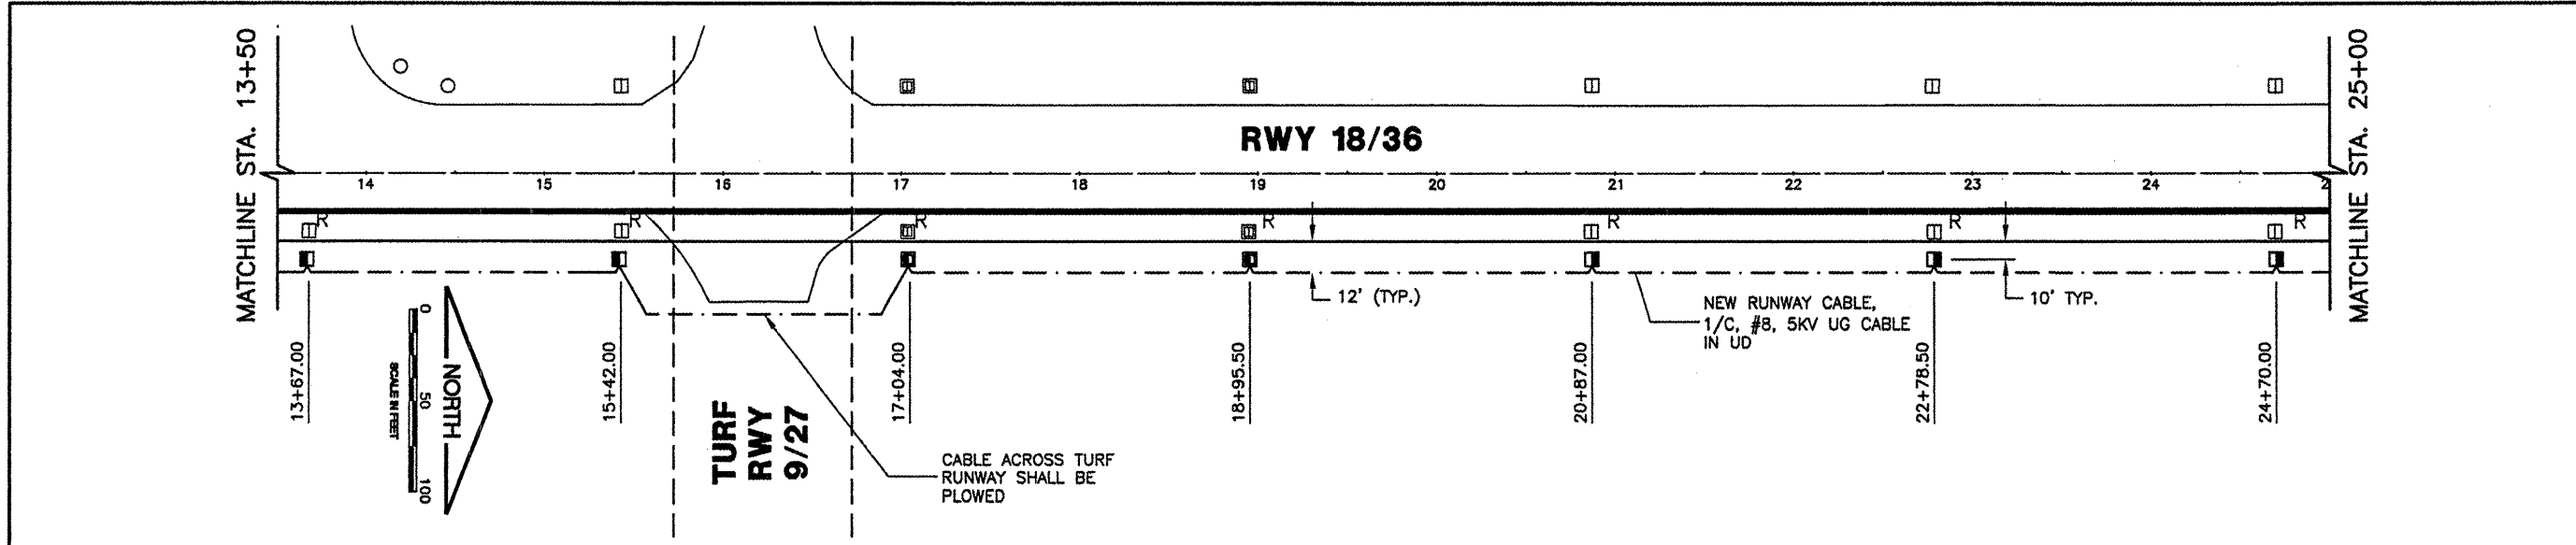

NOTES
 1. AMBER/WHITE LENSES SHALL BE INSTALLED ON RUNWAY EDGE LIGHTS.

LEGEND	
	EXISTING STAKE MOUNTED RWY. LIGHT
	EXISTING BASE MOUNTED RWY. LIGHT
	EXISTING THRESHOLD LIGHT
	EXISTING WINDCONE
	EXISTING PAPI BOX
	EXISTING REIL
	EXISTING STAKED MOUNTED TXY. LIGHT
	EXISTING BASE MOUNTED TXY. LIGHT
	REMOVE
	EXISTING DUCT BANK
	NEW DUCT BANK
	NEW STAKE MOUNTED RWY. LIGHT
	NEW BASE MOUNTED RWY. LIGHT
	NEW THRESHOLD LIGHT
	RELOCATED PAPI CONTROL
	RELOCATED PAPI BOX
	RELOCATED REIL
	SPLICE CAN
	NEW WINDCONE
	NEW RUNWAY CABLE, 1/C, #8, 5KV UG CABLE IN UD
	NEW WINDCONE CABLE, 3-1/C, #10, 600V UG CABLE IN UD
	REMOVE AND RELOCATE