
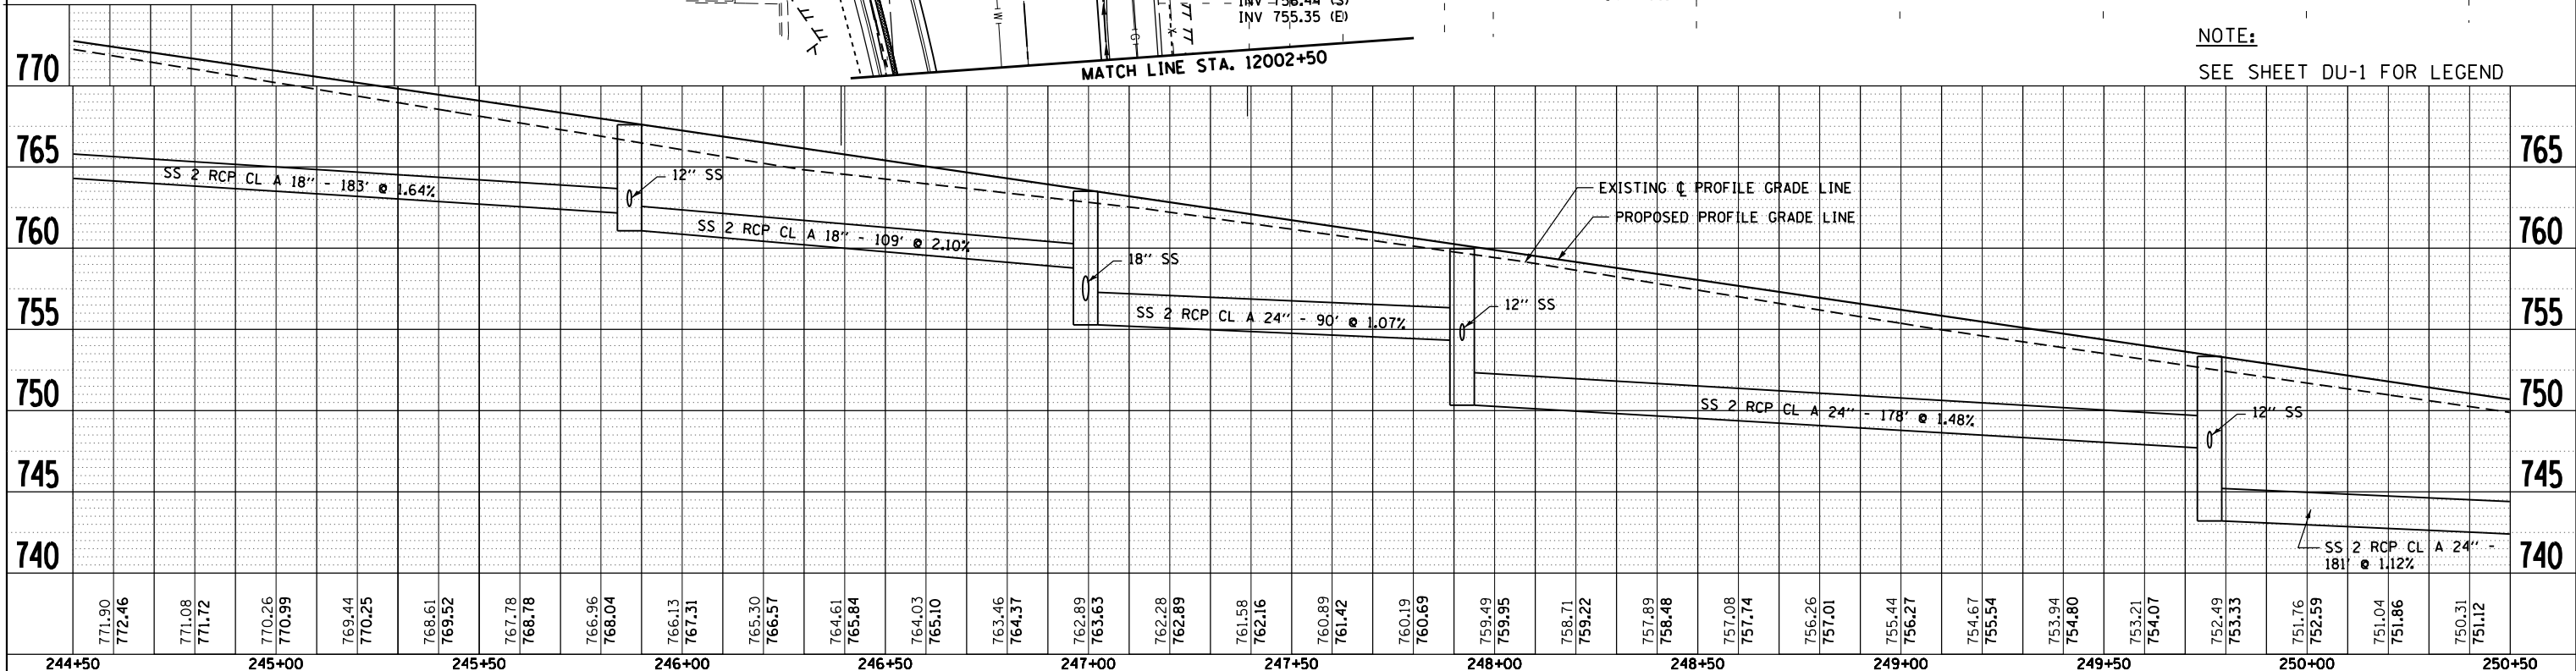


PLAN	SURVEYED	DATE
	PLOTTED	
	ALIGNED	
	CHECKED	
	FILE NAME	
	NO.	

PROFILE	SURVEYED	DATE
	PLOTTED	
	GRADES CHECKED	
	STRUCTURE	
	NOT THIS COPY	
	NO.	

McDonough Associates Inc.  
Engineers/Architects  
130 East Randolph Street Chicago, Illinois 60601

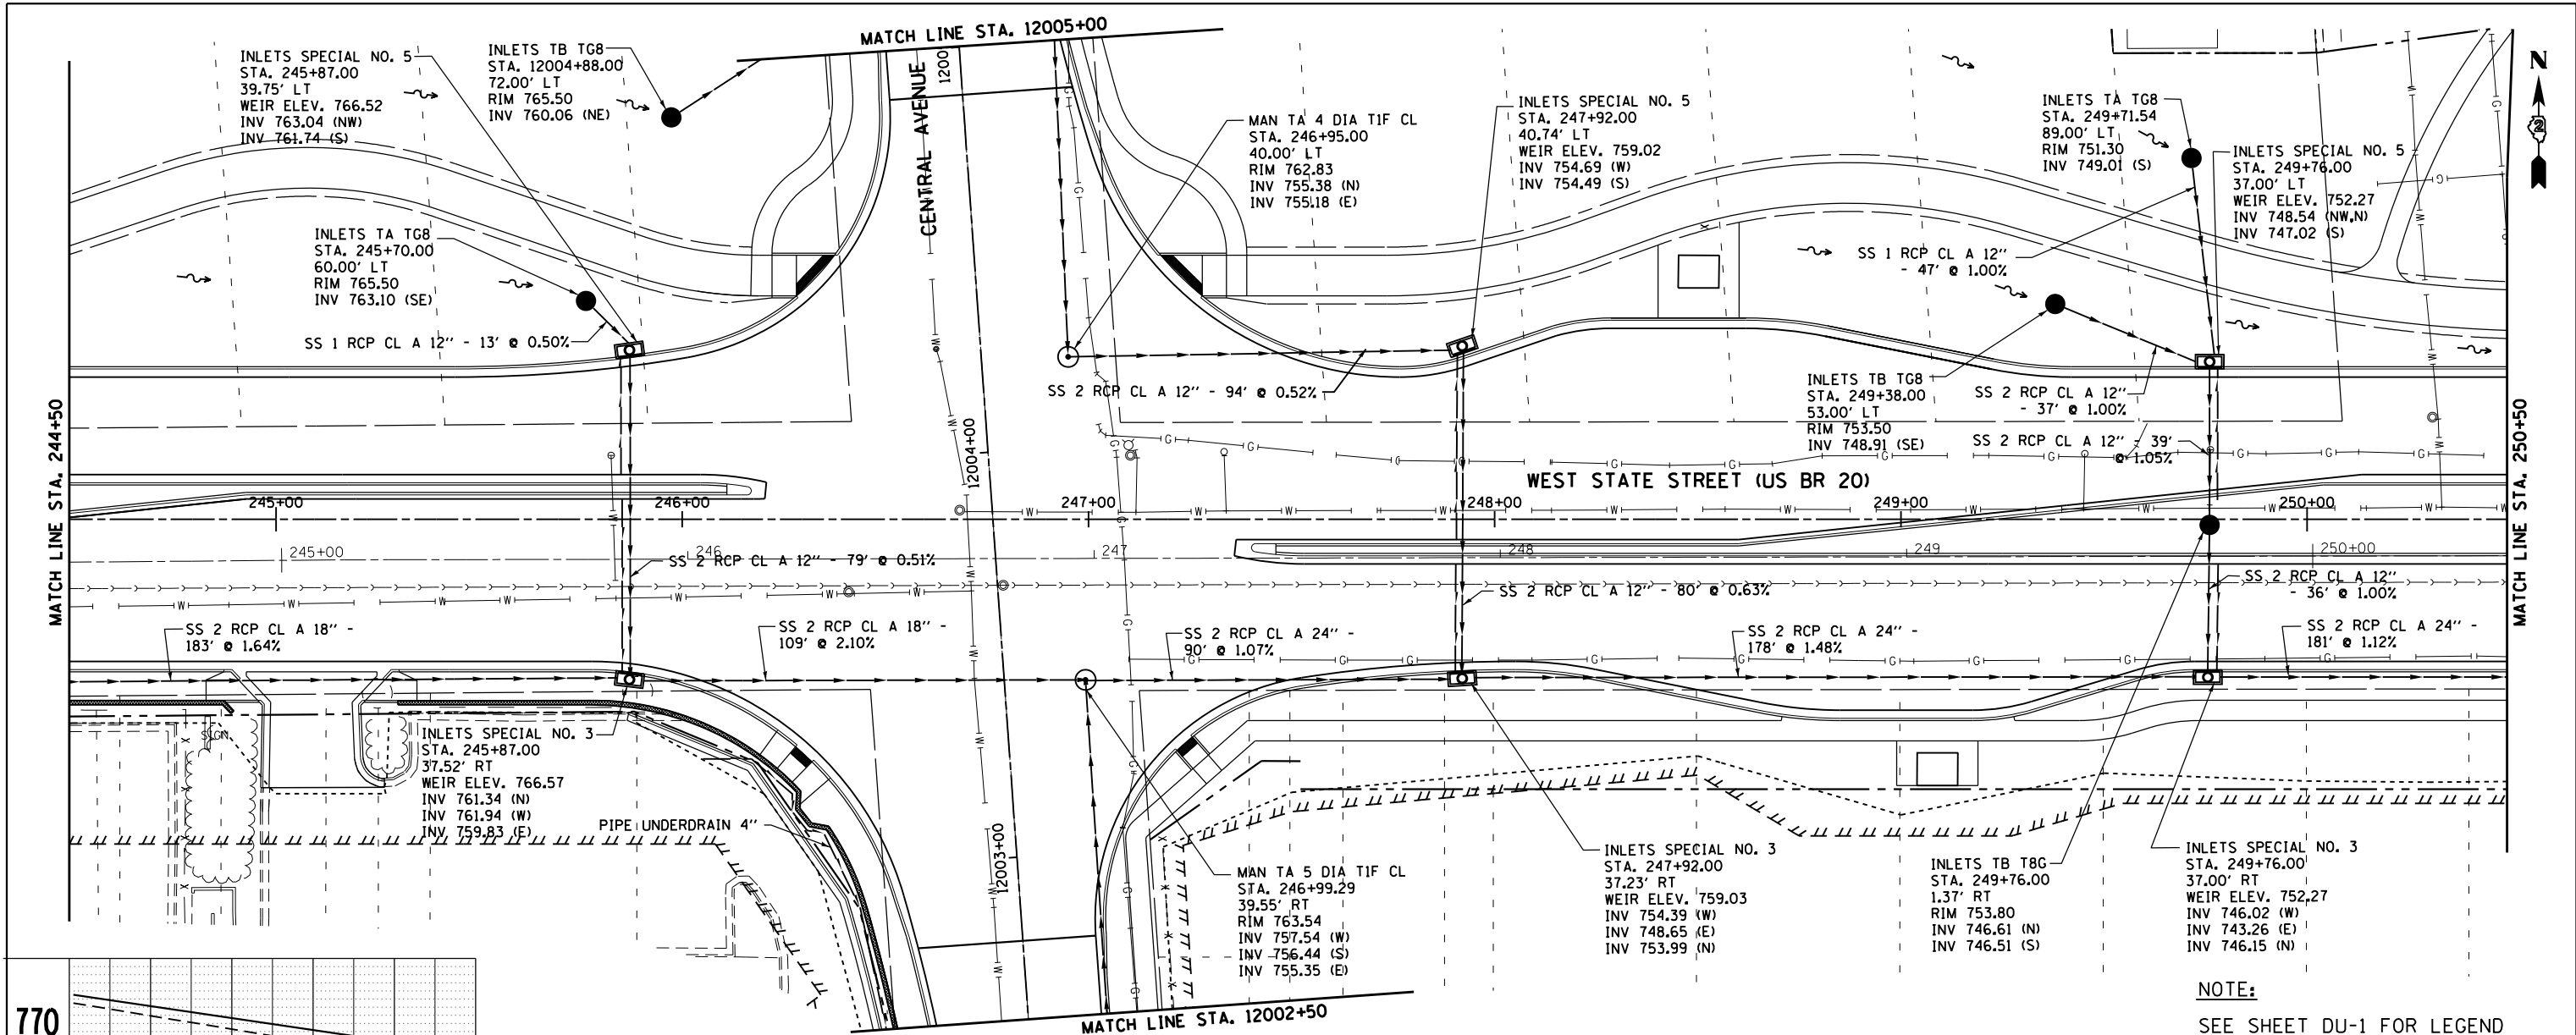

NOTE:  
SEE SHEET DU-1 FOR LEGEND

FILE NAME =	USER NAME = dssdd	DESIGNED - JWM	REVISED -	<b>STATE OF ILLINOIS</b> <b>DEPARTMENT OF TRANSPORTATION</b>	<b>PROPOSED DRAINAGE PLAN AND PROFILE</b> <b>WEST STATE ST (US BUS 20)</b>		F.A.P. RTE. 303	SECTION 41R	COUNTY WINNEBAGO	TOTAL SHEETS 327	SHEET NO. 146	
c:\pwork\pwork\dssdd\0317619\0264750	sh-t-drain-146.dgn	DRAWN - JPF	REVISED -		SCALE:	SHEET NO. 2 OF 21 SHEETS	STA. TO STA.	FED. ROAD DIST. NO. 2	ILLINOIS FED. AID PROJECT	CONTRACT NO. 64750		
		CHECKED - RCH	REVISED -									
		DATE - \$SUBDATE\$	REVISED -									