



PLAN	SURVEYED	DATE
	PLOTTED	BY
	ALIGNED	
	CHECKED	
	NO. 1	
	NO. 2	
	NO. 3	
	NO. 4	
	NO. 5	
	NO. 6	
	NO. 7	
	NO. 8	
	NO. 9	
	NO. 10	

PROFILE	SURVEYED	DATE
	PLOTTED	BY
	GRADES CHECKED	
	STRUCTURE NOTATIONS CHECKED	
	NO. 1	
	NO. 2	
	NO. 3	
	NO. 4	
	NO. 5	
	NO. 6	
	NO. 7	
	NO. 8	
	NO. 9	
	NO. 10	

McDonough Associates Inc.
 Engineers/Architects
 130 East Randolph Street Chicago, Illinois 60601

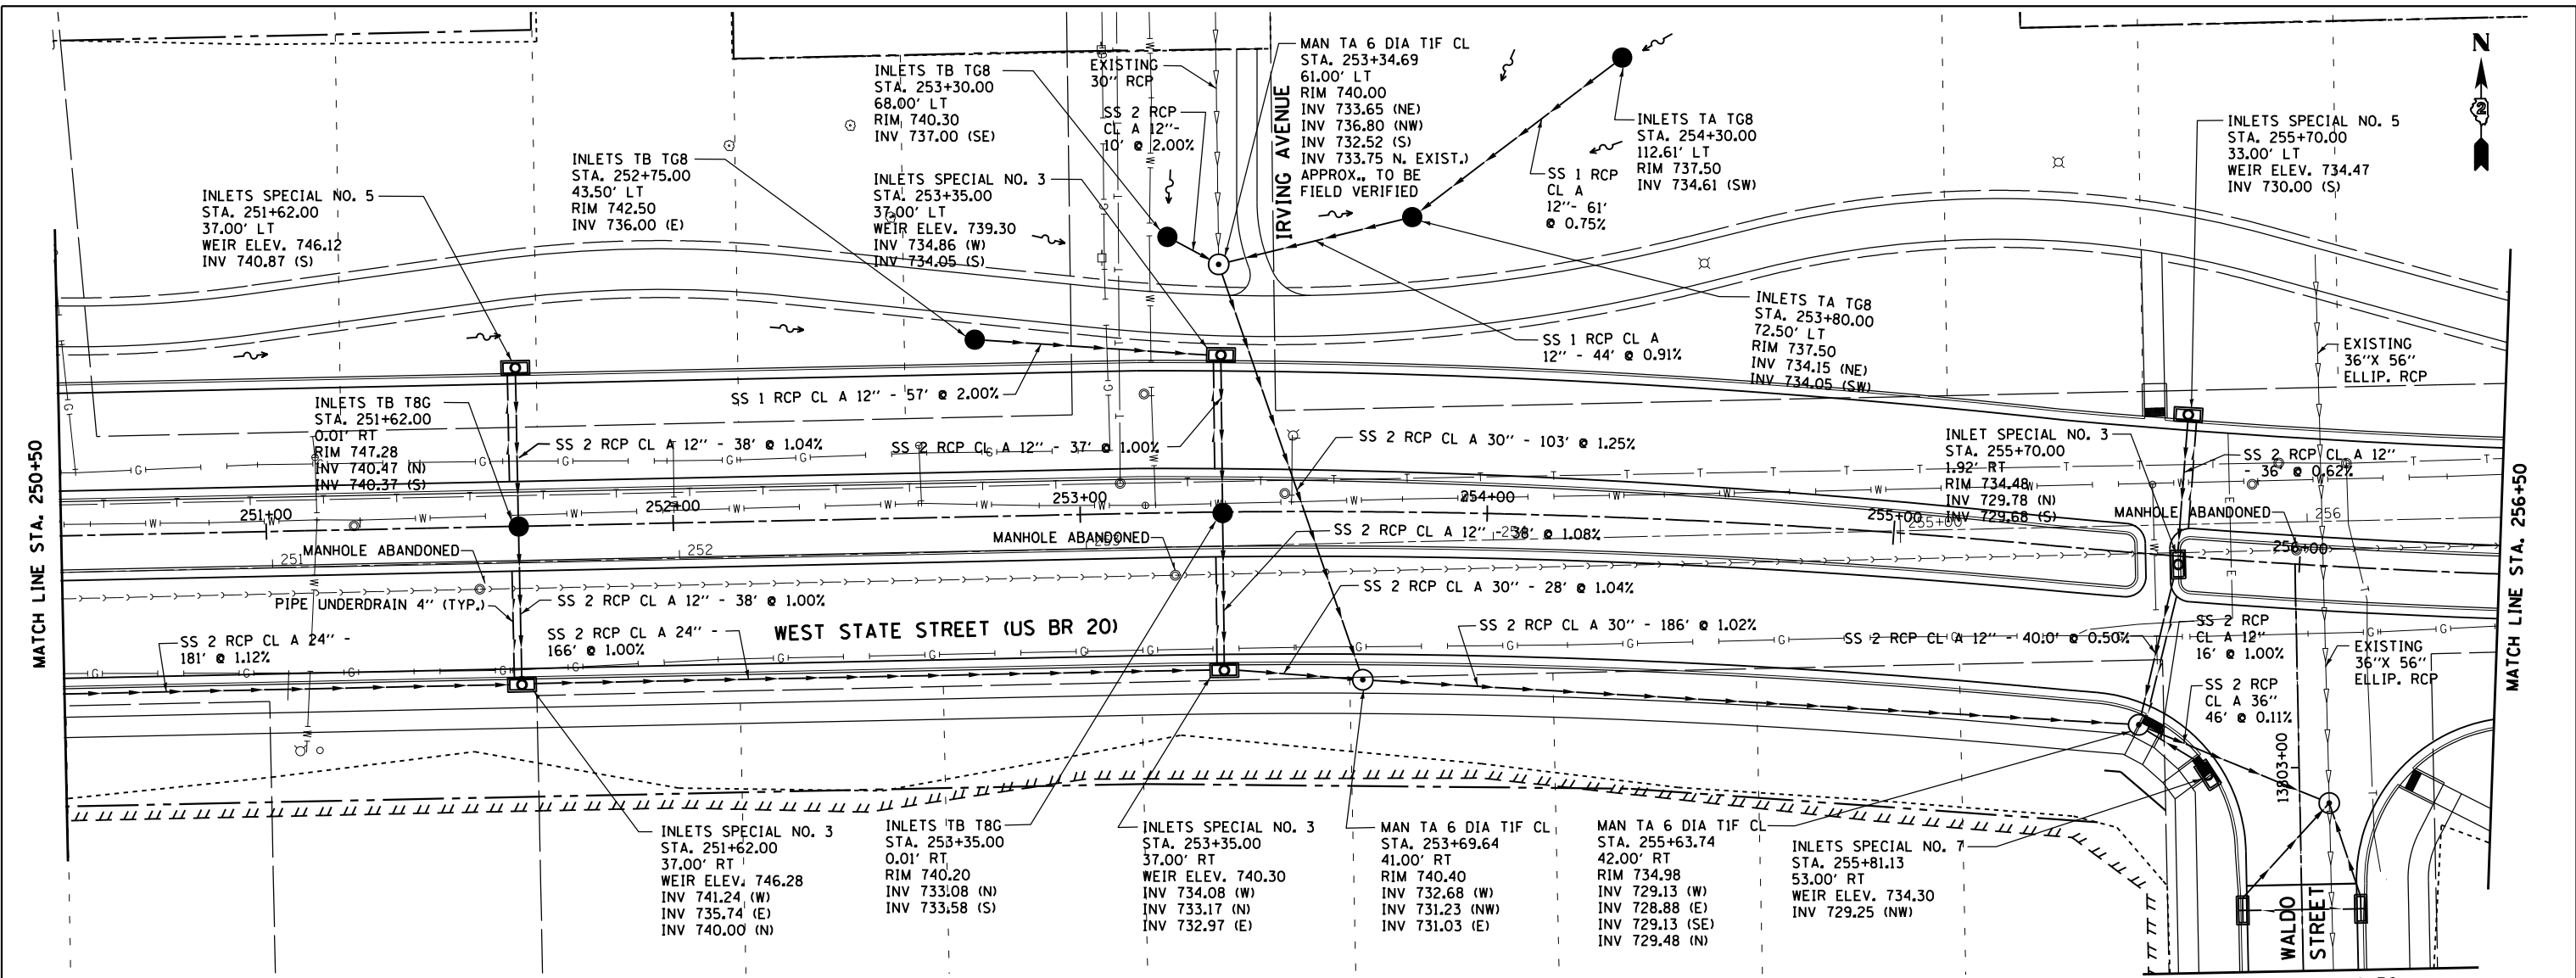

NOTE:
 SEE SHEET DU-1 FOR LEGEND

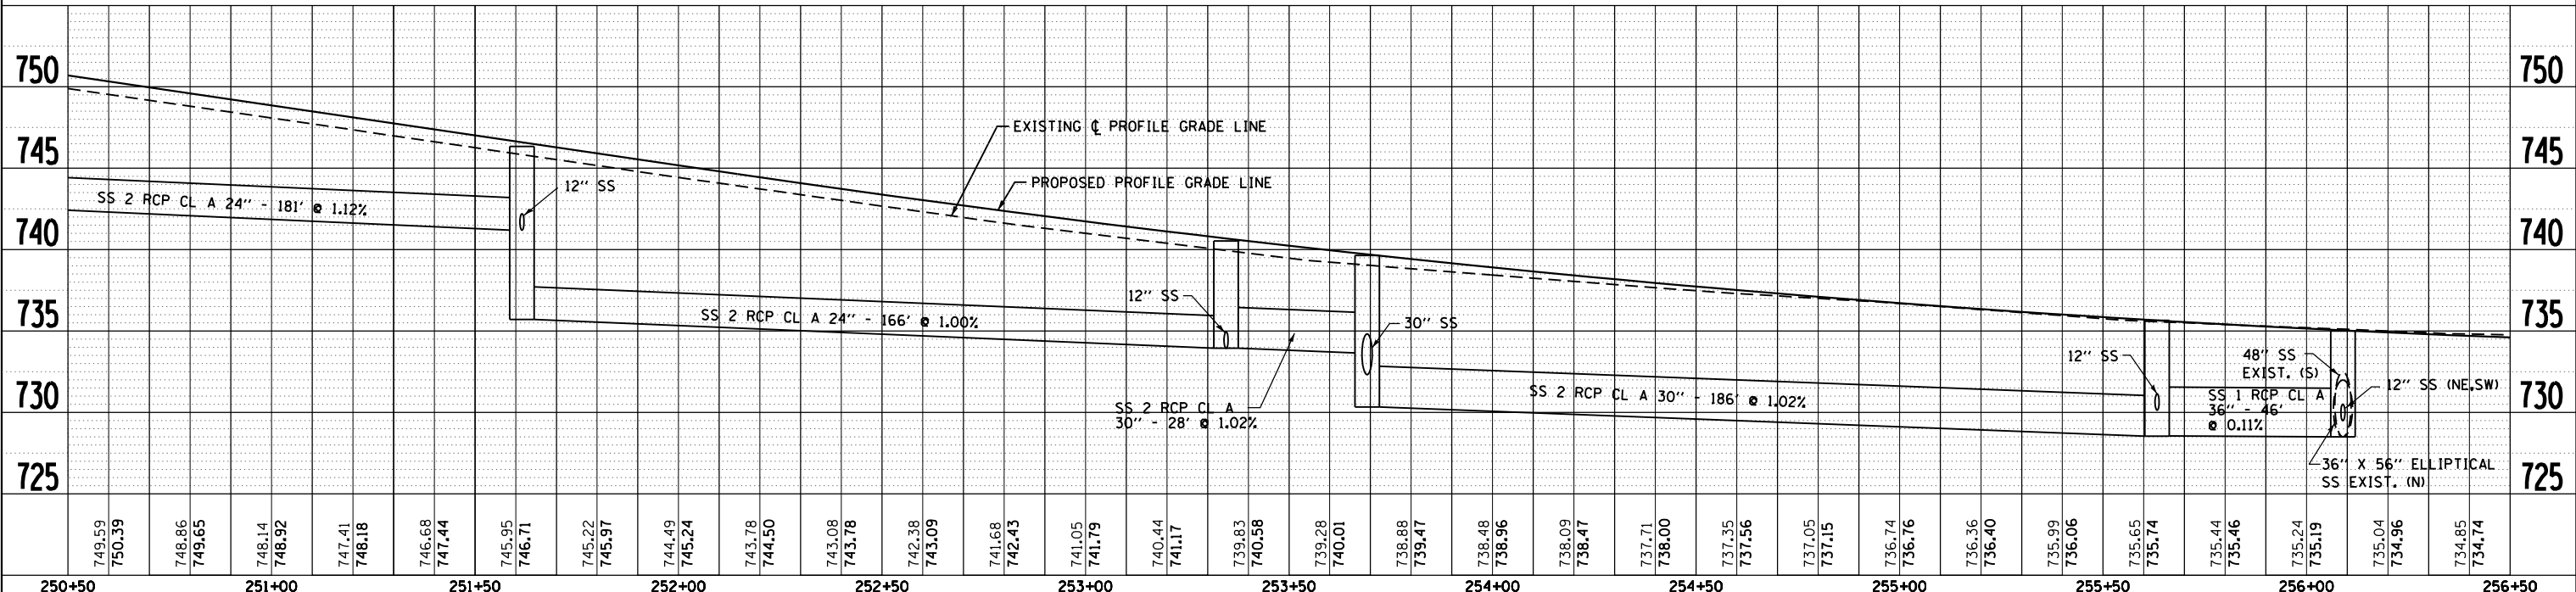

FILE NAME =	USER NAME = dssdd	DESIGNED - EJD	REVISED -	STATE OF ILLINOIS DEPARTMENT OF TRANSPORTATION	PROPOSED DRAINAGE PLAN AND PROFILE WEST STATE ST (US BUS 20)	F.A.P. RTE. = 303	SECTION = 41R	COUNTY = WINNEBAGO	TOTAL SHEETS = 327	SHEET NO. = 147	
CONTRACT NO. = 64750	DATE = \$SUBDATE\$	CHECKED - RCH	REVISED -			SCALE:	SHEET NO. 3 OF 21 SHEETS	STA. TO STA.	FED. ROAD DIST. NO. 2 ILLINOIS FED. AID PROJECT		
PLOT SCALE = 40.0000' / in.		DRAWN - EJD	REVISED -								
PLOT DATE = Mon Dec 17 14:49:51 2012			REVISED -								